




**LARGE SCALE PAVILLION
WATER & PIPING FLOOR PLAN**
SCALE: 1/4" = 1'-0"

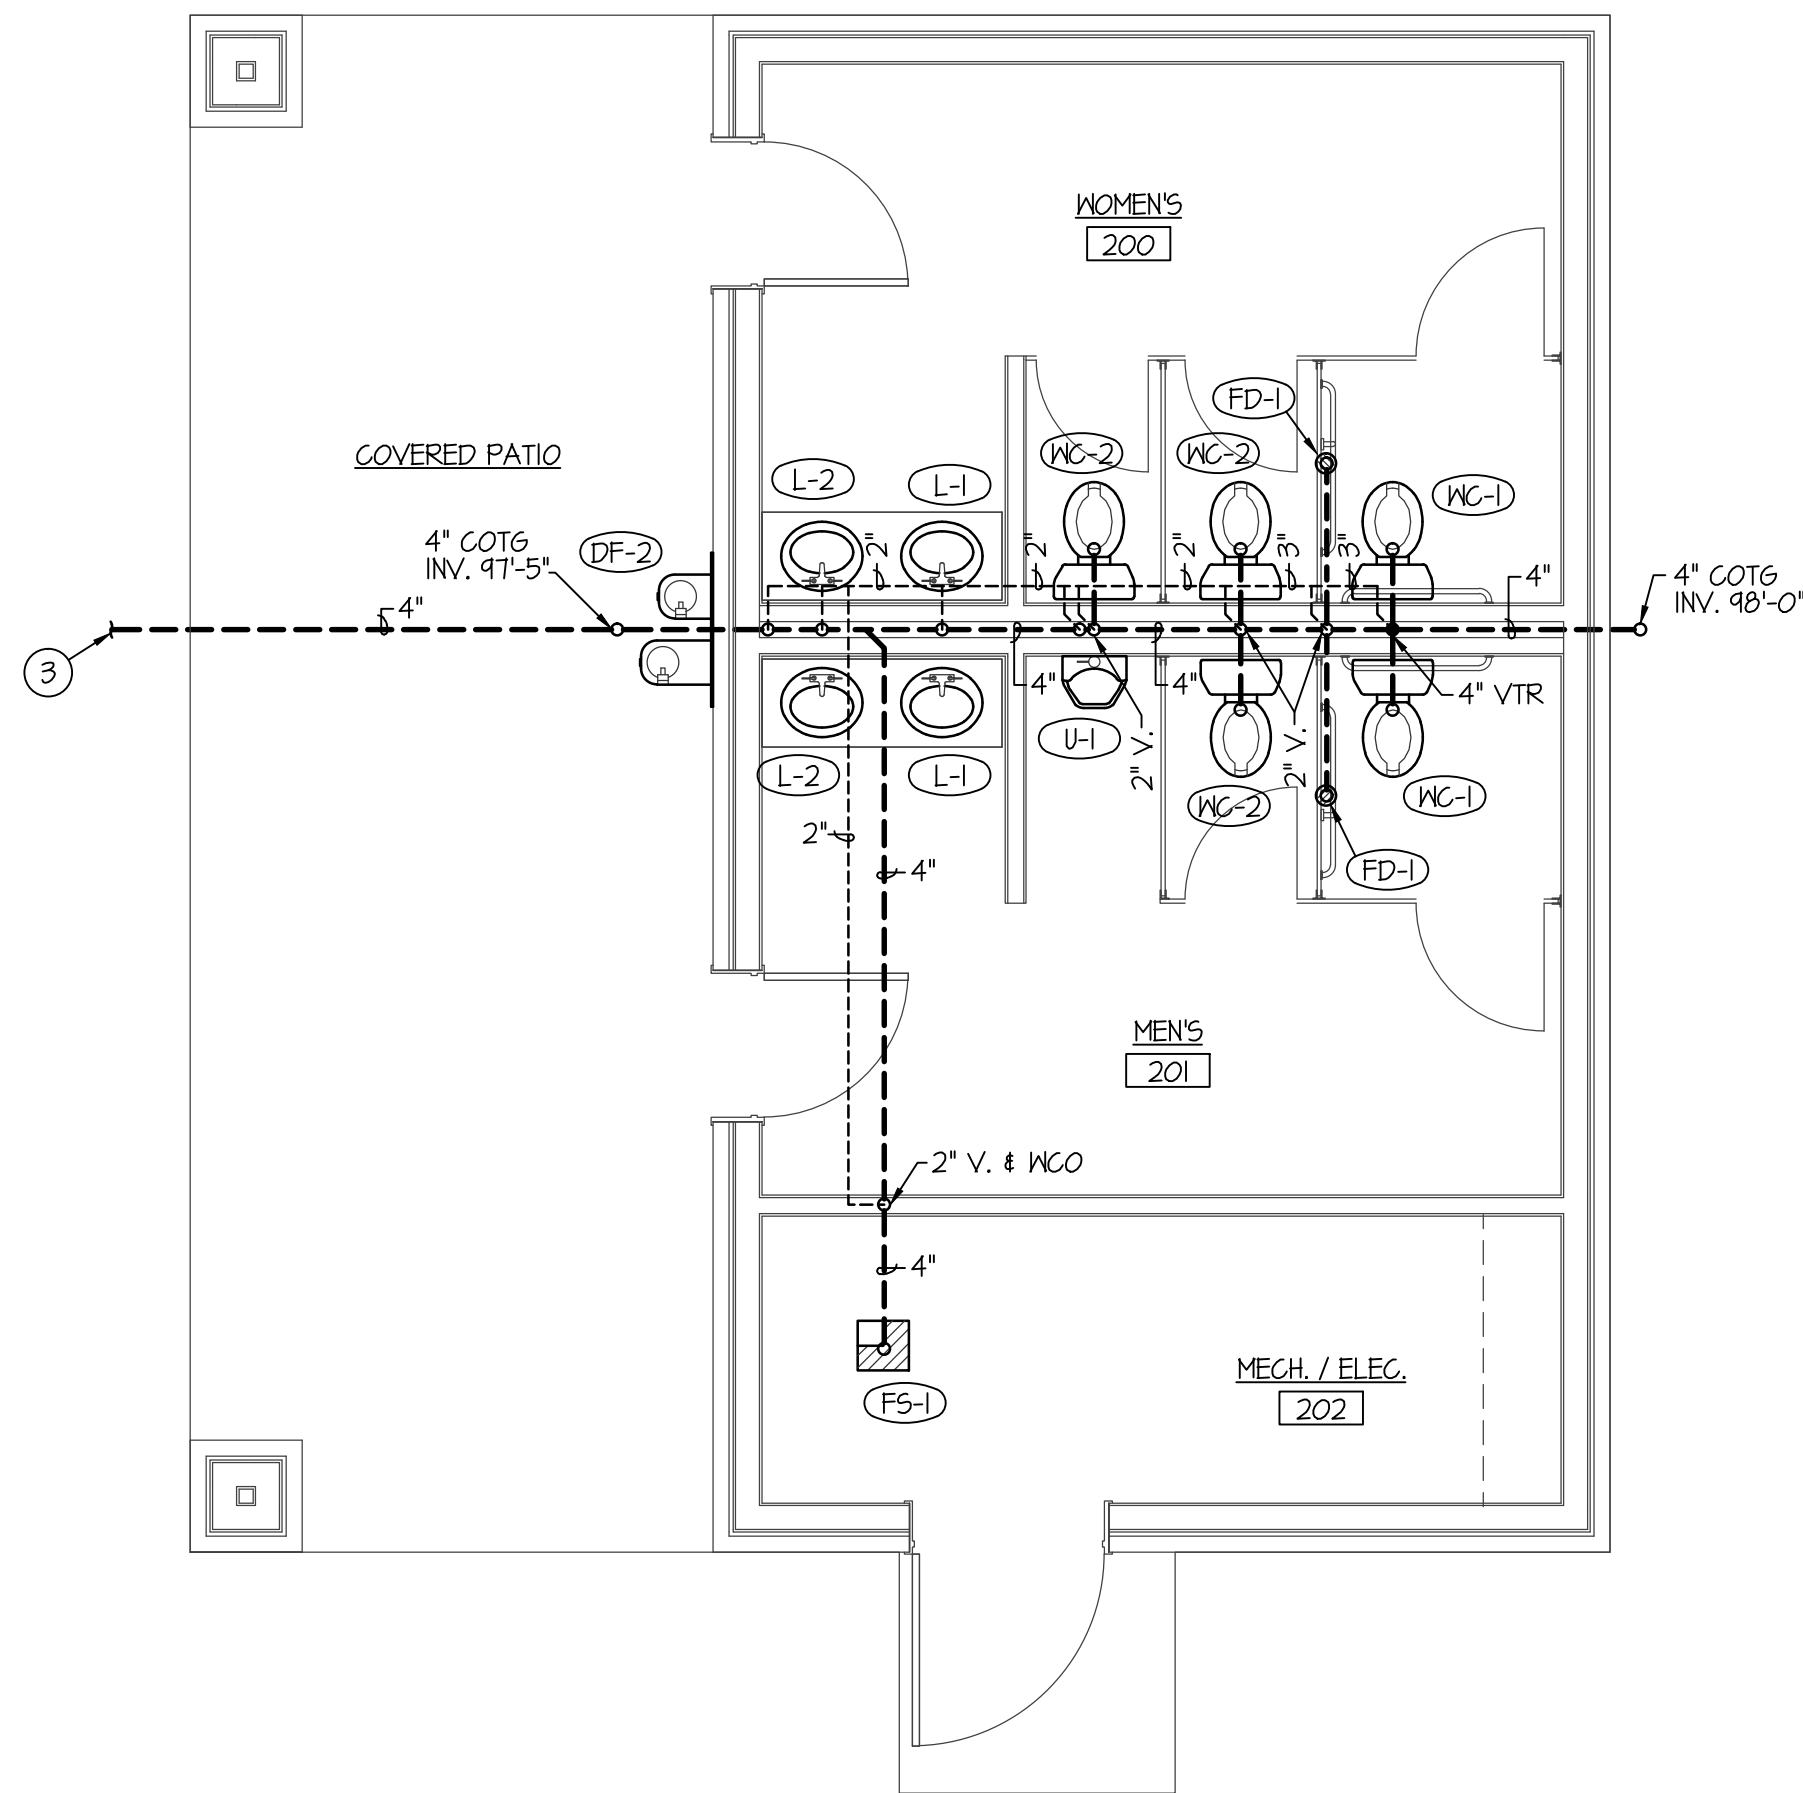


**LARGE SCALE PAVILLION
WASTE & VENT PIPING FLOOR PLAN**
SCALE: 1/4" = 1'-0"

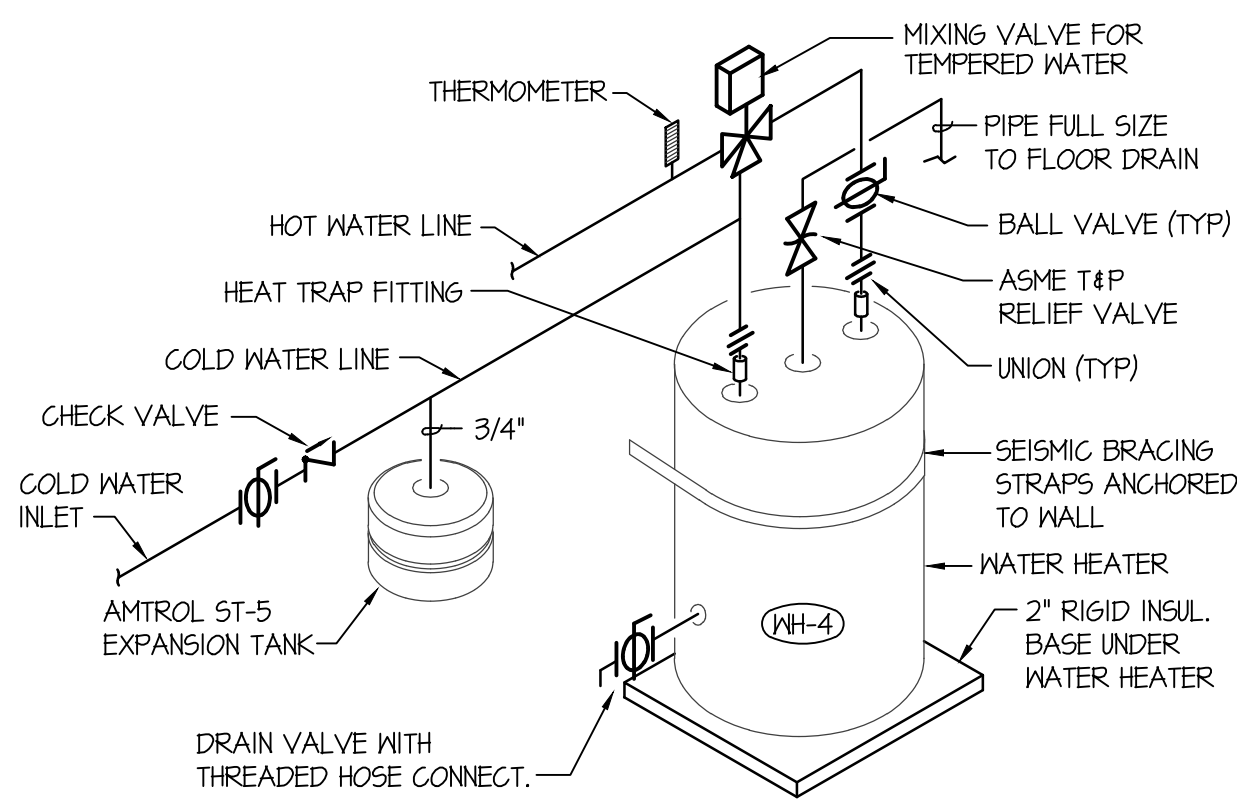

WATER HEATER PIPING DIAGRAM
NO SCALE

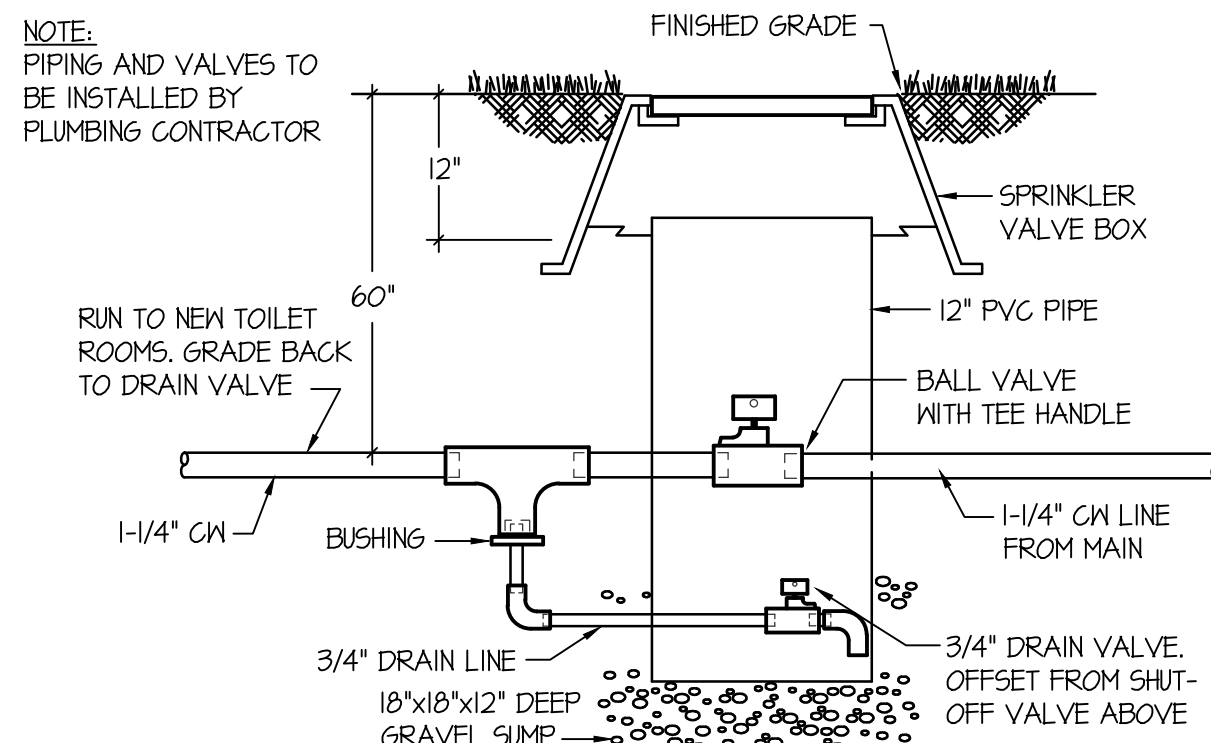

STOP & WASTE VALVE DETAIL
NO SCALE

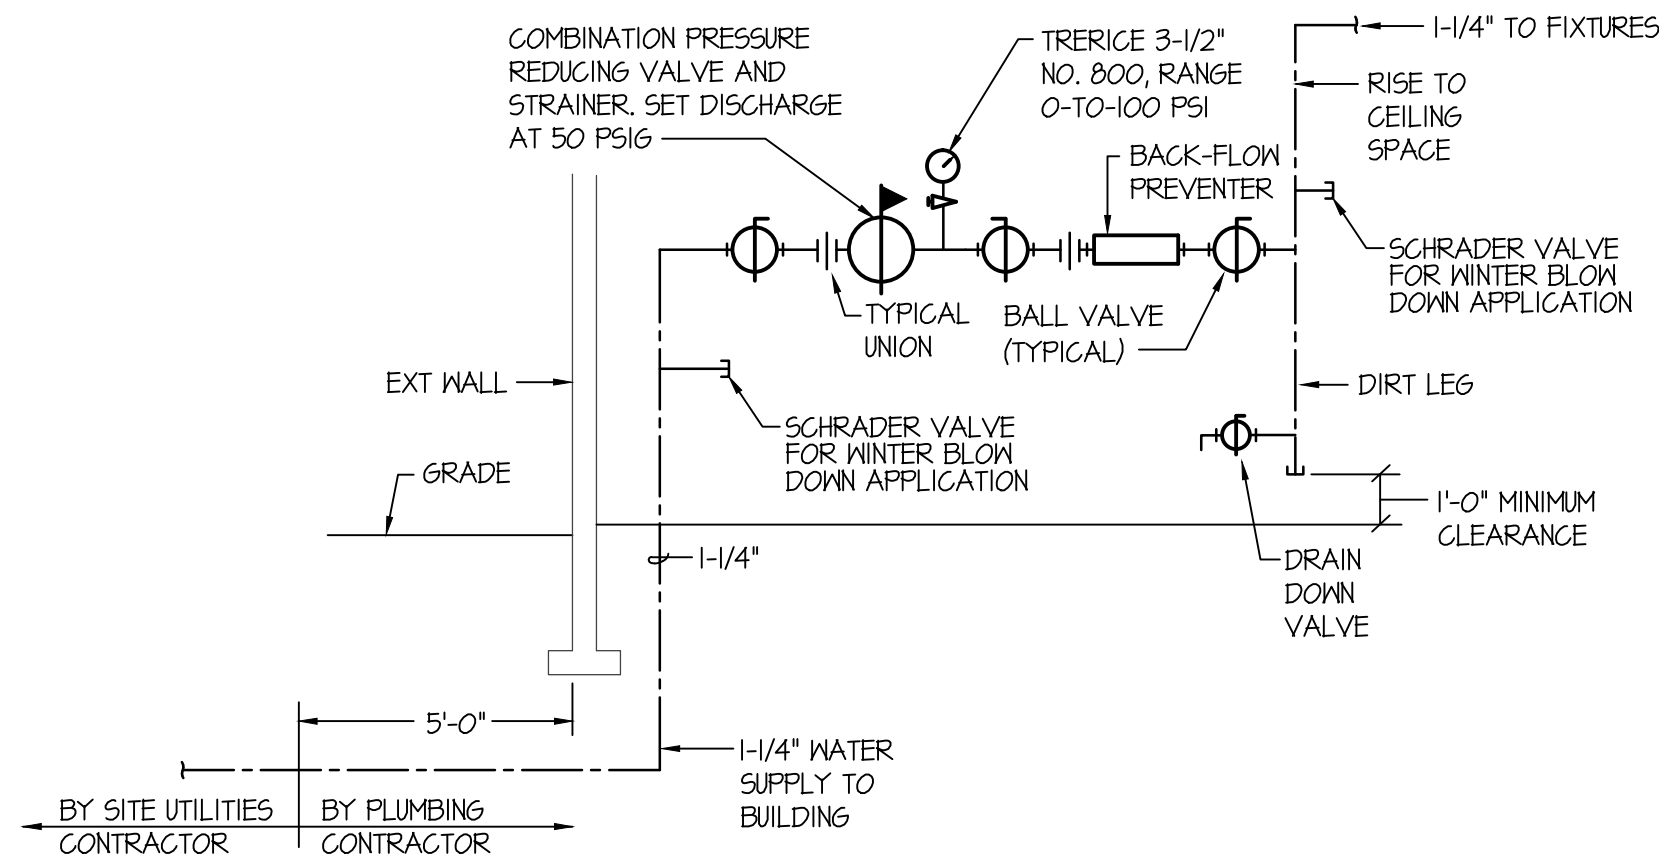

**PAVILLION BUILDING WATER
PRESSURE REDUCING STATION DETAIL**
NO SCALE

PLAN NOTES:

- SEE CIVIL SITE PLAN FOR CONTINUATION OF 1-1/4" DOMESTIC CM LINE.
- RISE 1-1/4" DOMESTIC CM LINE UP THRU SLAB OF RISER TO PRV STATION. SEE DETAIL ON THIS SHEET.
- SEE CIVIL SITE PLAN FOR CONTINUATION OF 4" WASTE LINE.
- INSTALL STOP AND WASTE VALVE ASSEMBLY IN LAWN IRRIGATION BOX IN LOCATION SHOWN. SEE DETAIL ON THIS SHEET.
- RUN WATER PIPING LATERALLY IN WALL ABOVE DOOR HEADERS TO SERVE FIXTURES. ALL PIPING TO SLOPE DOWN TOWARDS STOP AND WASTE DRAIN.

SEAL:

REV DATE DESCRIPTION

PROJECT: A NEW BUILDING FOR:
IGLESIA DE JESUCRISTO PALABRA MIEL
2504 F AVENUE
MEAD, CO 80542


PROJECT:

SHEET TITLE:
LARGE SCALE PAVILLION
PLUMBING PLANS

SHEET NUMBER:

P201

DO NOT SCALE DRAWING

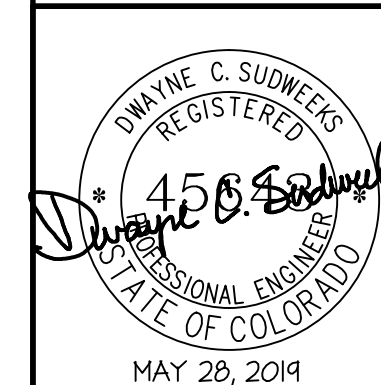

**Engineered
Systems
Associates**
1355 EAST CENTER
POCATELLO, IDAHO 83201
PHONE: (208) 233-0501
FAX: (208) 233-0529
EMAIL: esa@engsystems.com
ESA JOB NUMBER: 15130

