




A | EXPOSED DUCT INSULATION NO SCALE

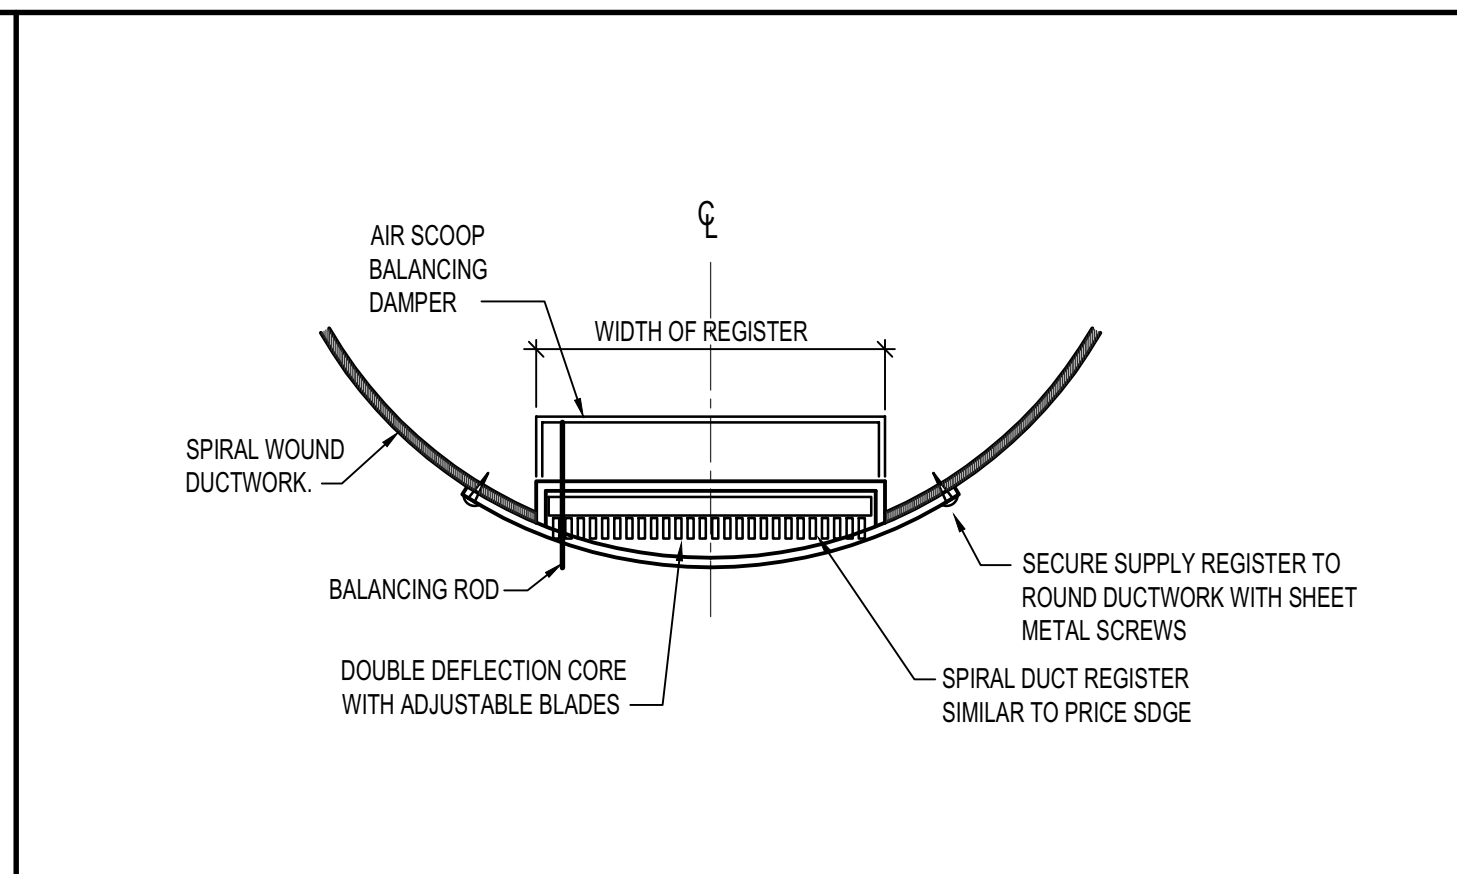


B | GRILLE IN ROUND DUCT DETAIL NO SCALE

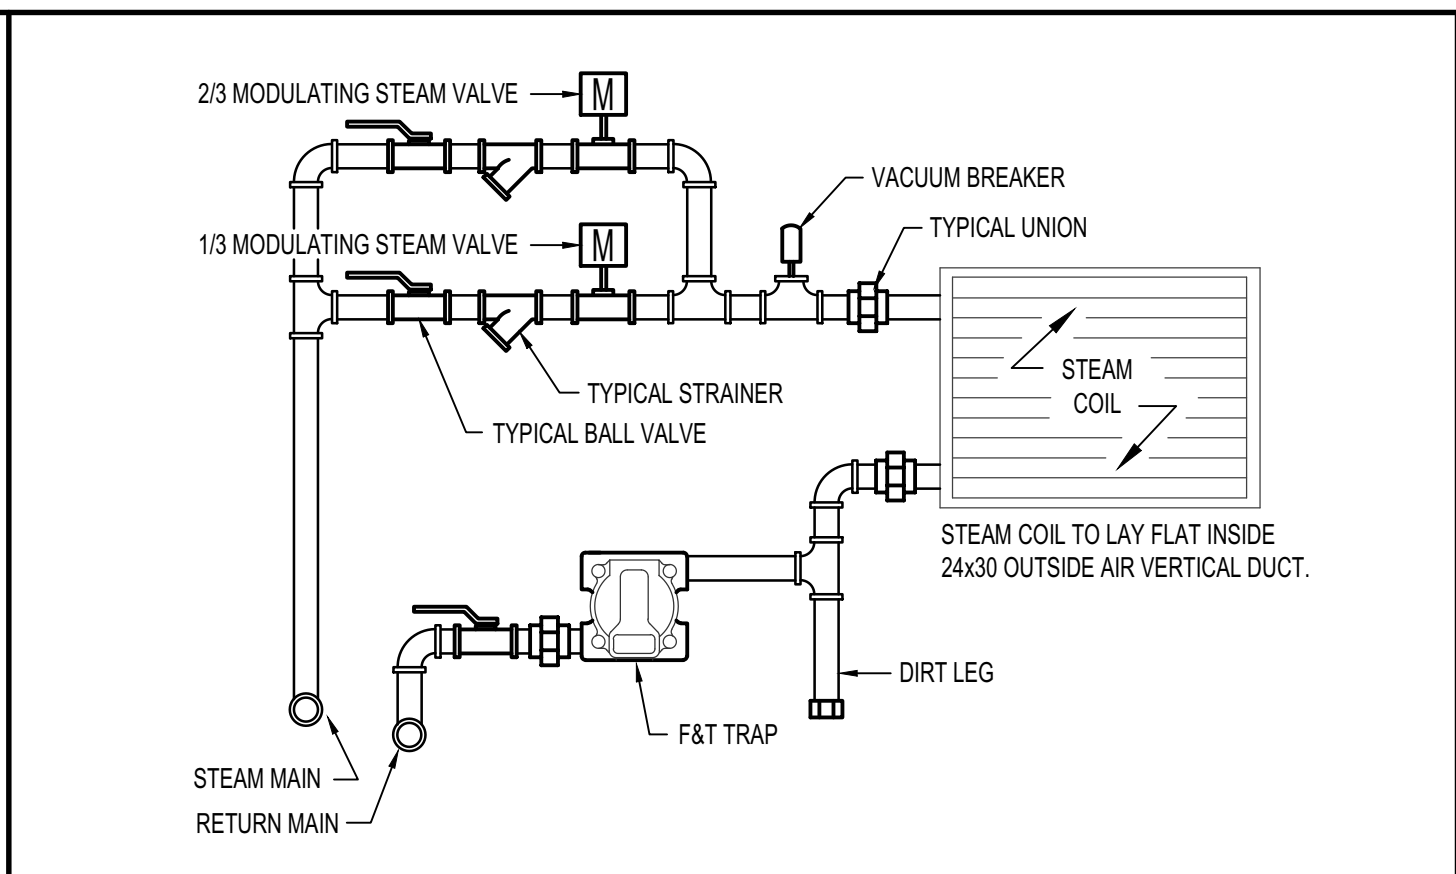


C | STEAM COIL PIPING DIAGRAM NO SCALE

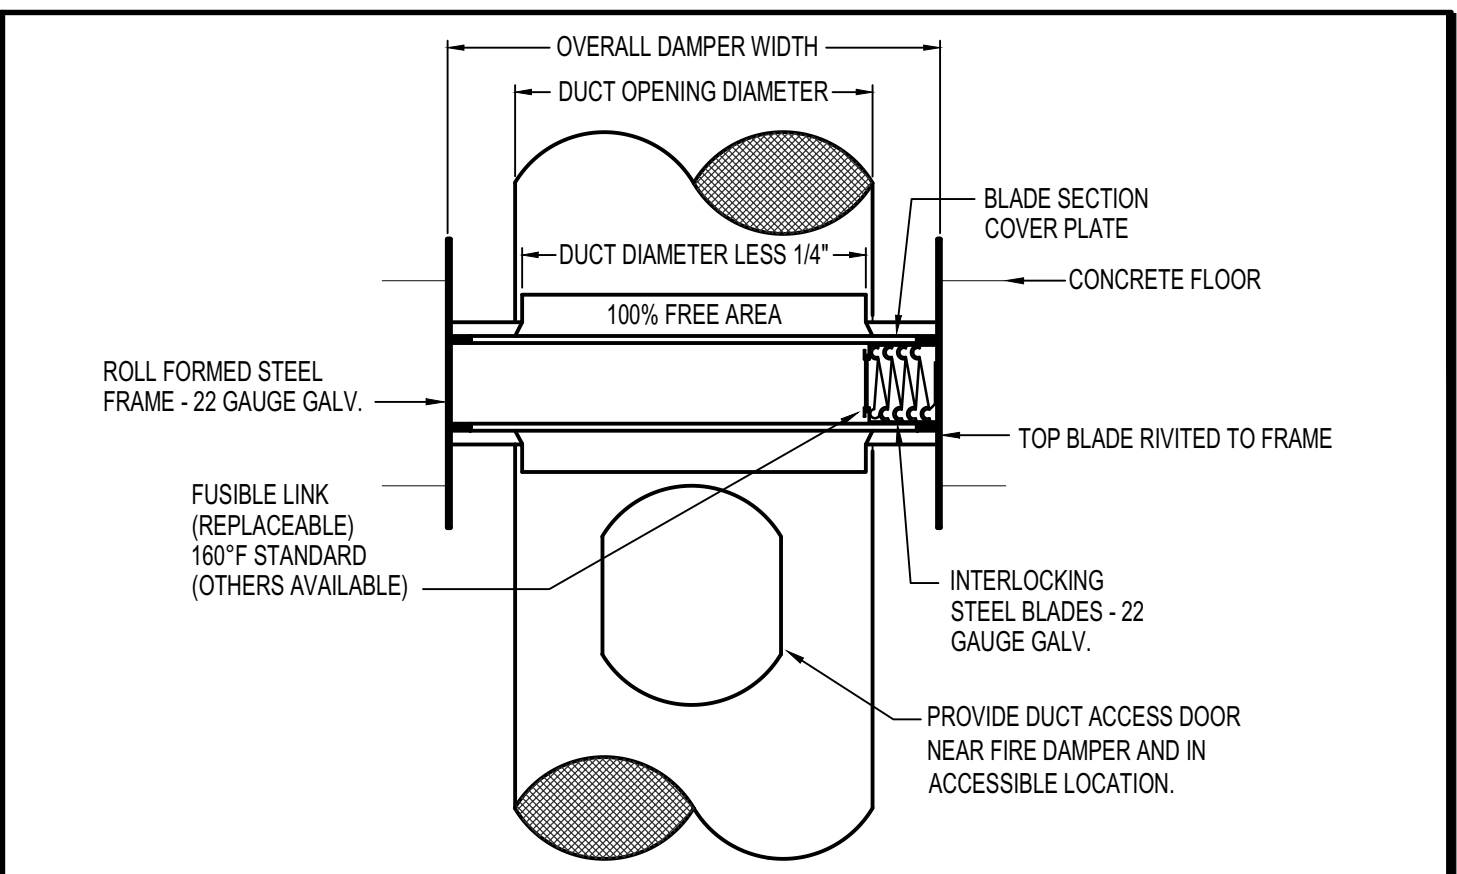


D | FIRE DAMPER DETAIL THRU FLOOR NO SCALE

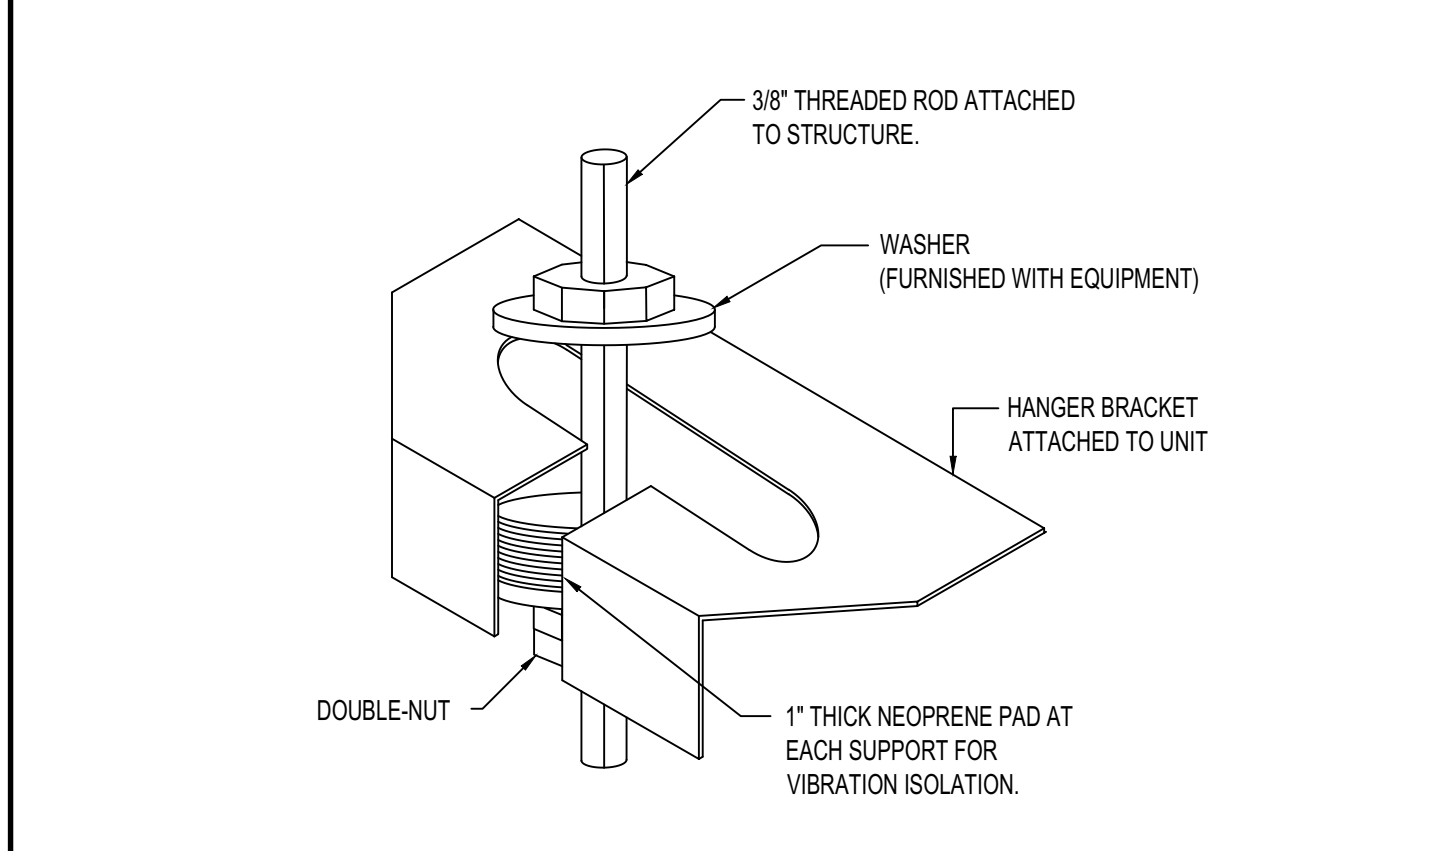


E | EQUIPMENT HANGER DETAIL NO SCALE

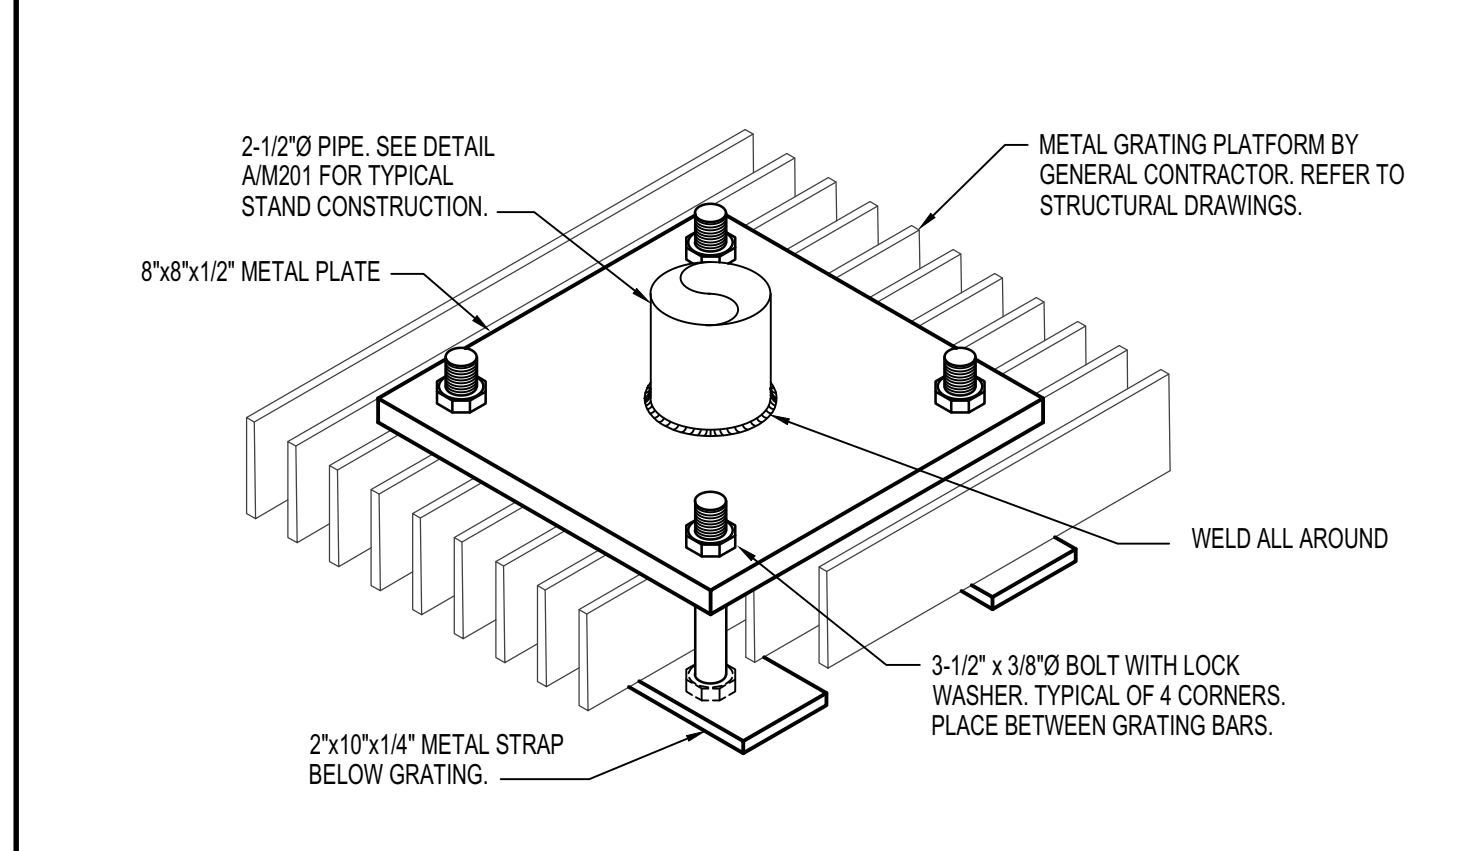


F | TANK STAND ANCHOR DETAIL NO SCALE

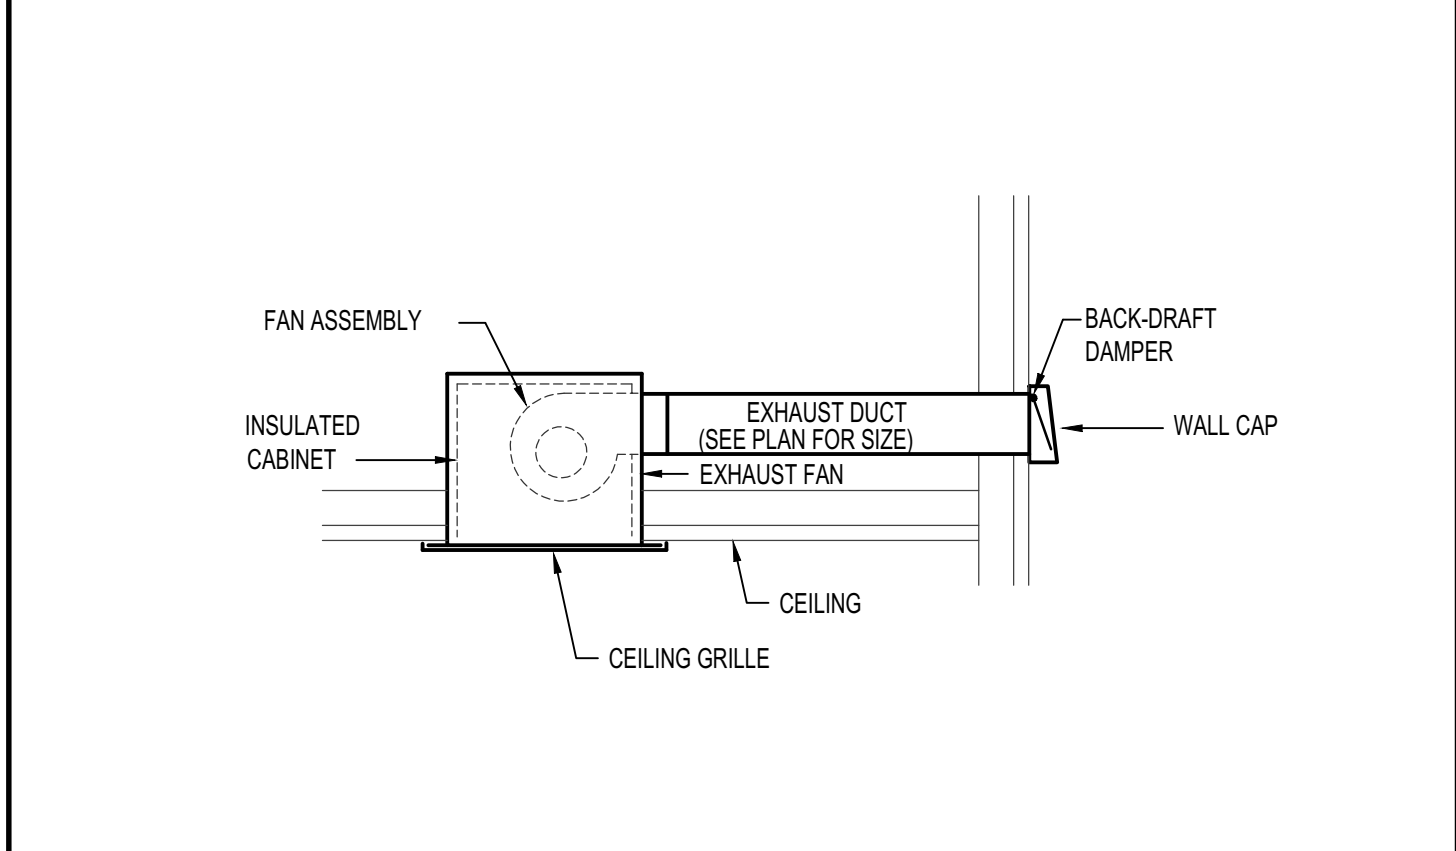


G | EXHAUST FAN INSTALLATION DETAIL NO SCALE

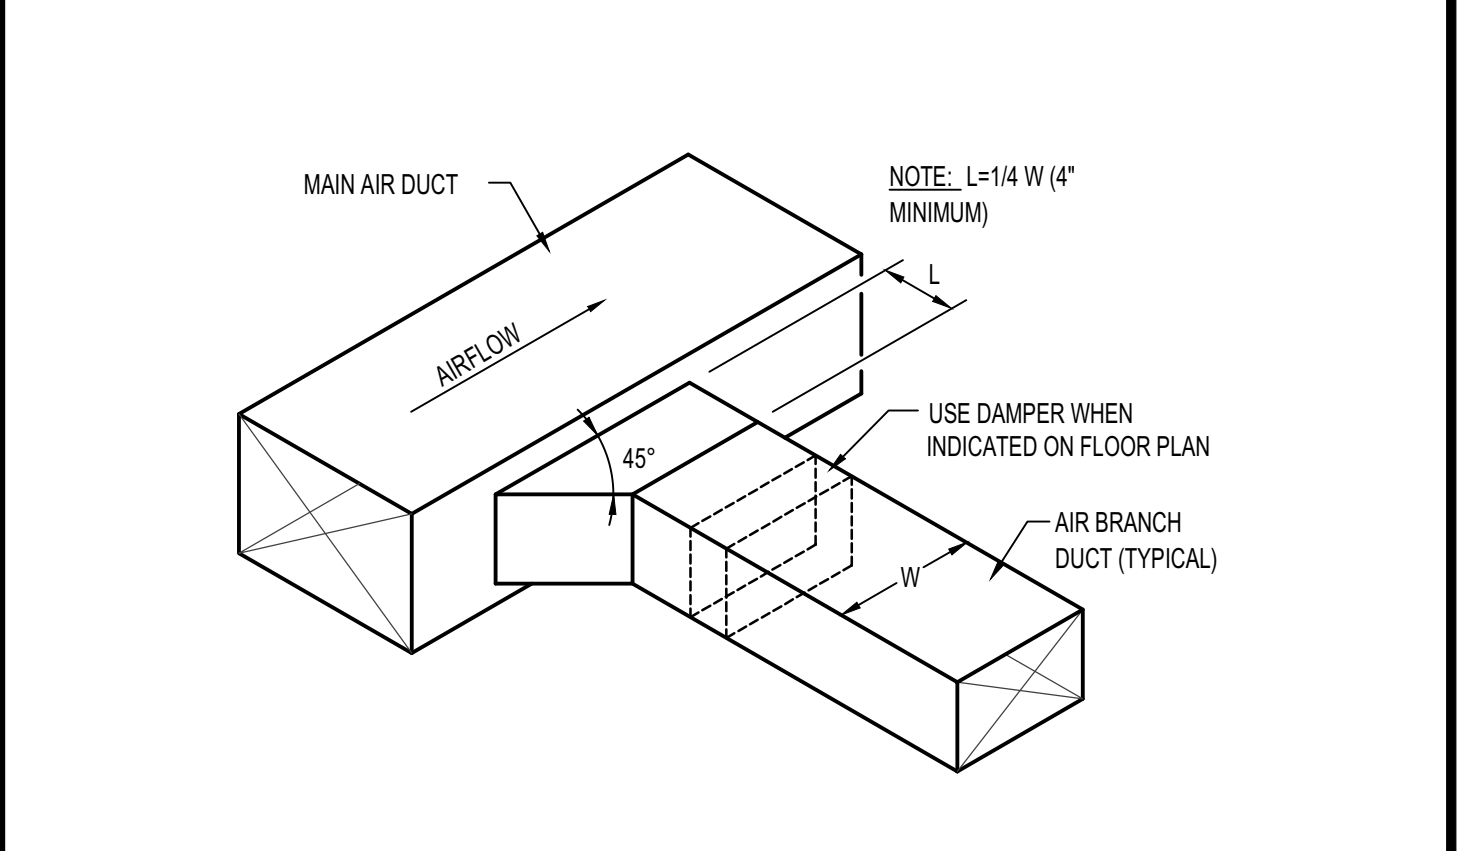


H | RECTANGULAR DUCT CONNECTION NO SCALE

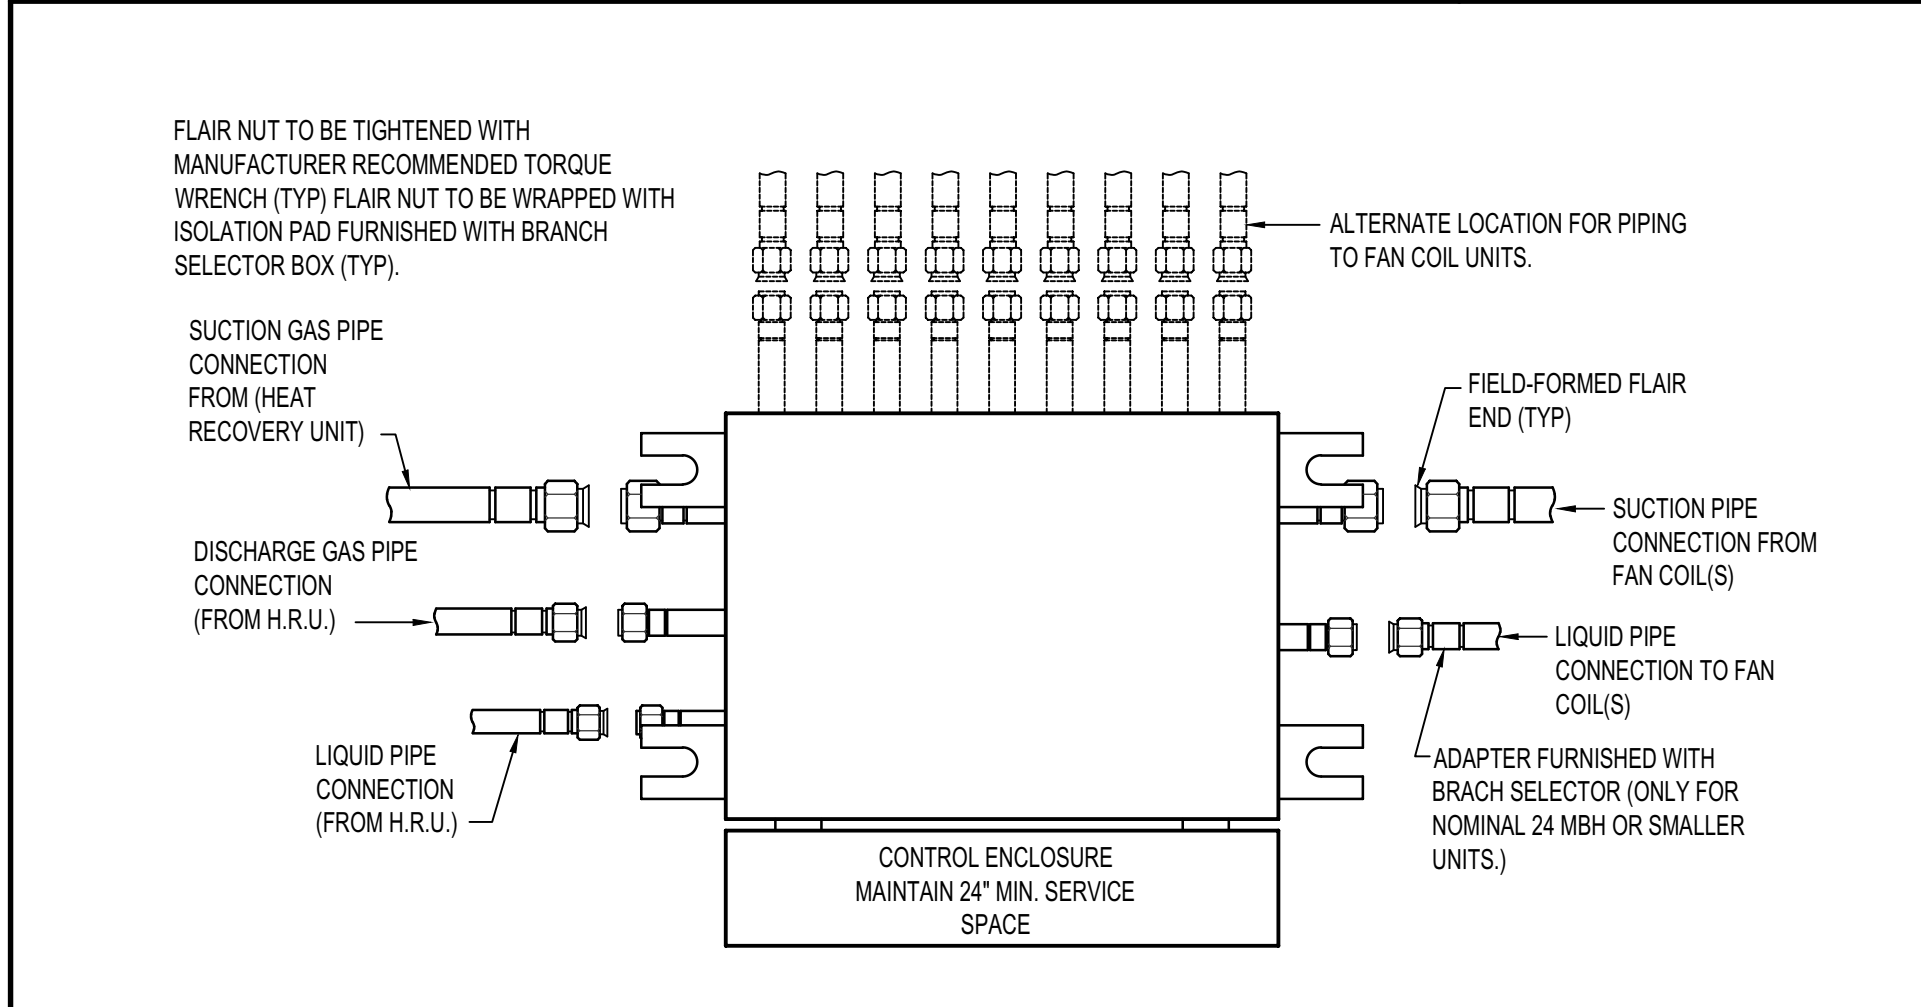


J | BRANCH SELECTOR BOX DETAIL NO SCALE

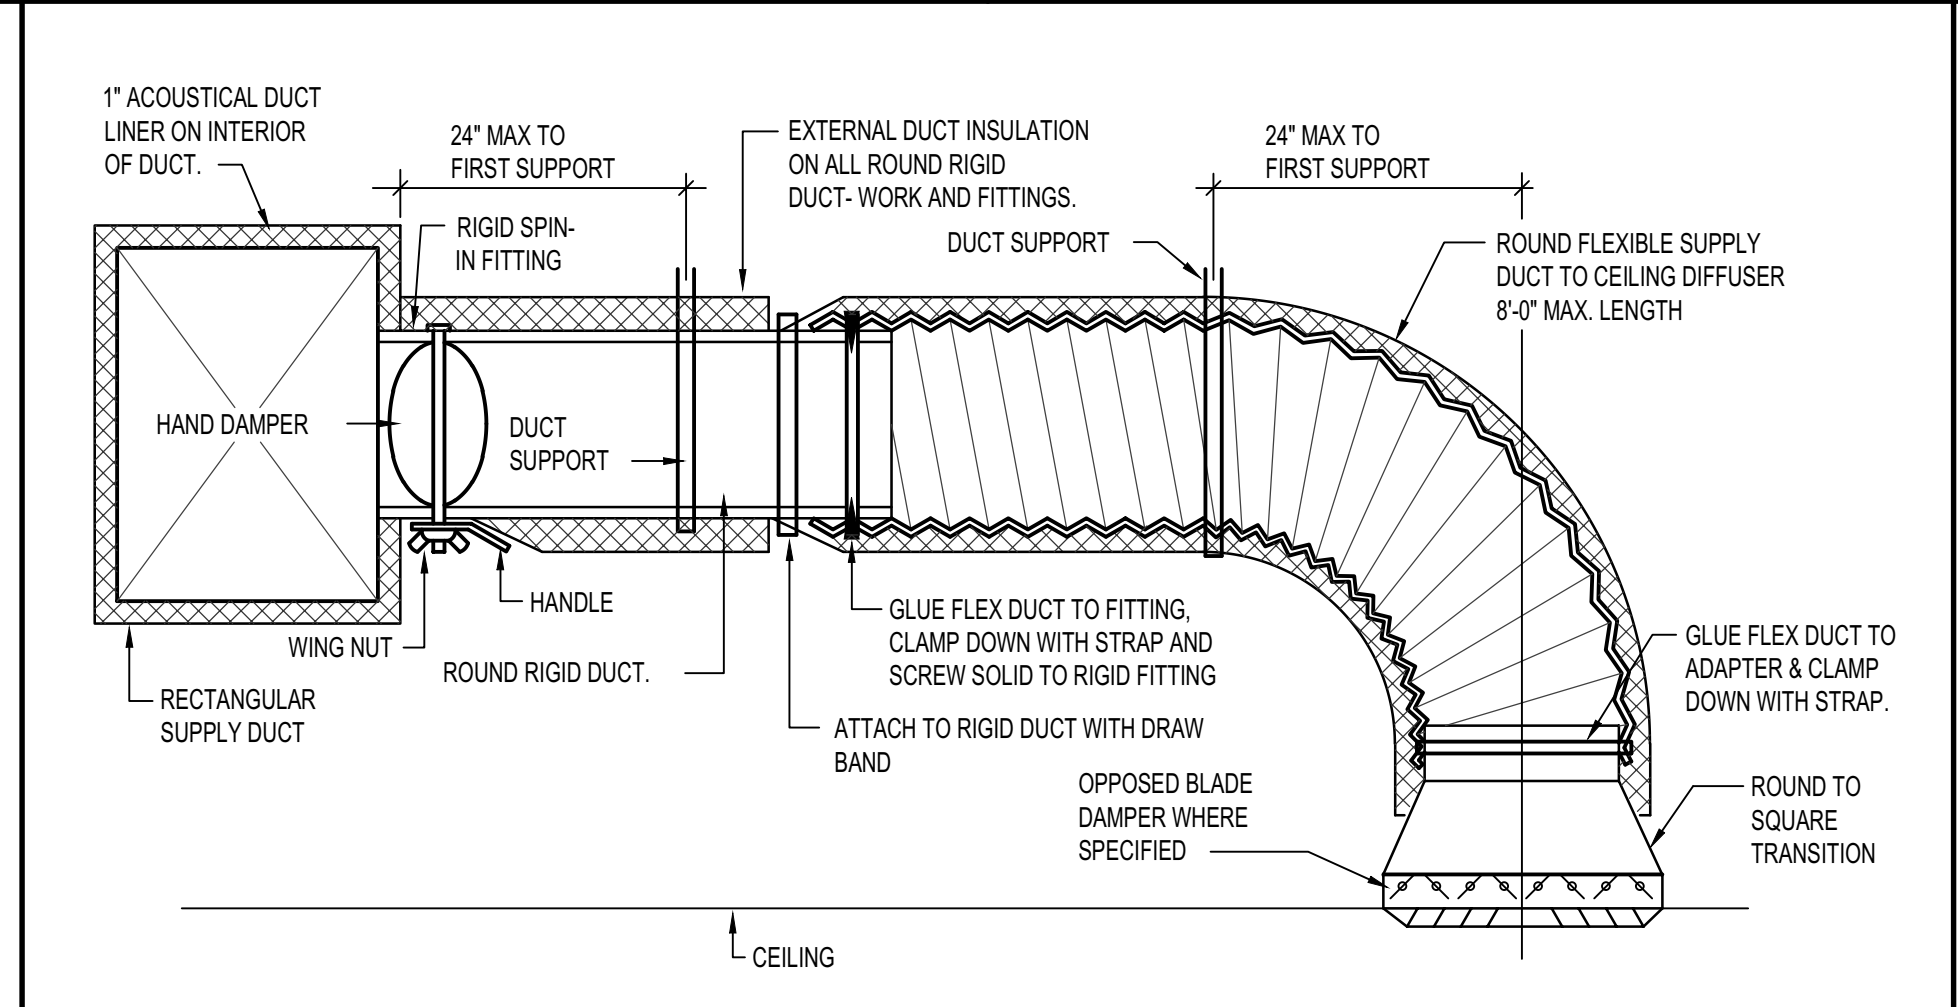


K | DIFFUSER INSTALLATION DETAIL NO SCALE

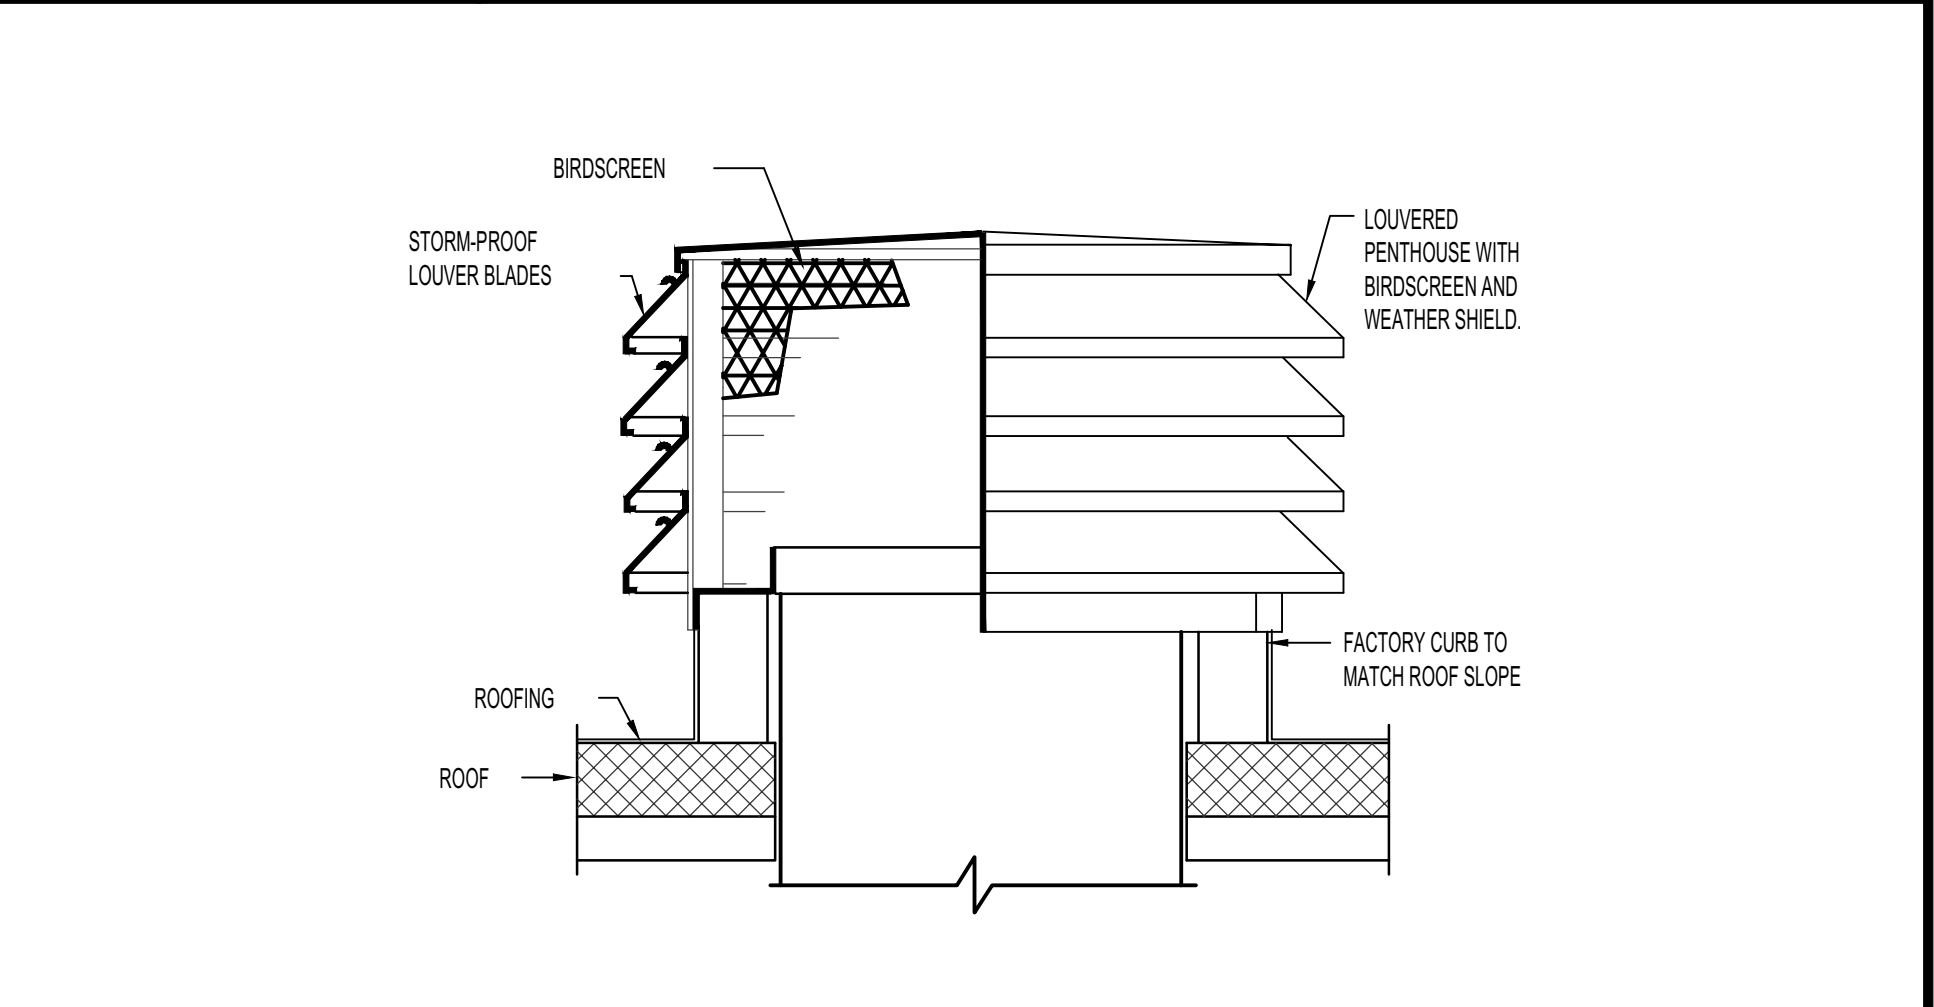

M | PENTHOUSE DETAIL NO SCALE

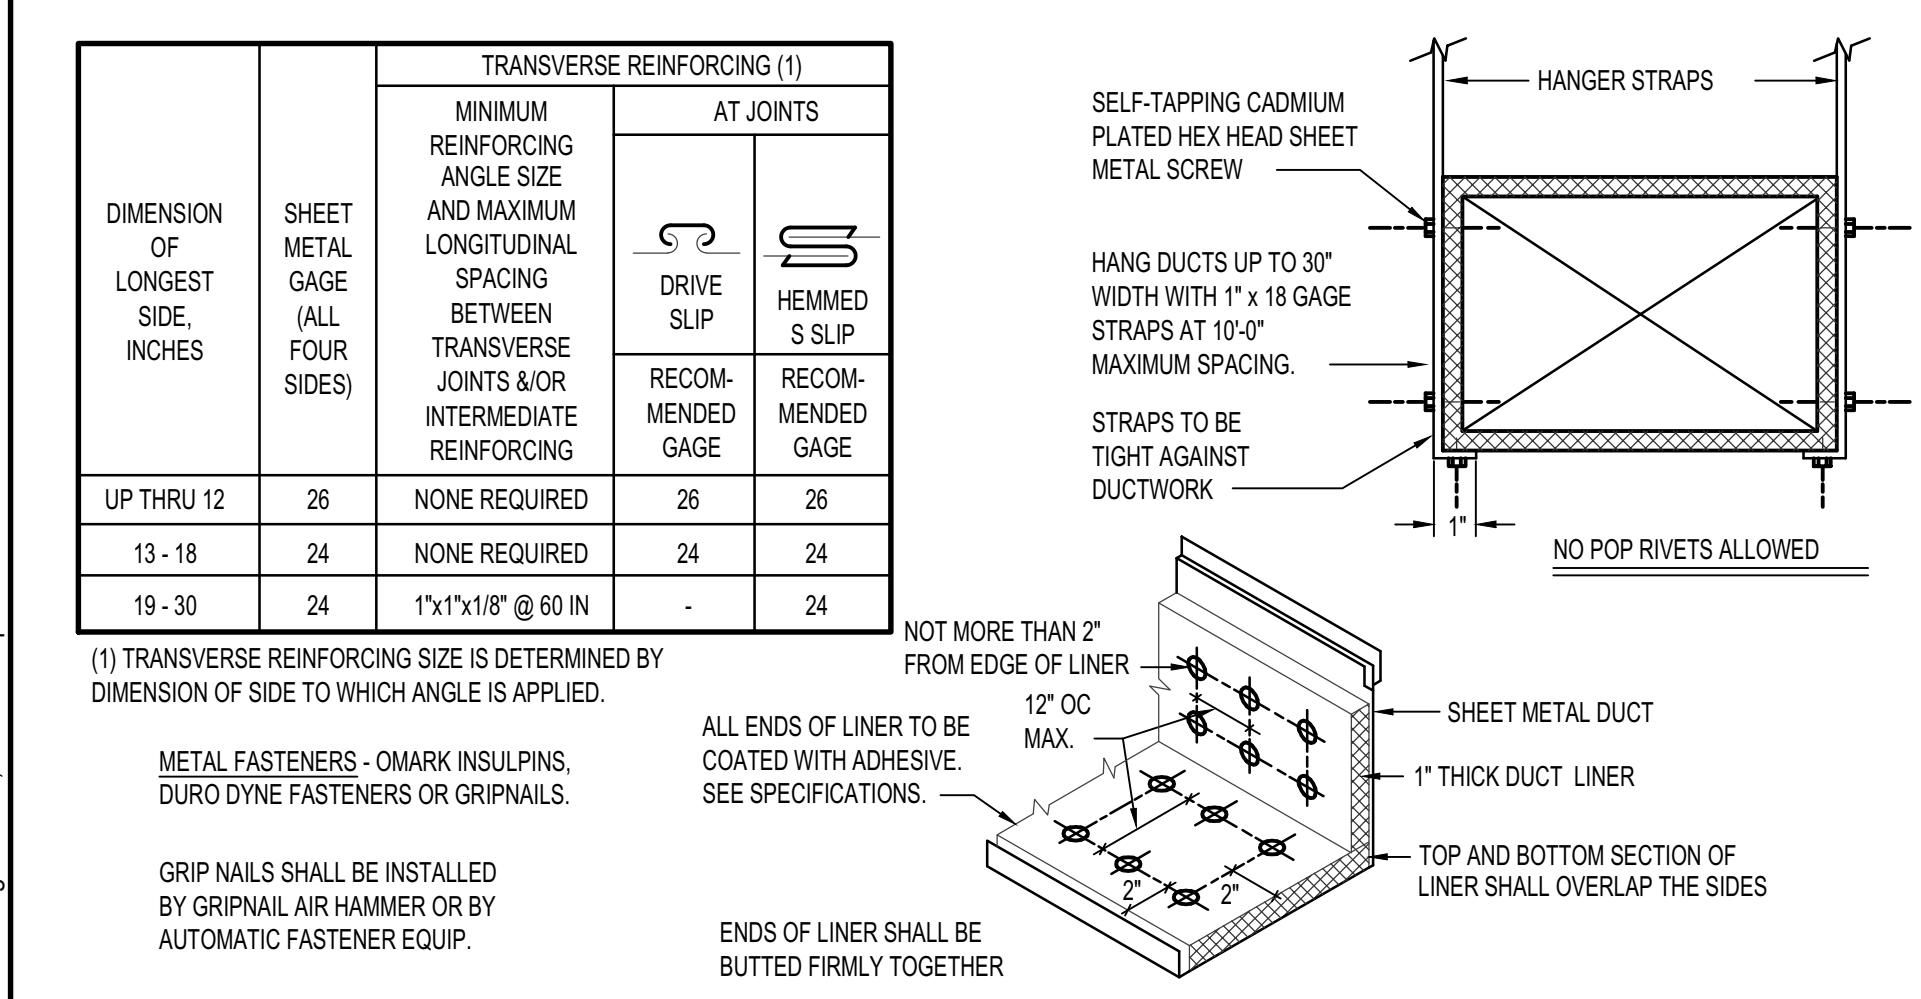

N | DUCT CONSTRUCTION AND HANGER DETAILS NO SCALE

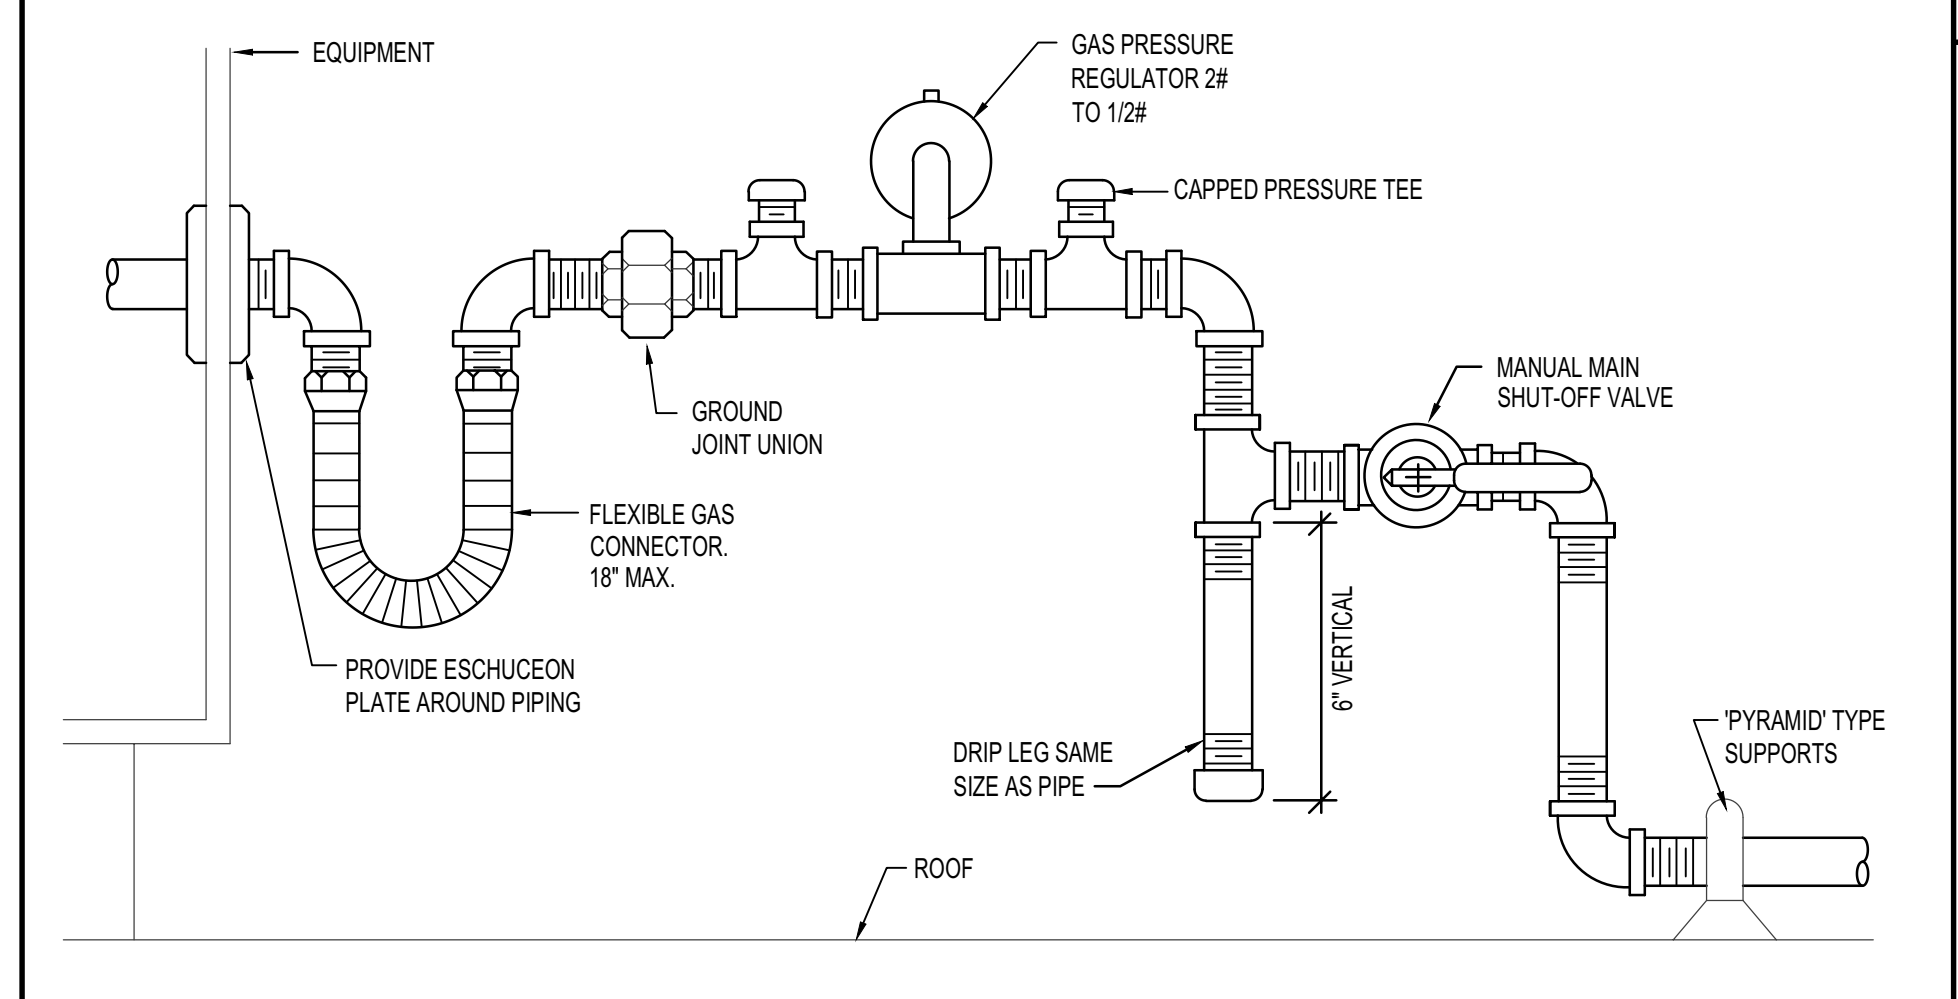

O | GAS LINE CONNECTION DETAIL NO SCALE

ORIGINAL DRAWING SIGNED BY: DWAYNE C. SUDWEEKS
 DATE ORIGINAL SIGNED: Feb 16, 2021
 ORIGINAL ON FILE AT ENGINEERED SYSTEMS ASSOCIATES
 1355 EAST CENTER, POCATELLO, IDAHO 83201

Engineered Systems Associates
 1355 EAST CENTER
 POCATELLO, IDAHO 83201
 PHONE: (208) 233-0501
 FAX: (208) 233-0529
 EMAIL: esa@engsystems.com
 ESA JOB NUMBER: 18050

PROFESSIONAL ENGINEER
 REGISTERED
 DWAYNE C. SUDWEEKS
 5762
 FEB 16 2021
 STATE OF IDAHO

BLD2009-00063
 REVIEWED FOR CODE COMPLIANCE
 This approval shall not be construed to be an approval of any violation of, or variance from, Idaho's adopted codes, standards, laws or rules applicable to this project.
 SEPARATE BUILDING PERMIT REQUIRED FOR CONSTRUCTION

CONTRACTOR SHALL VERIFY ALL DIMENSIONS & CONDITIONS SHOWN OR IMPLIED
 DRAWING SCALE APPLIES TO 22" X 34" SHEET SIZE
 REVISION: DATE

DRAWN BY: M. JENSEN
 CHECKED BY: D. SUDWEEKS
 JOB NUMBER: 18461
 PROJECT DATE: FEBRUARY 2021
 SHEET OF

18050-M301.dwg Feb 16, 2021 - 4:00pm

Myers Anderson
 Architecture
 Interior Design
 Landscape Architecture
 122 South Main Street • Pocatello, Idaho 83204 • Tel. (208) 232-3741 • Fax (208) 232-3782
 927 Main Street, Suite 300 • Evanston, Wyoming 82930 • Tel. (307) 789-0754

PROJECT:
**REED GYM HVAC UPGRADE
 IDAHO STATE UNIVERSITY
 DPW # 19227**
 POCATELLO, IDAHO

SHEET TITLE:
MECHANICAL SCHEDULES