


2/9/2019 9:25:30 AM F:\18\18070 Jefferson Co. Elem (Rigby)\18070-PO.5.dwg

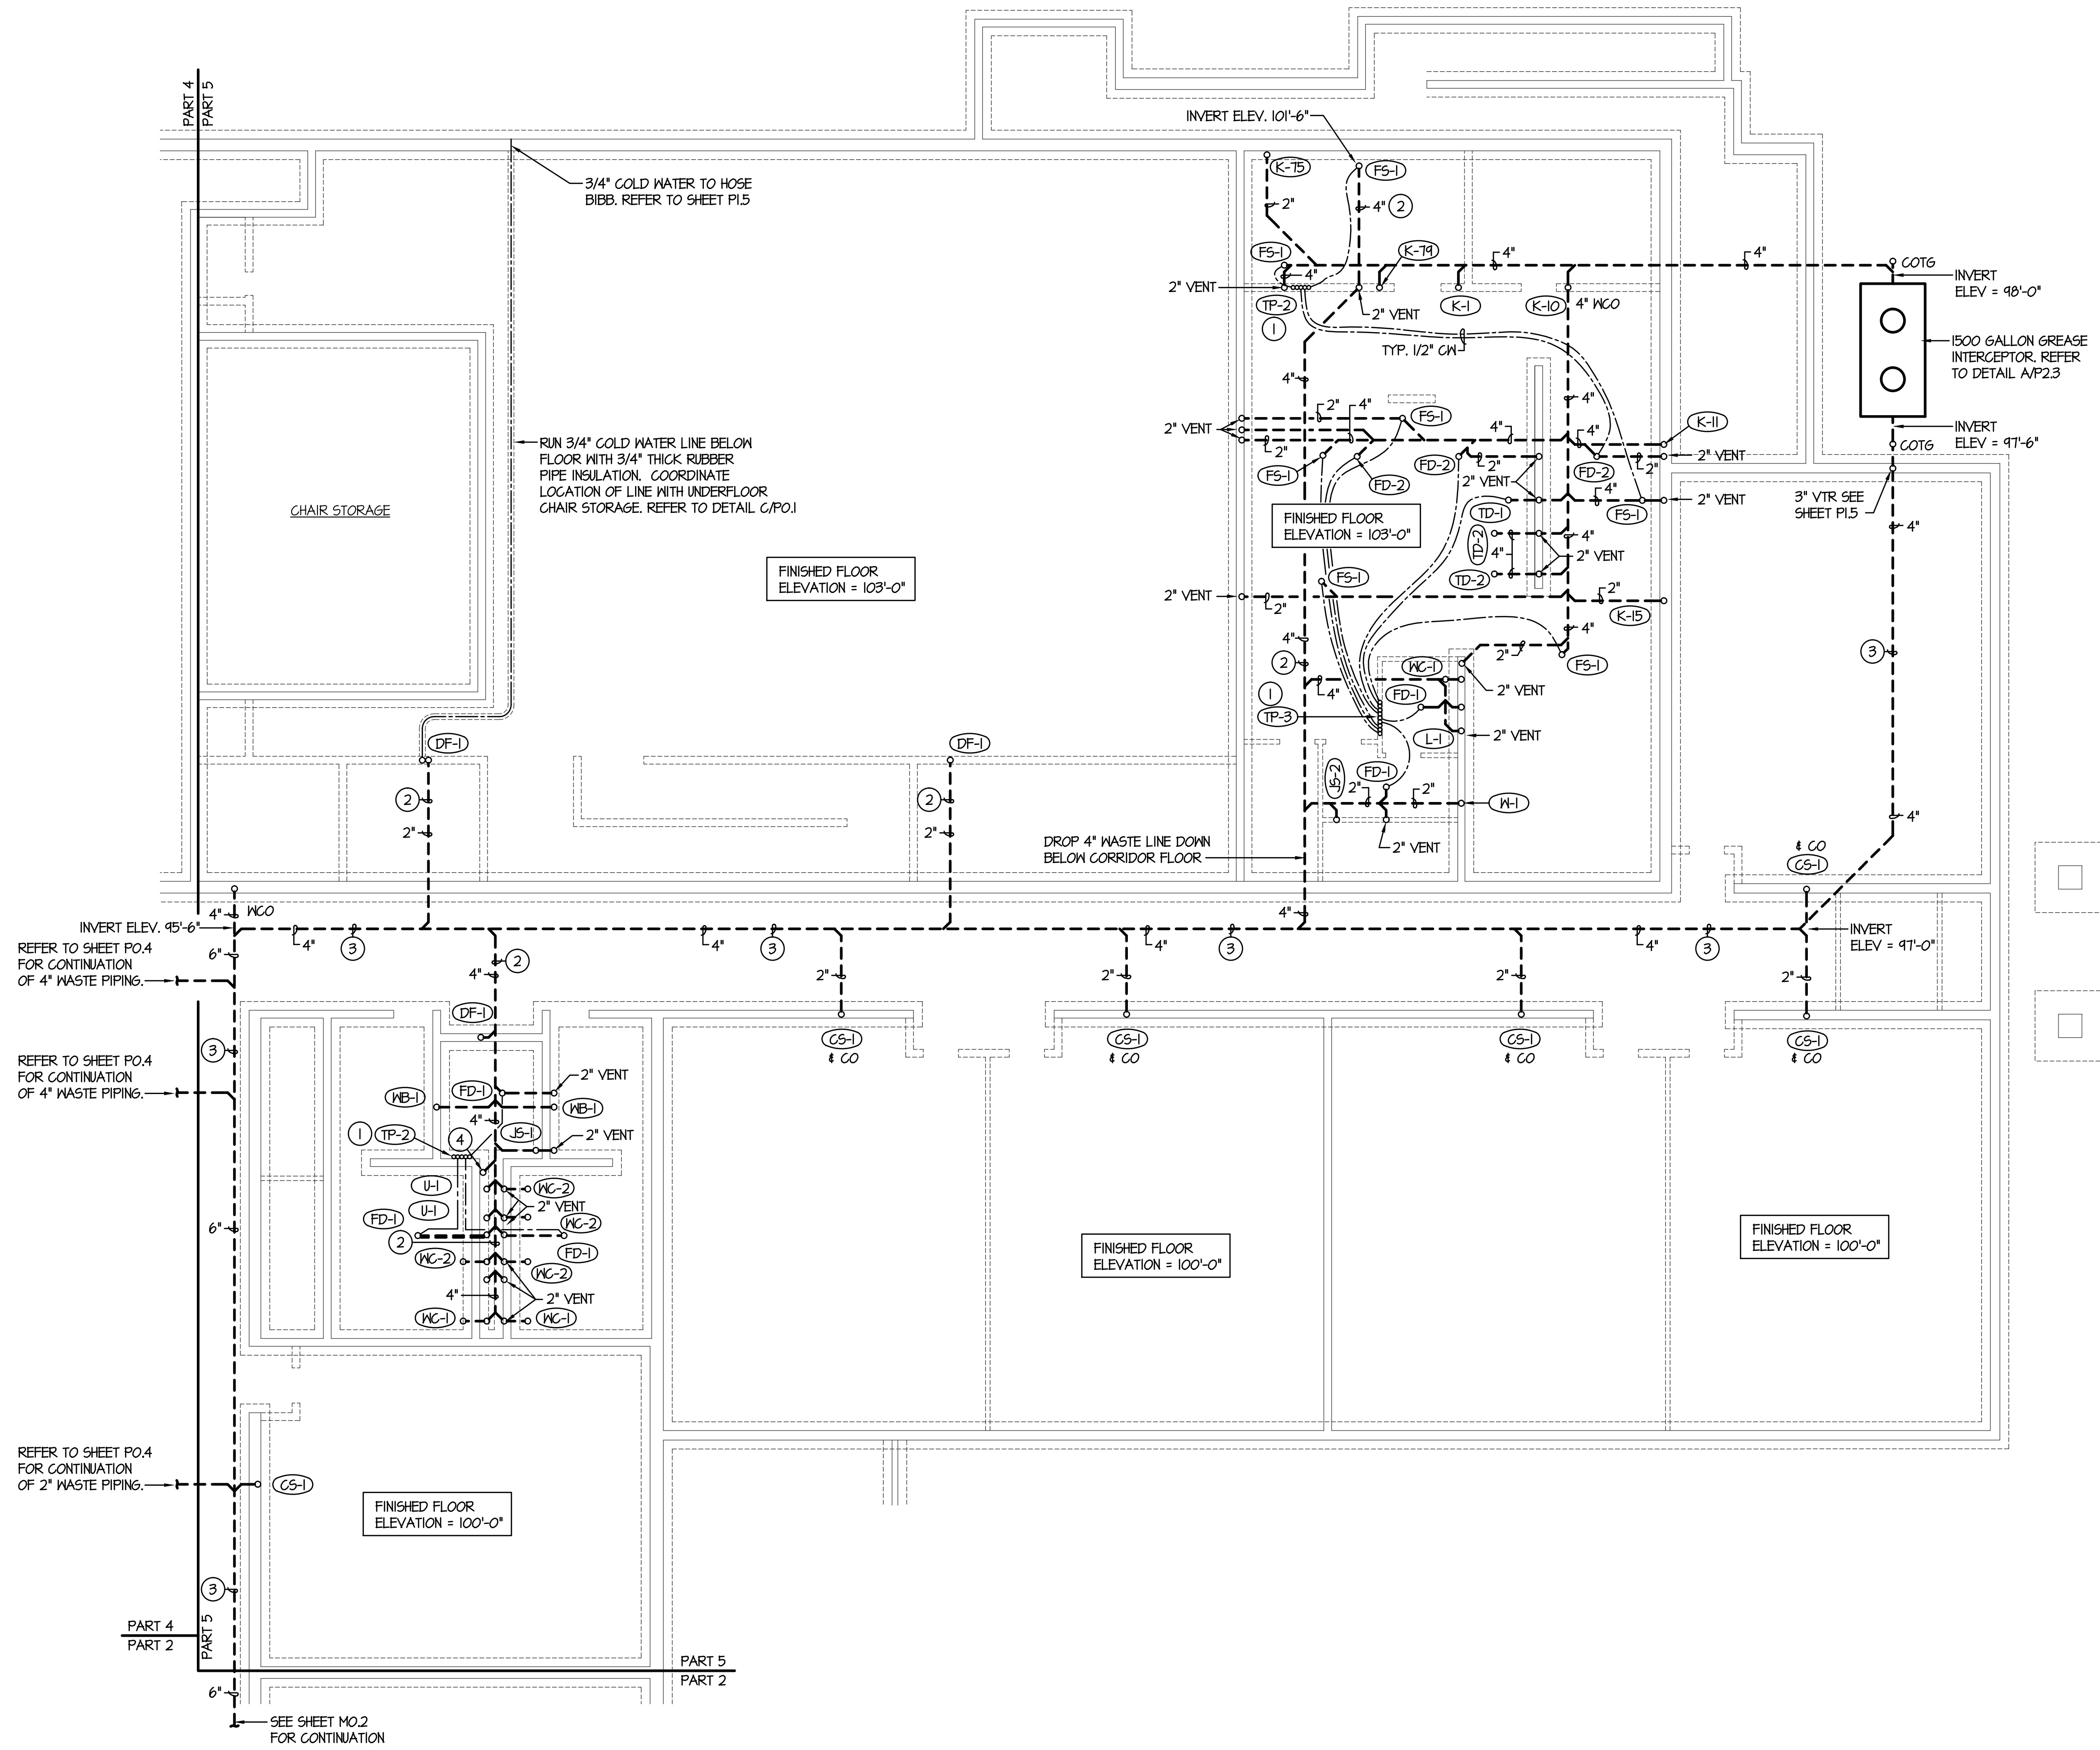


- PLAN NOTES:**
- TRAP PRIMER TO BE MOUNTED IN WALL ABOVE. DROP SEPARATE 1/2" COLD WATER LINE DOWN THRU FLOOR FOR EACH FLOOR DRAIN OR FLOOR SINK. UNDER FLOOR COLD WATER LINE TO BE PE'X TYPE PIPING WITH NO JOINTS BELOW SLAB. REFER TO DETAIL A/P0.2 FOR TYPICAL INSTALLATION.
 - UNLESS NOTED OTHERWISE ALL WASTE PIPING TO BE GRADED AT 1/4" PER FOOT SLOPE.
 - GRADE 4" WASTE LINE FROM GREASE INTERCEPTOR AND 6" WASTE LINE AT 1/8" PER FOOT SLOPE TO MAINTAIN INVERT ELEVATIONS AS NOTED.
 - 4" WASTE LINE DOWN FROM FLOOR SINKS LOCATED IN MEZZANINE FLOOR. REFER TO LARGE SCALE PLAN A/P2.2 FOR CONTINUATION OF PIPING ABOVE.

nbw architects p.a.
 ARCHITECTURE / PLANNING / INTERIORS
 SCOTT L. NELSON, A.I.A. KEVIN R. BODILY, A.I.A. JAMES H. WYATT, A.I.A.
 990 JOHN ADAMS PARKWAY P.O. BOX 2212 - IDAHO FALLS, IDAHO 83402-2212
 (208) 522-8779 (F) 208-522-8785 (W) nbwarchitects.com

NEW ELEMENTARY SCHOOL FOR
JEFFERSON COUNTY SCHOOL DISTRICT 251
 ELEMENTARY SCHOOL
 RIGBY, IDAHO
 FOUNDATION PLUMBING PLAN - PART 5

KEY PLAN

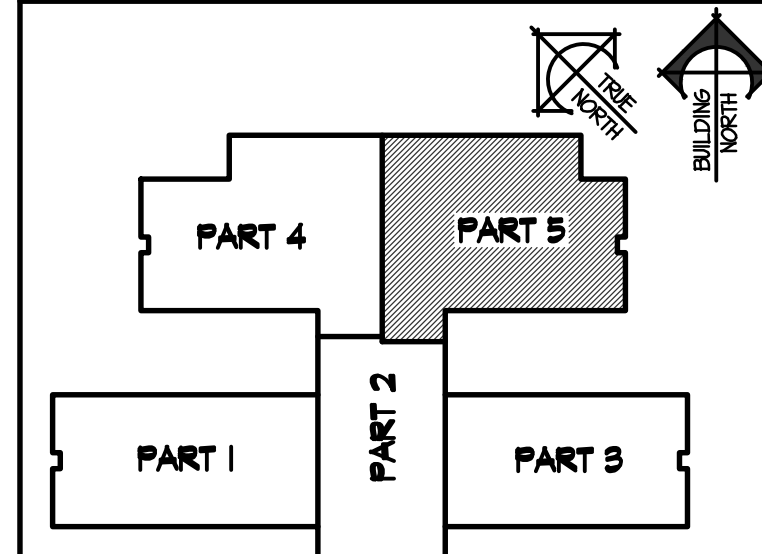

REVISIONS

NO.	DATE	DESCRIPTION
1	2-12-19	CONSTRUCTION SET

ORIGINAL DRAWING SIGNED BY: DWAYNE C. SUDWEEKS
 DATE ORIGINAL SIGNED: Feb 08, 2019
 ORIGINAL ON FILE AT ENGINEERED SYSTEMS ASSOCIATES
 1355 EAST CENTER, POCATELLO, IDAHO 83201

Engineered Systems Associates
 1355 EAST CENTER
 POCATELLO, IDAHO 83201
 PHONE: (208) 233-0501
 FAX: (208) 233-0529
 EMAIL: esa@engsystems.com
 ESA JOB NUMBER: 18070

FOUNDATION PLUMBING PLAN - PART 5
 SCALE: 1/8" = 1'-0"

PROJECT NO. 18012
 DATE: FEBRUARY 2019
 DRAWN BY: M. JENSEN
 CHECKED BY: D. SUDWEEKS
 DRAWING NO.: **PO.5**