



**LARGE SCALE MEN'S 112
PLUMBING PLAN**

SCALE: 1/4" = 1'-0"

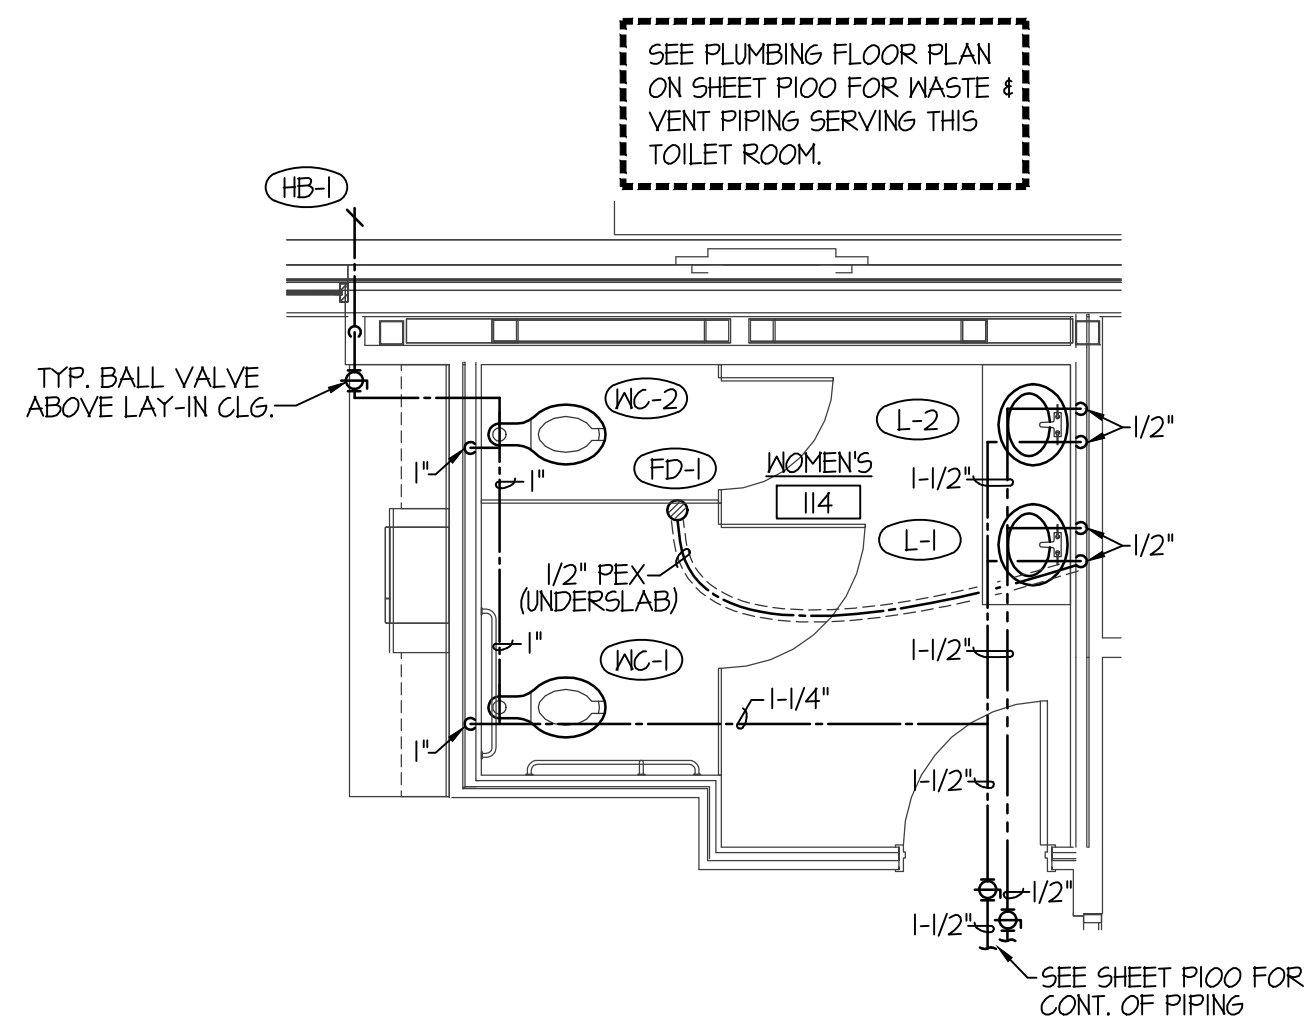


**LARGE SCALE WOMEN'S 114
PLUMBING PLAN**

SCALE: 1/4" = 1'-0"

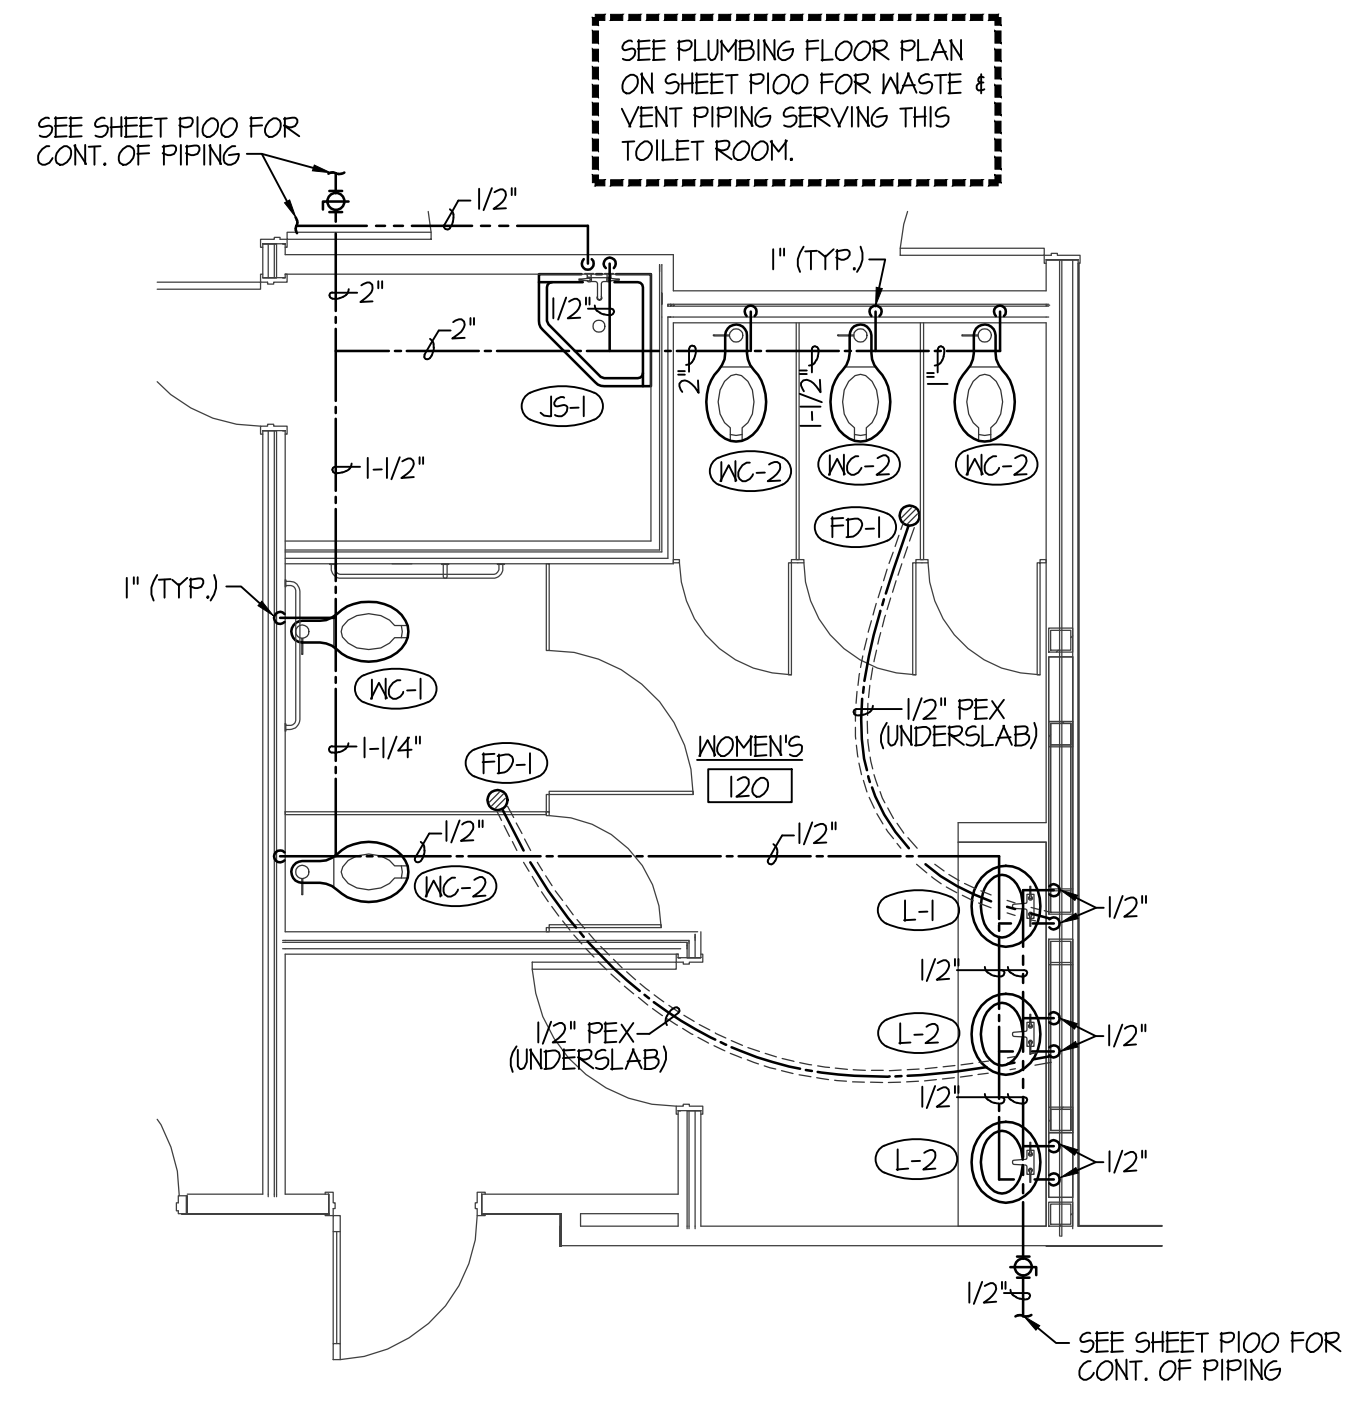


**LARGE SCALE WOMEN'S 120
PLUMBING PLAN**

SCALE: 1/4" = 1'-0"

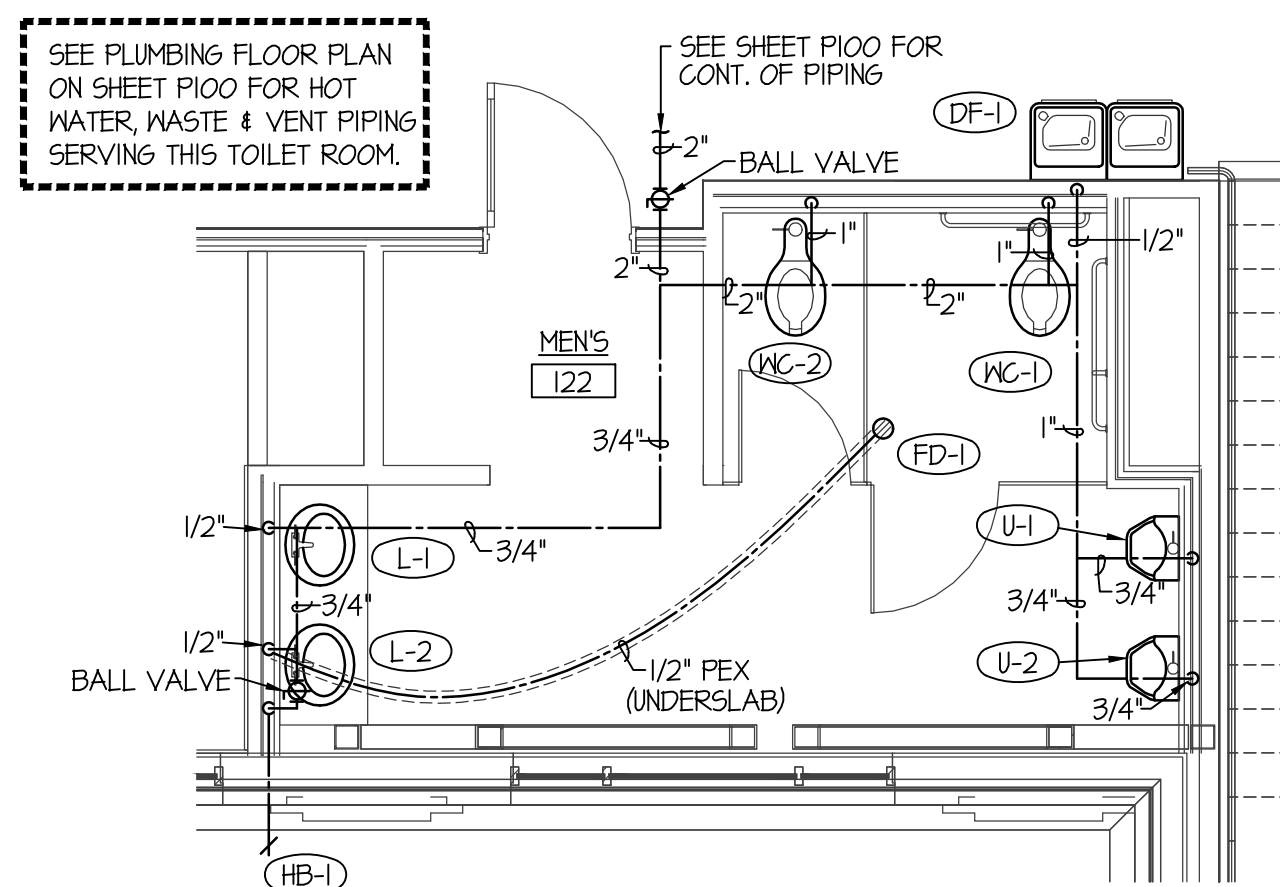



**LARGE SCALE MEN'S 122
PLUMBING PLAN**

SCALE: 1/4" = 1'-0"

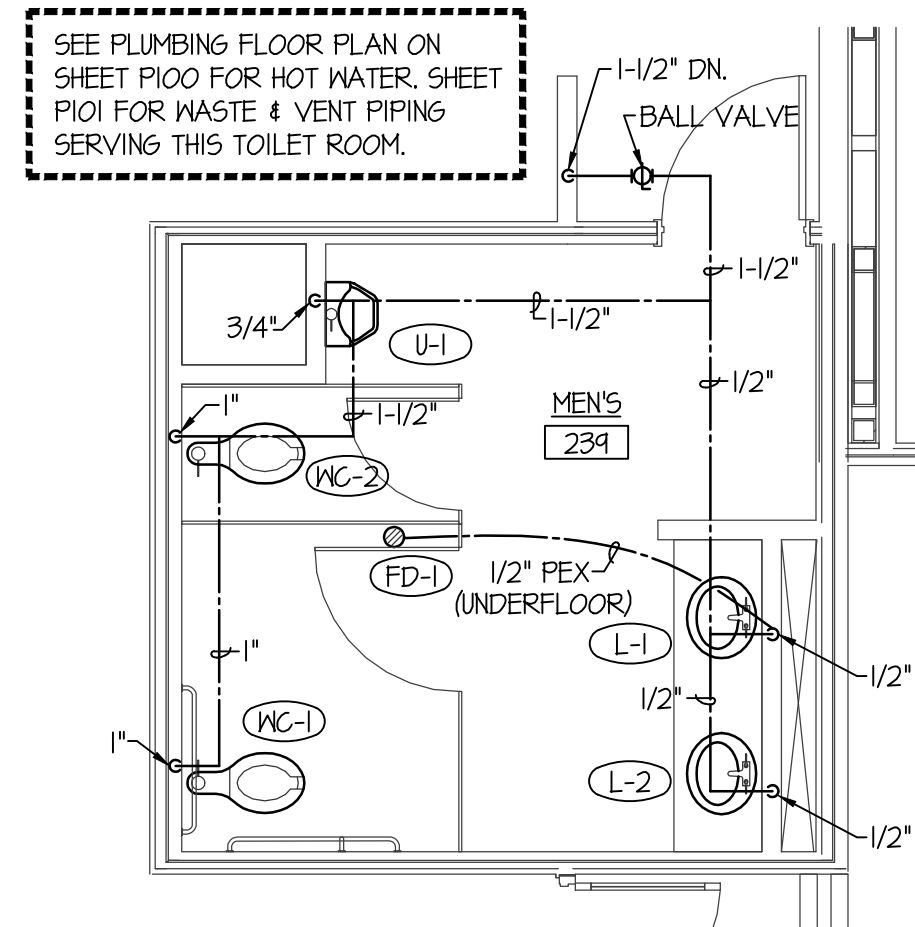


**LARGE SCALE MEN'S 239
PLUMBING PLAN**

SCALE: 1/4" = 1'-0"

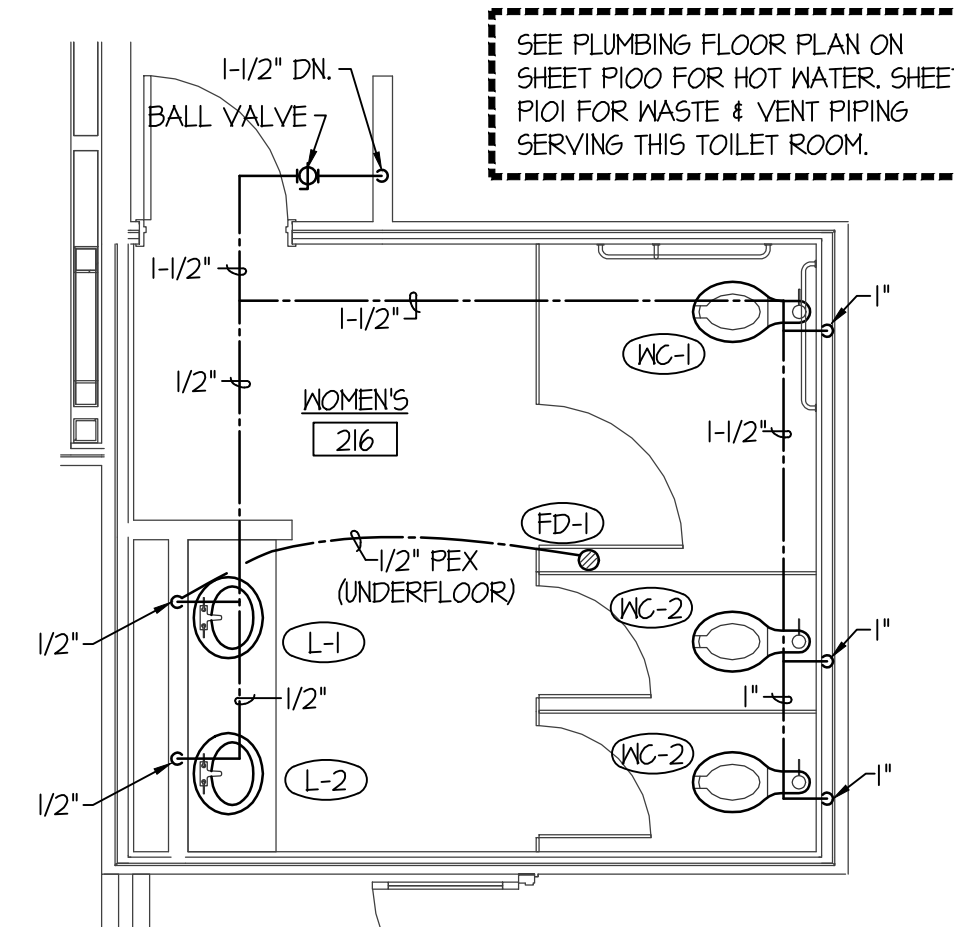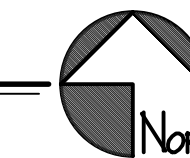

**LARGE SCALE WOMEN'S 216
PLUMBING PLAN**

SCALE: 1/4" = 1'-0"

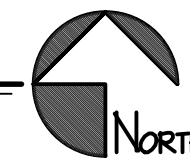

CONTRACTOR SHALL VERIFY ALL DIMENSIONS & CONDITIONS SHOWN OR IMPLIED


DRAWING SCALE APPLIES TO 22' X 34' SHEET SIZE

REVISION DATE

REVISION	DATE

DRAWN BY:	SR
CHECKED BY:	DCS
JOB NUMBER:	46548-13B
PROJECT DATE:	FEB. 2020
SHEET OF:	

ORIGINAL DRAWING SIGNED BY: DWAYNE C. SUDWEEKS
DATE ORIGINAL SIGNED: FEB. 14, 2020
ORIGINAL ON FILE AT ENGINEERED SYSTEMS ASSOCIATES
1355 EAST CENTER, POCATELLO, IDAHO 83201

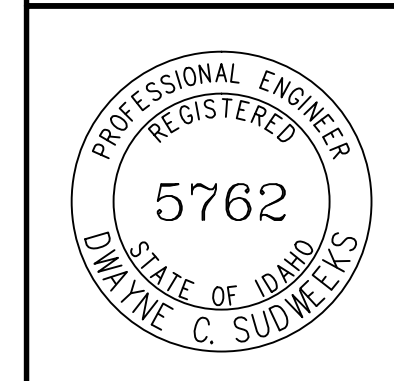

Engineered Systems Associates
1355 EAST CENTER
POCATELLO, IDAHO 83201
PHONE: (208) 233-0501
FAX: (208) 233-0529
EMAIL: eso@engsystems.com
ESA JOB NUMBER: 18080