




A ROUND DUCT ELBOW DETAILS NO SCALE

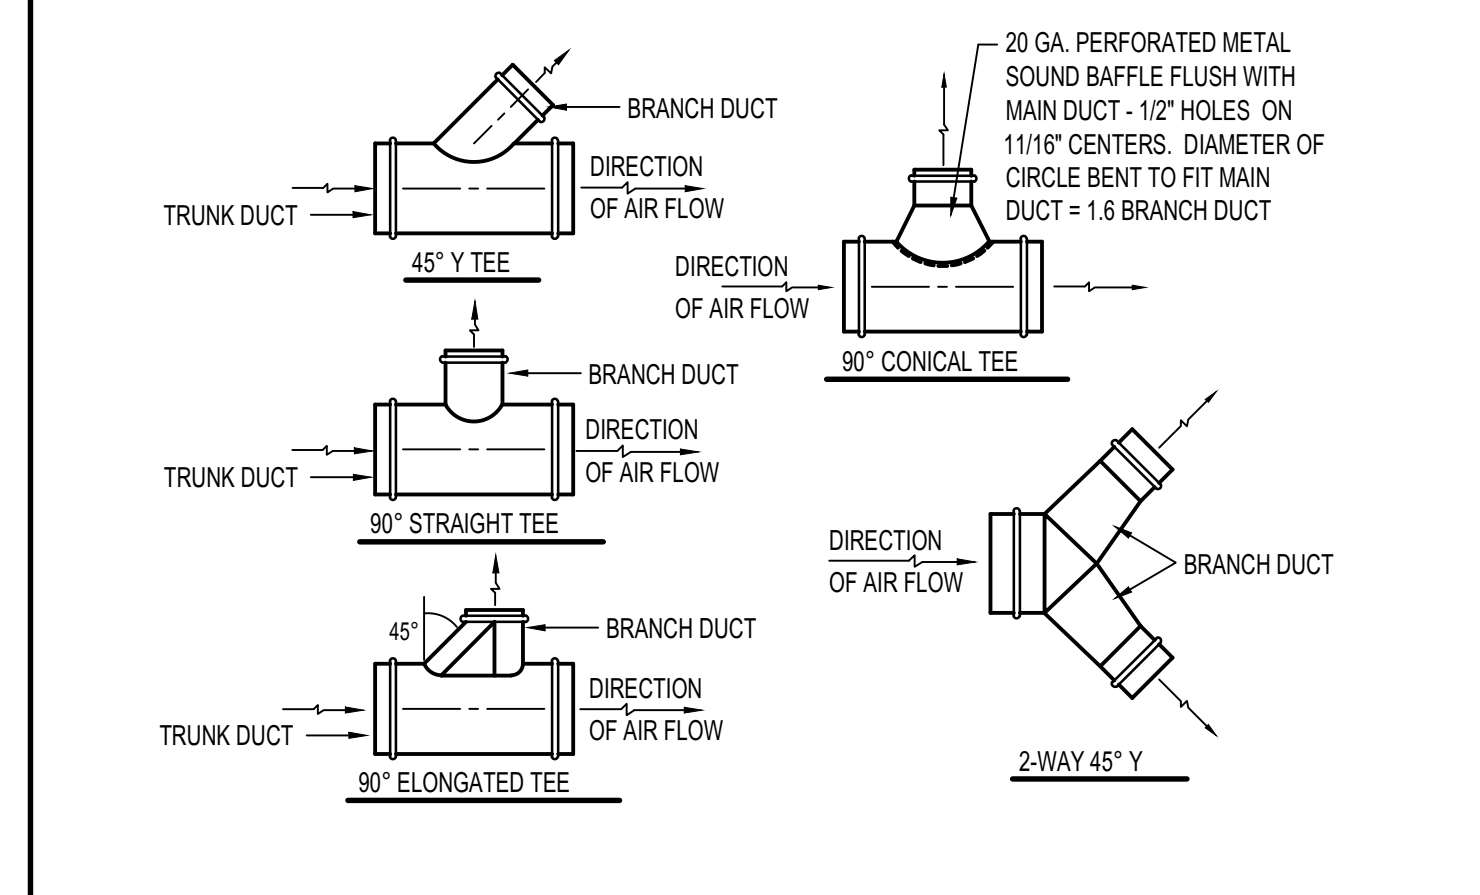


F ROUND DUCT FITTING DETAILS NO SCALE

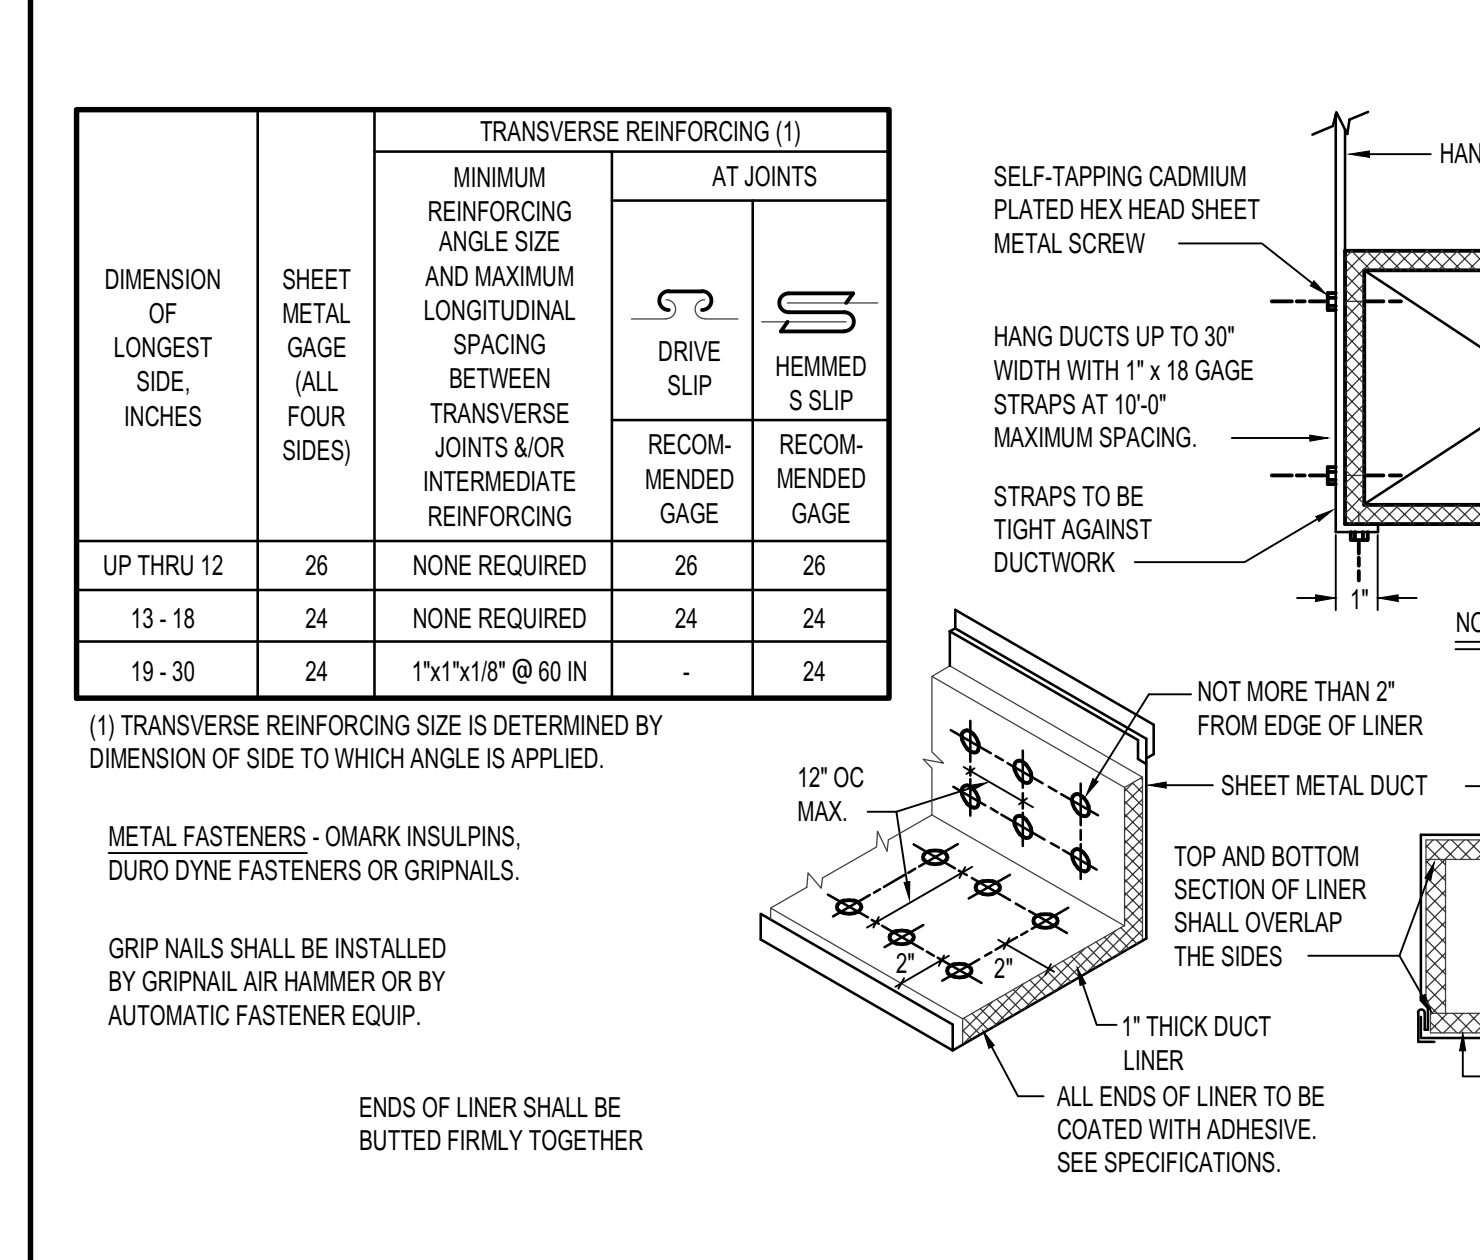


L DUCT CONSTRUCTION AND HANGER DETAILS NO SCALE

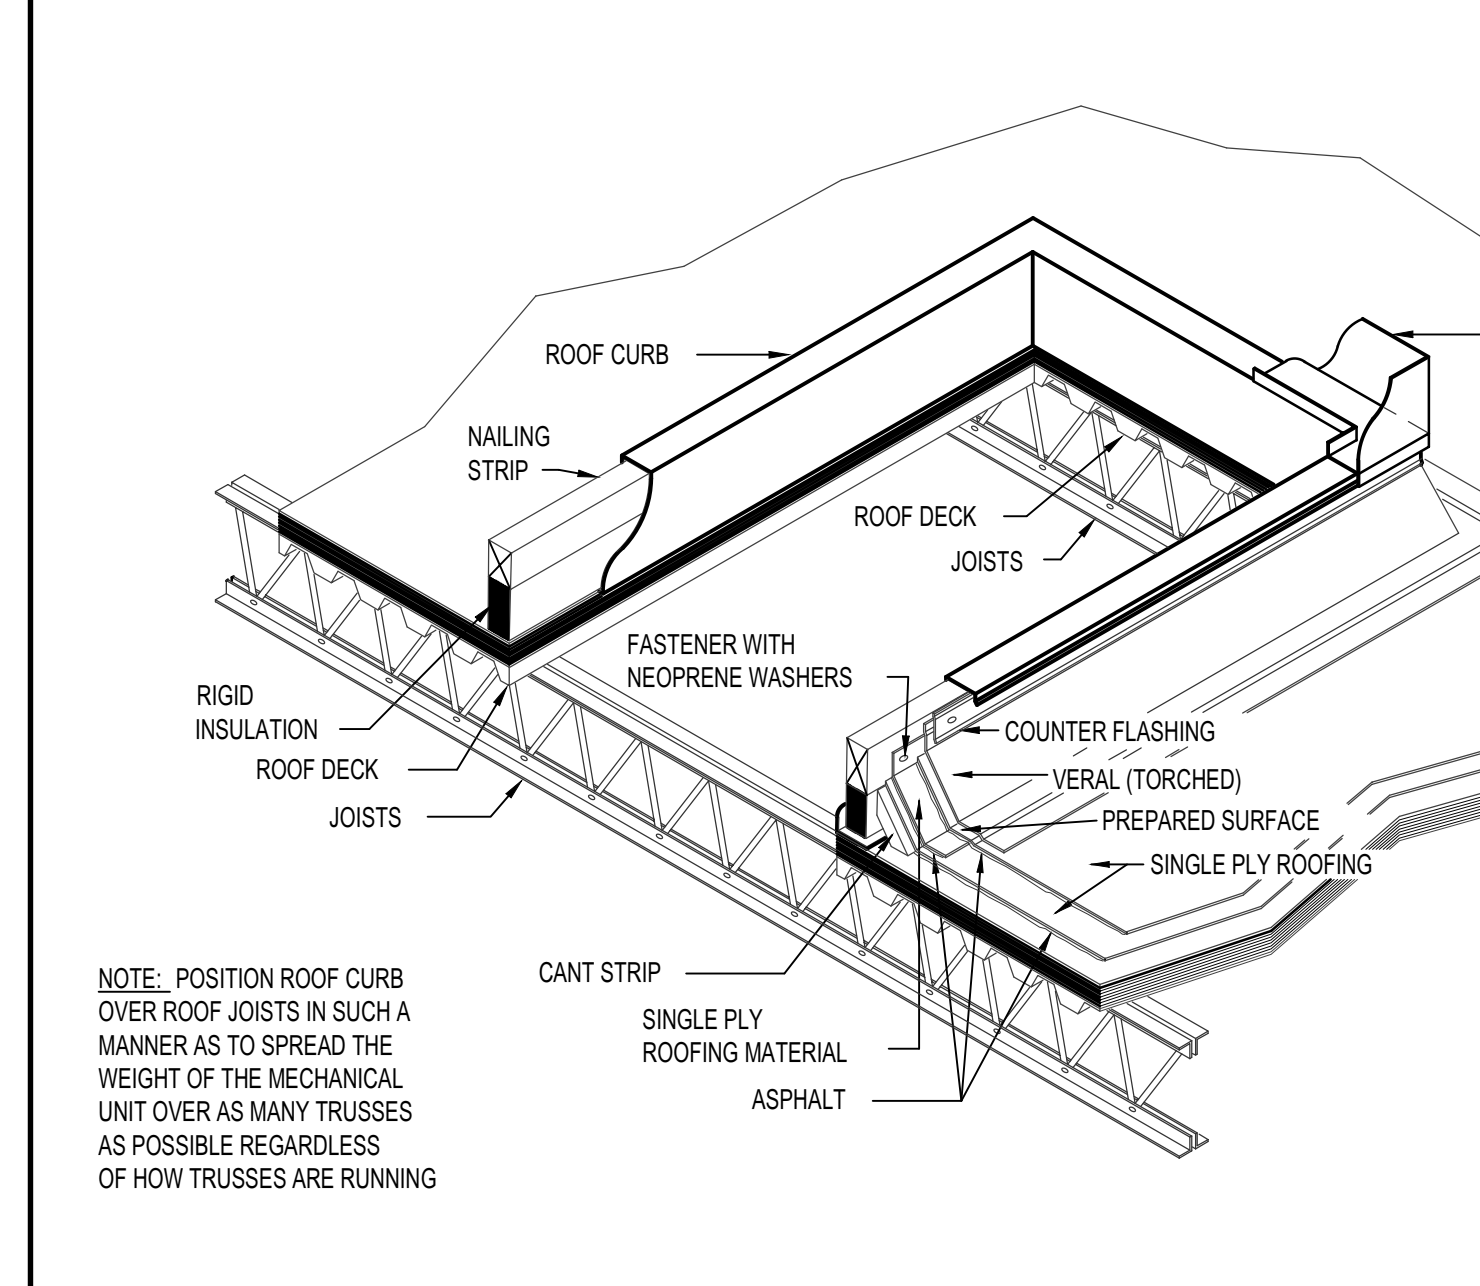


P TYPICAL ROOFTOP MOUNTING DETAIL NO SCALE

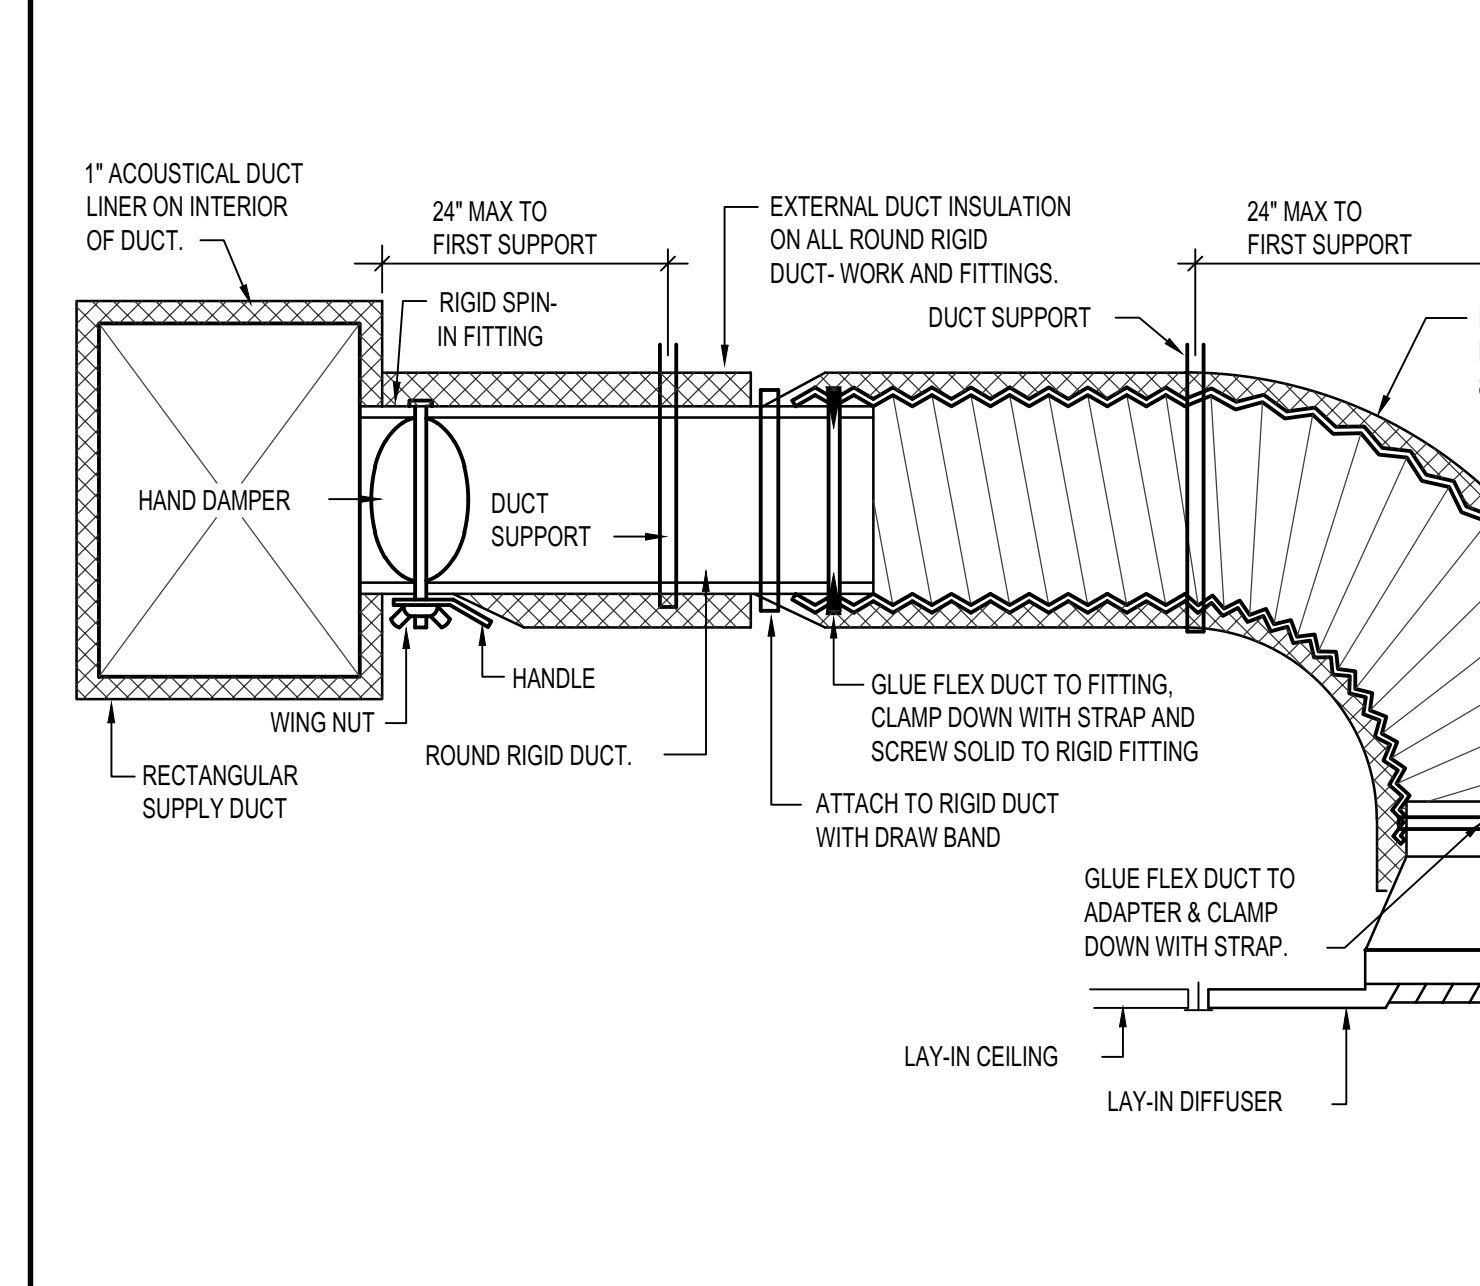


T CEILING DIFFUSER WITH FLEXIBLE DUCT DETAIL NO SCALE

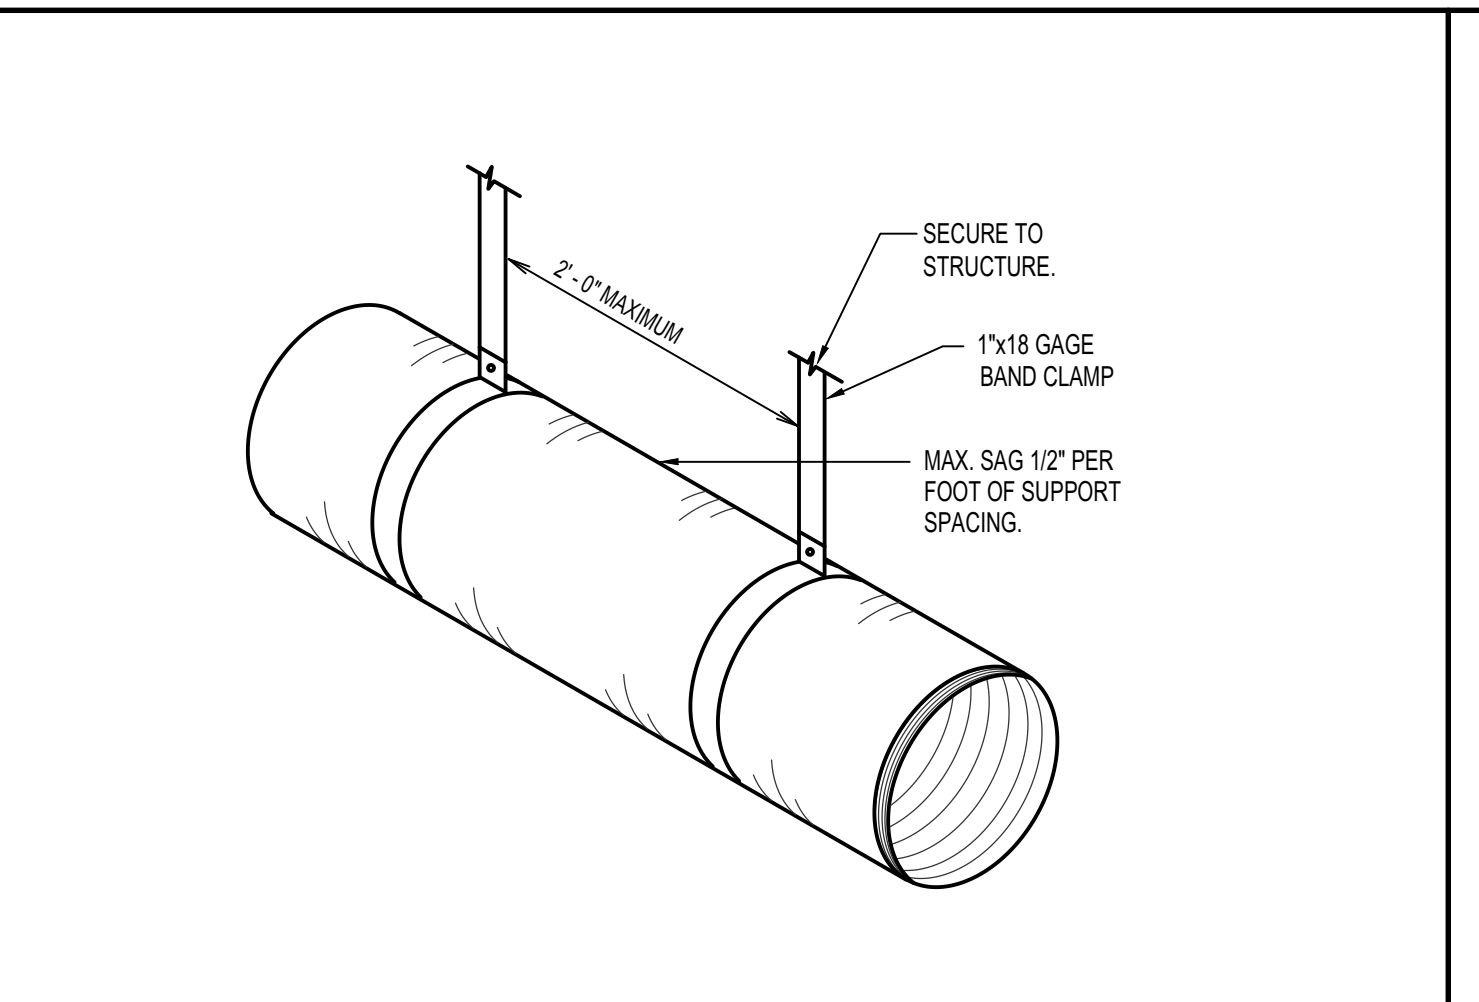


B FLEXIBLE DUCT SUPPORT DETAIL NO SCALE

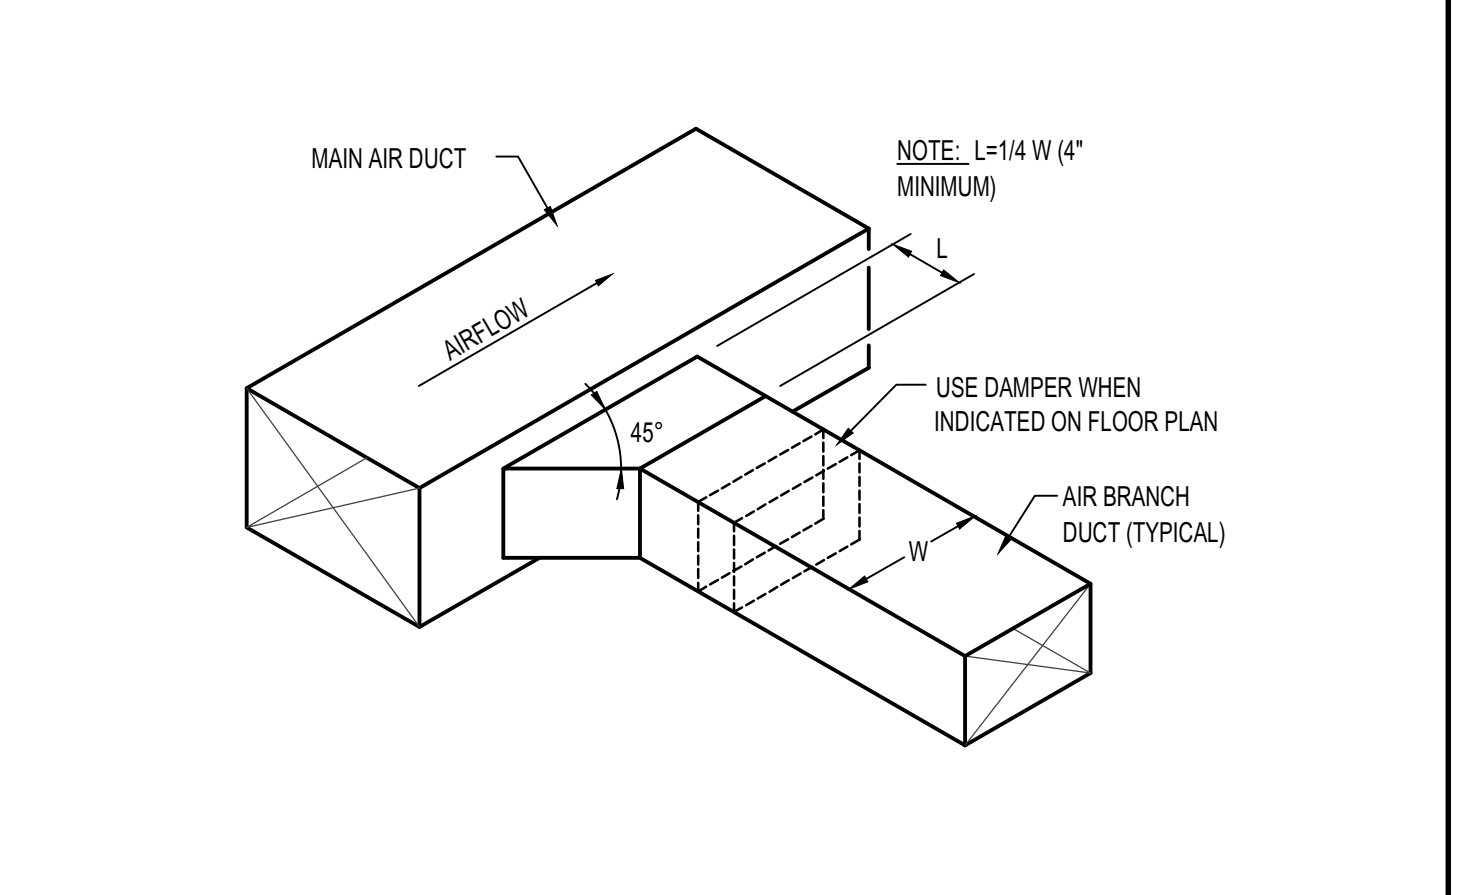


G RECTANGULAR DUCT CONNECTION NO SCALE

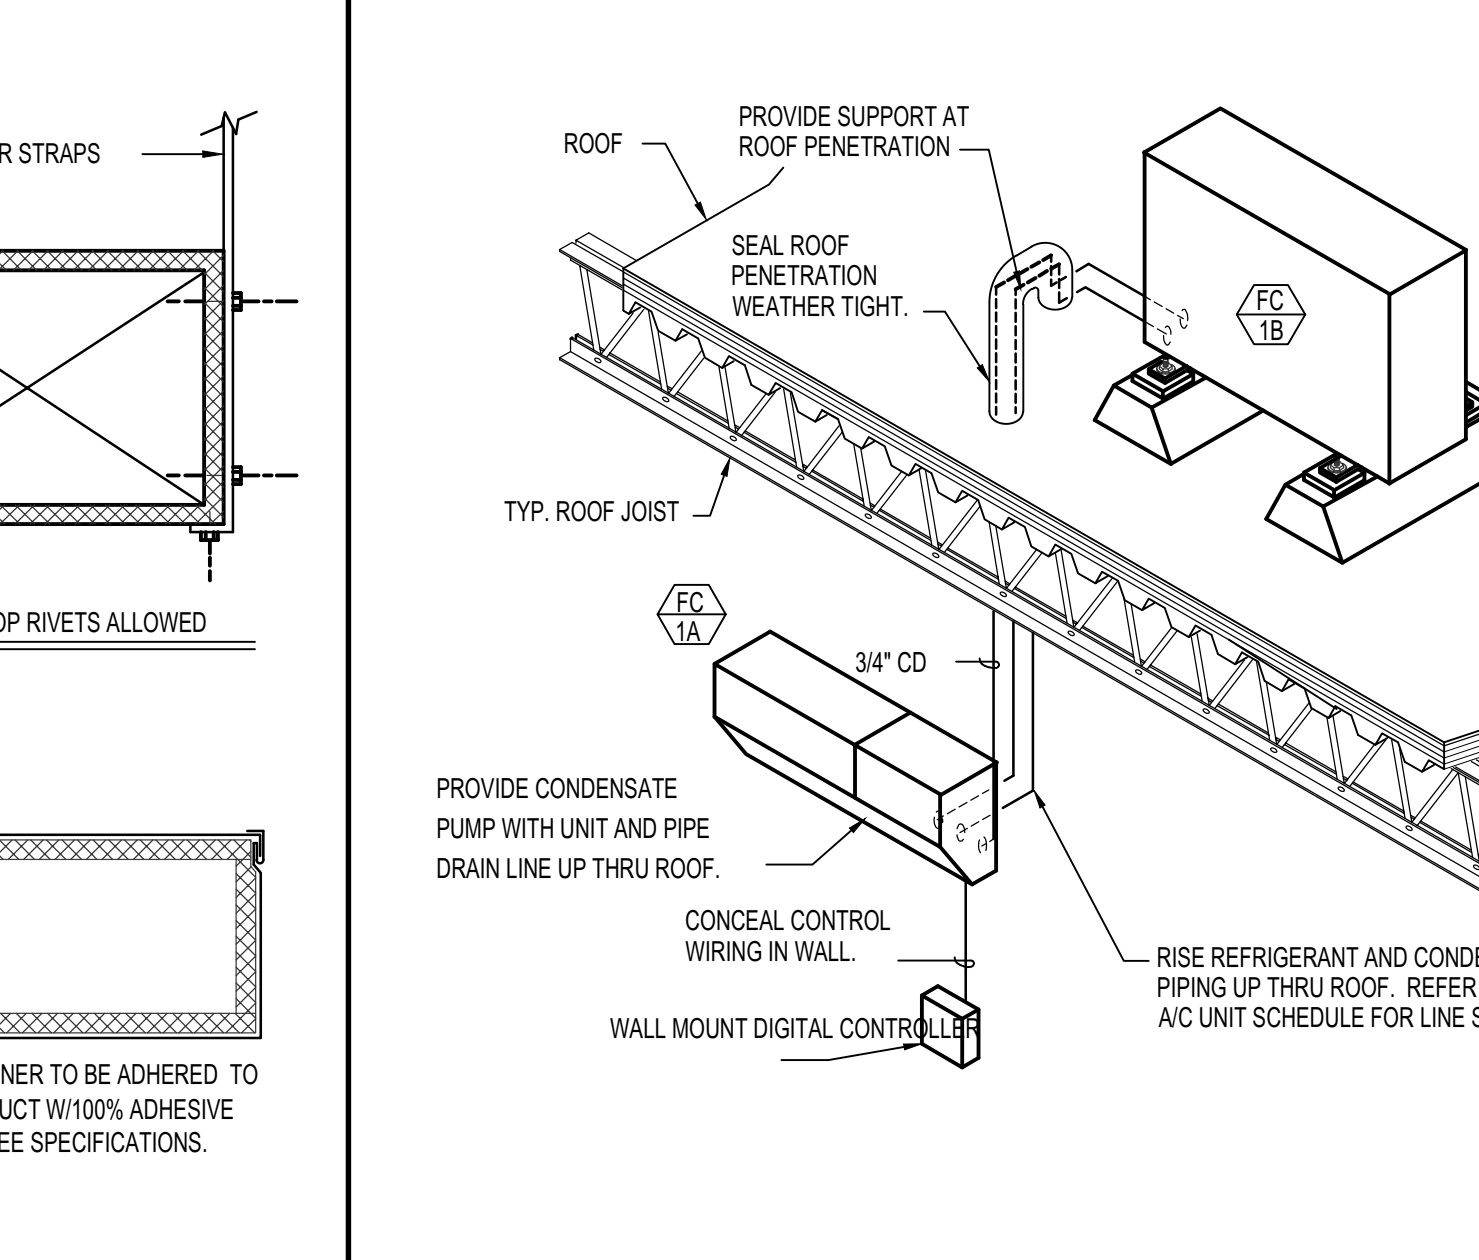


M FAN COIL & REFRIGERANT PIPING DETAIL NO SCALE

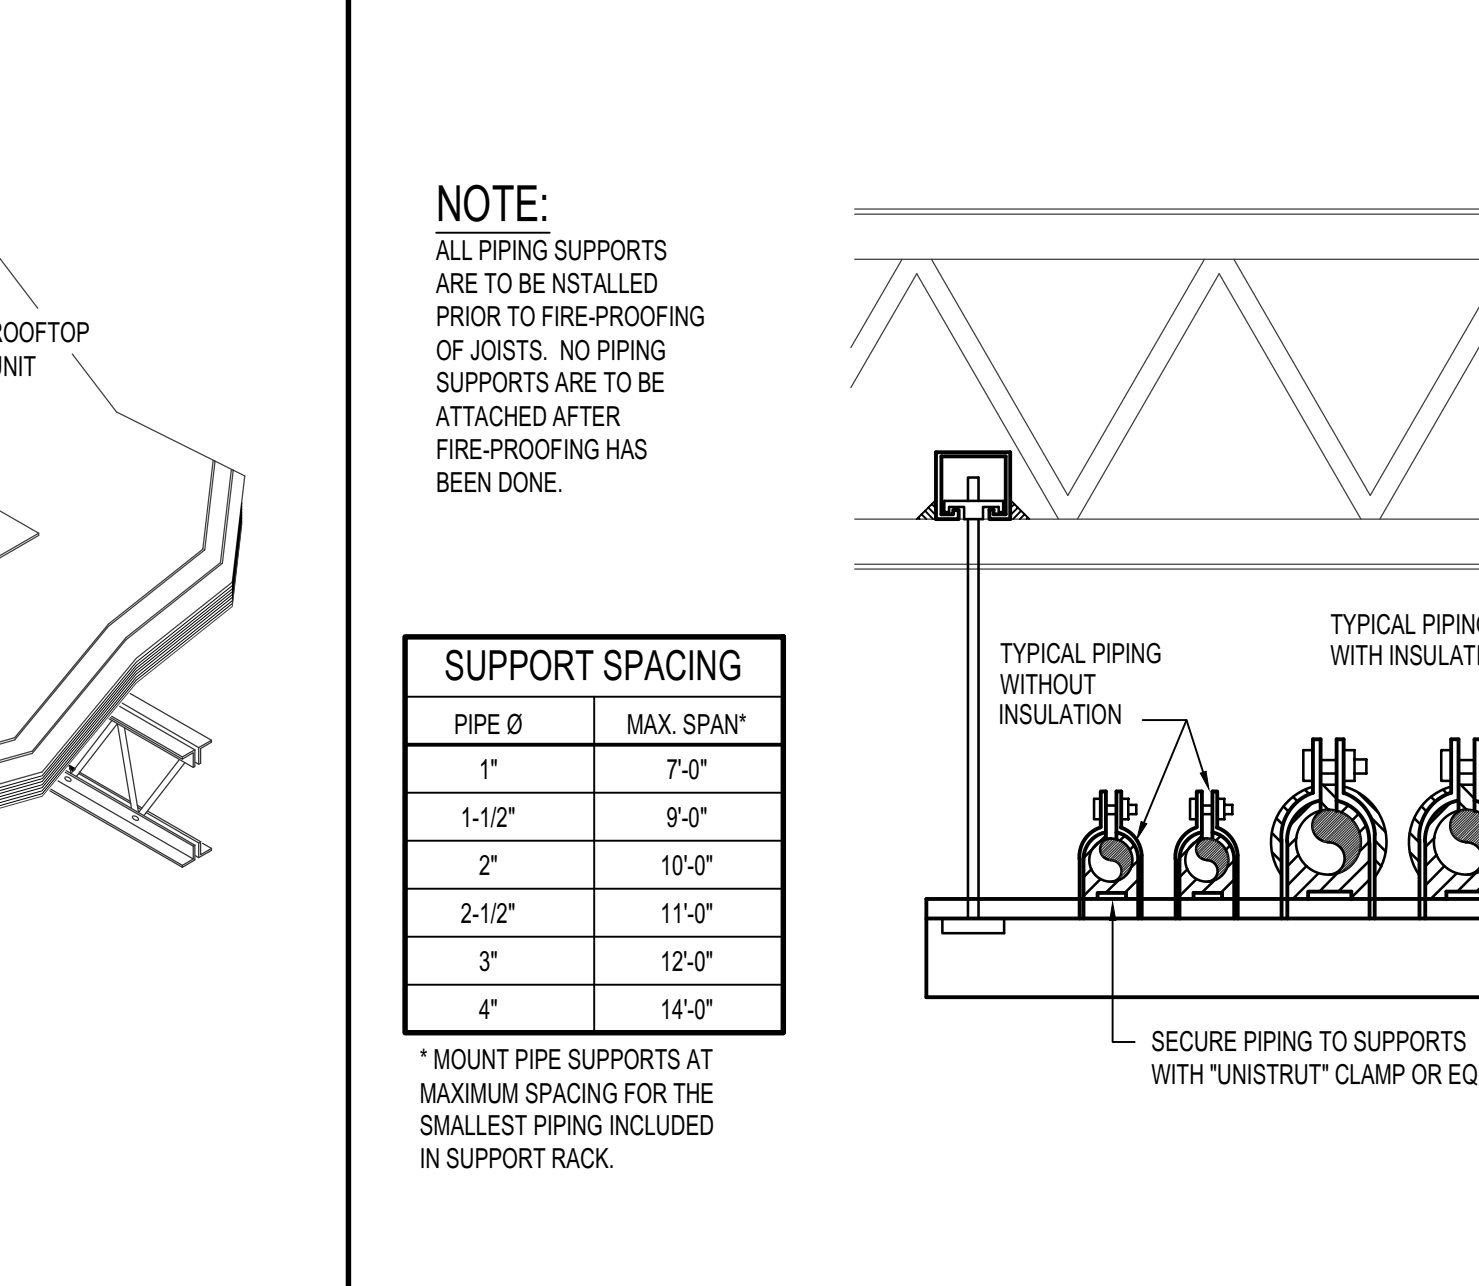


Q PIPE SUPPORT DETAIL NO SCALE

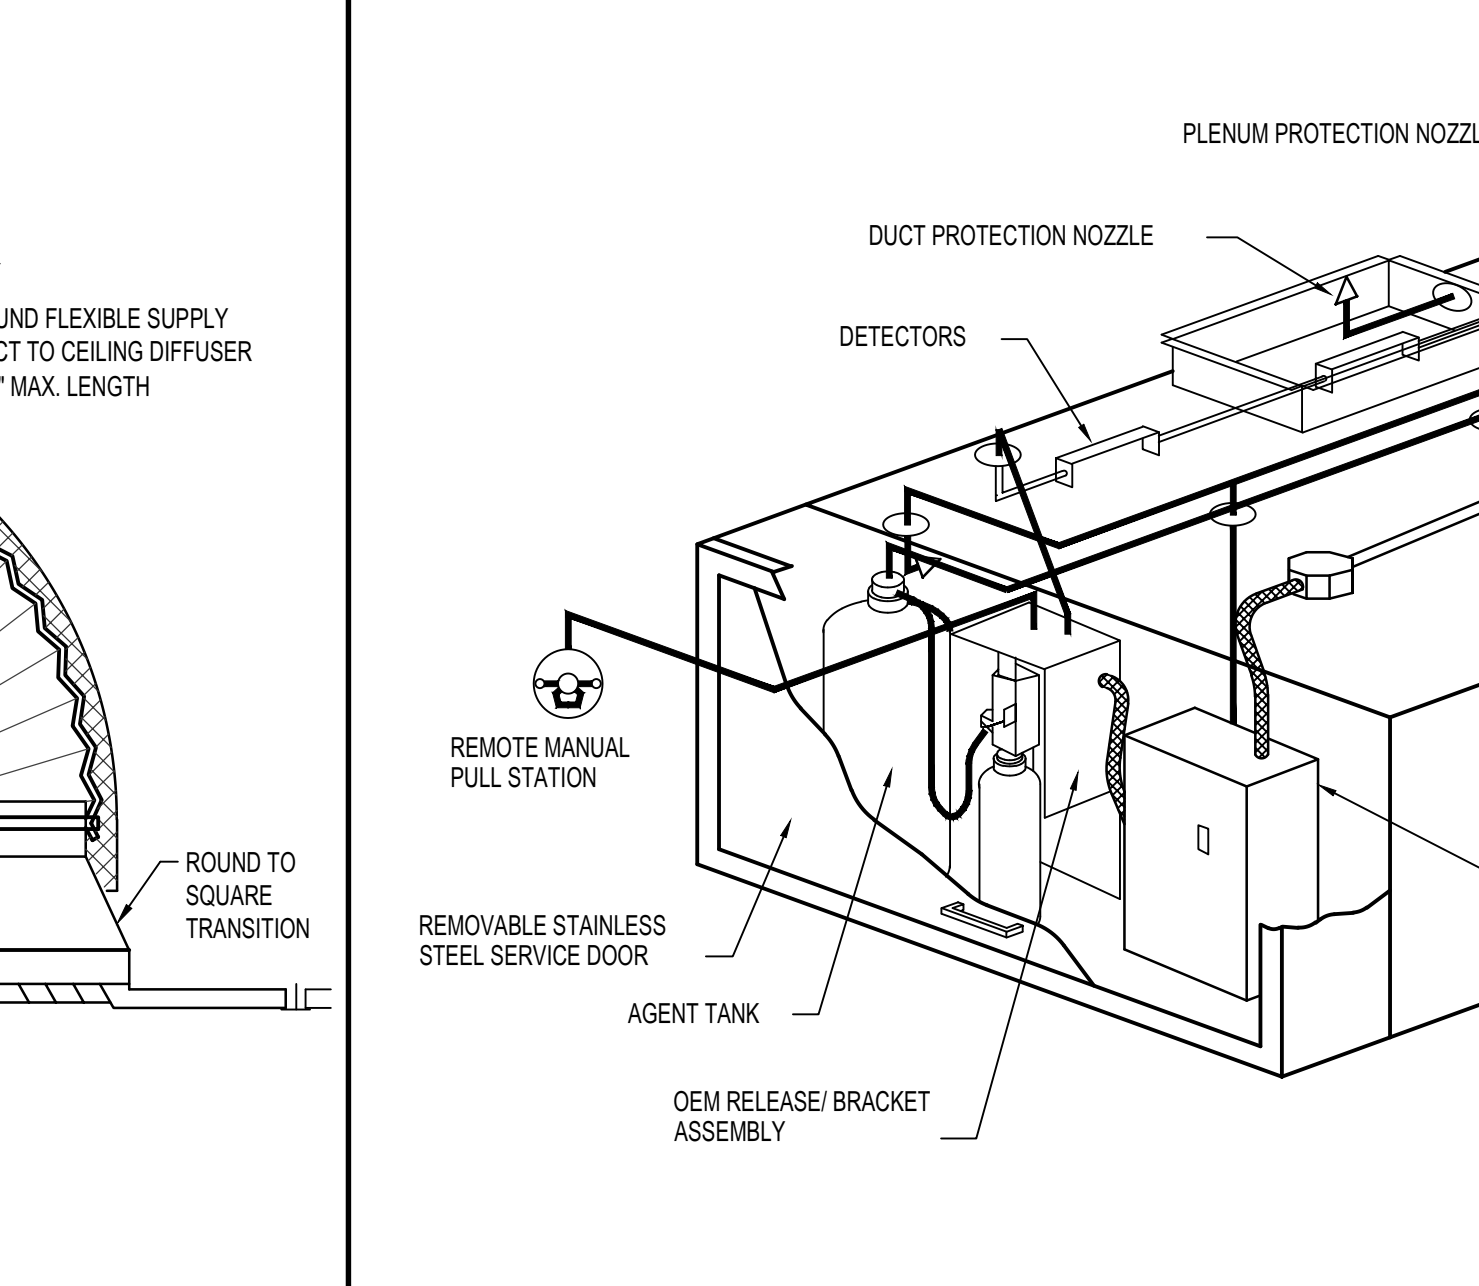


U TYPICAL ANSUL R-102 SYSTEM LAYOUT NO SCALE

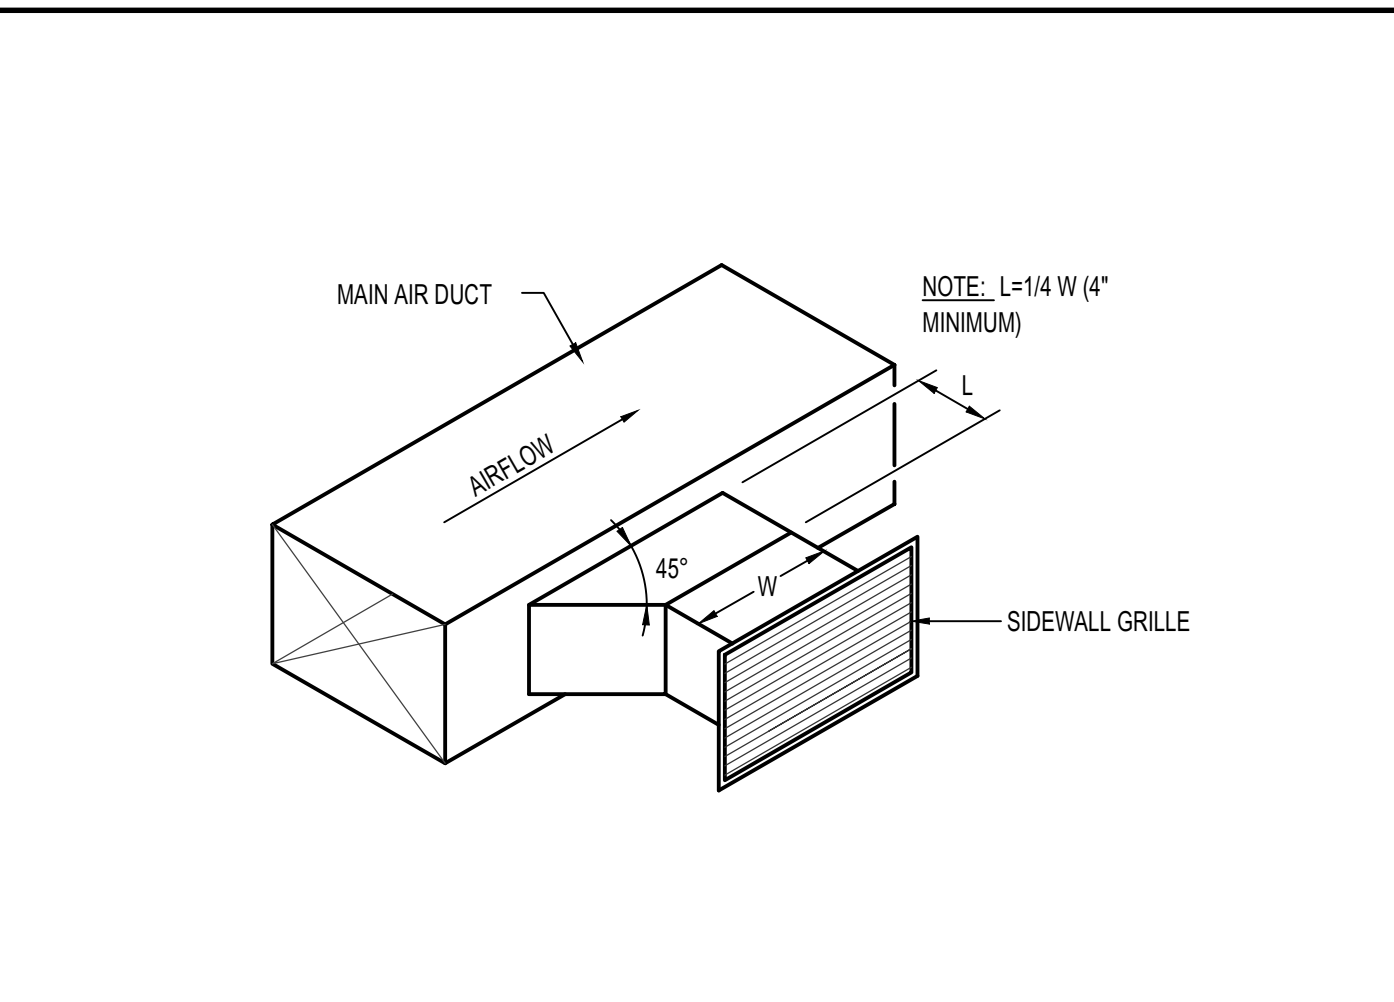


C SIDEWALL GRILLE CONNECTION NO SCALE

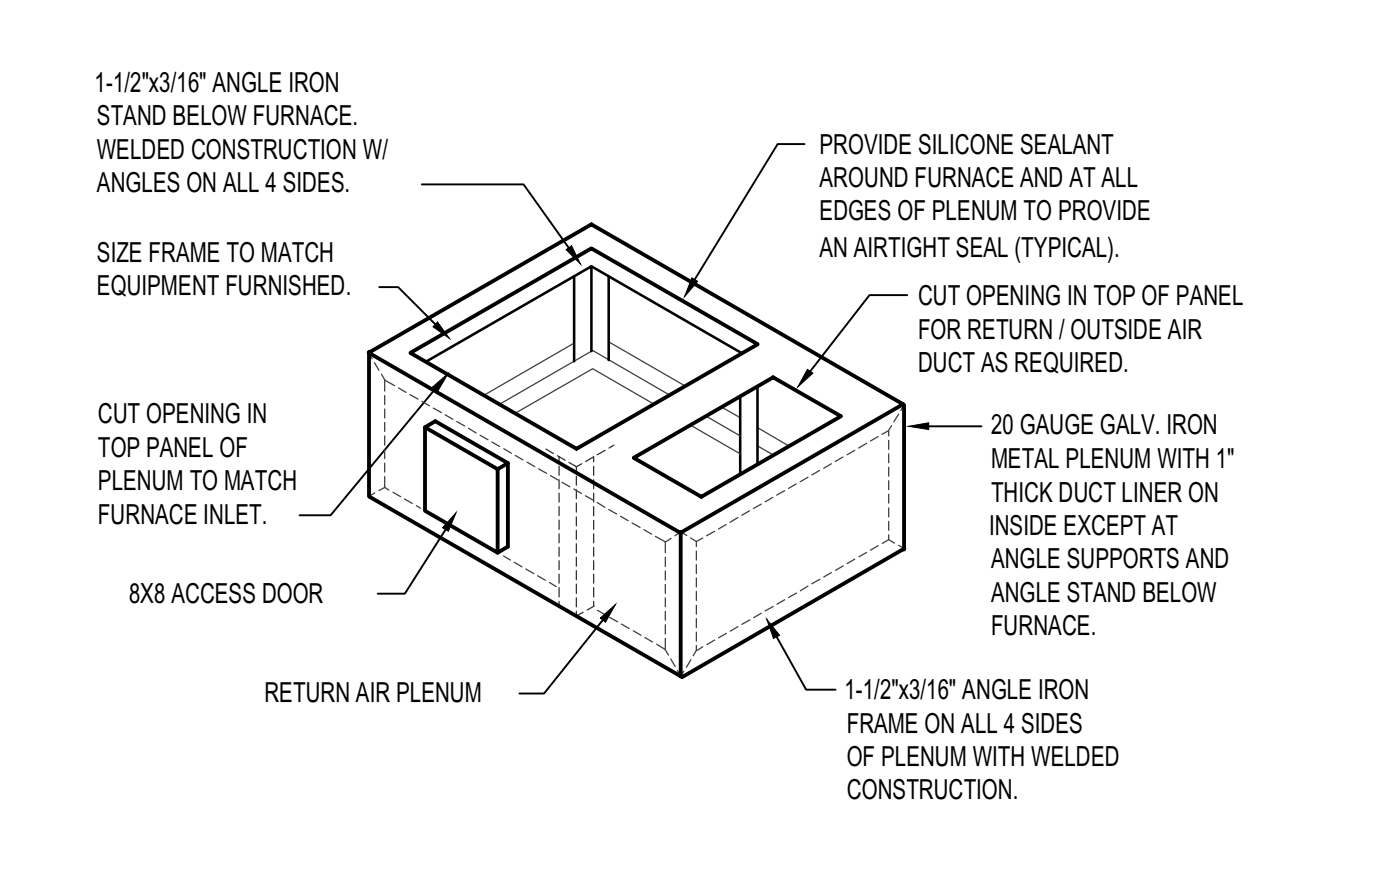


H RETURN AIR PLENUM BASE DETAIL NO SCALE

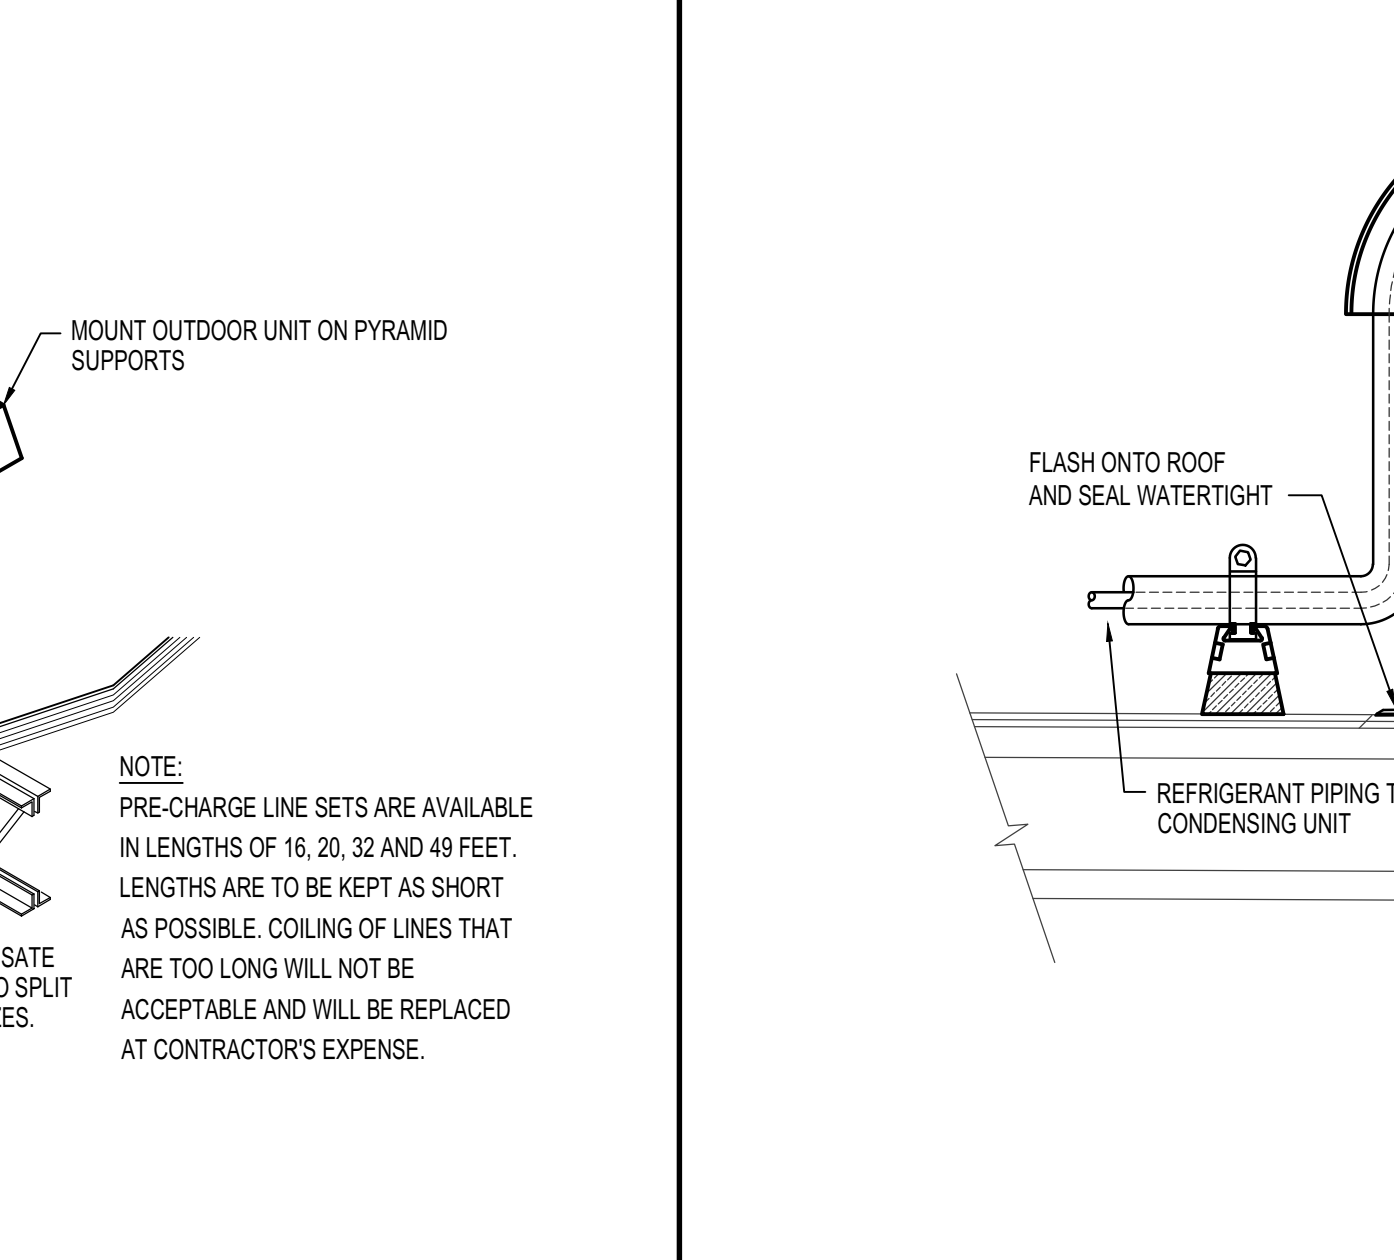


N REFRIGERANT PIPING THRU ROOF DETAIL NO SCALE

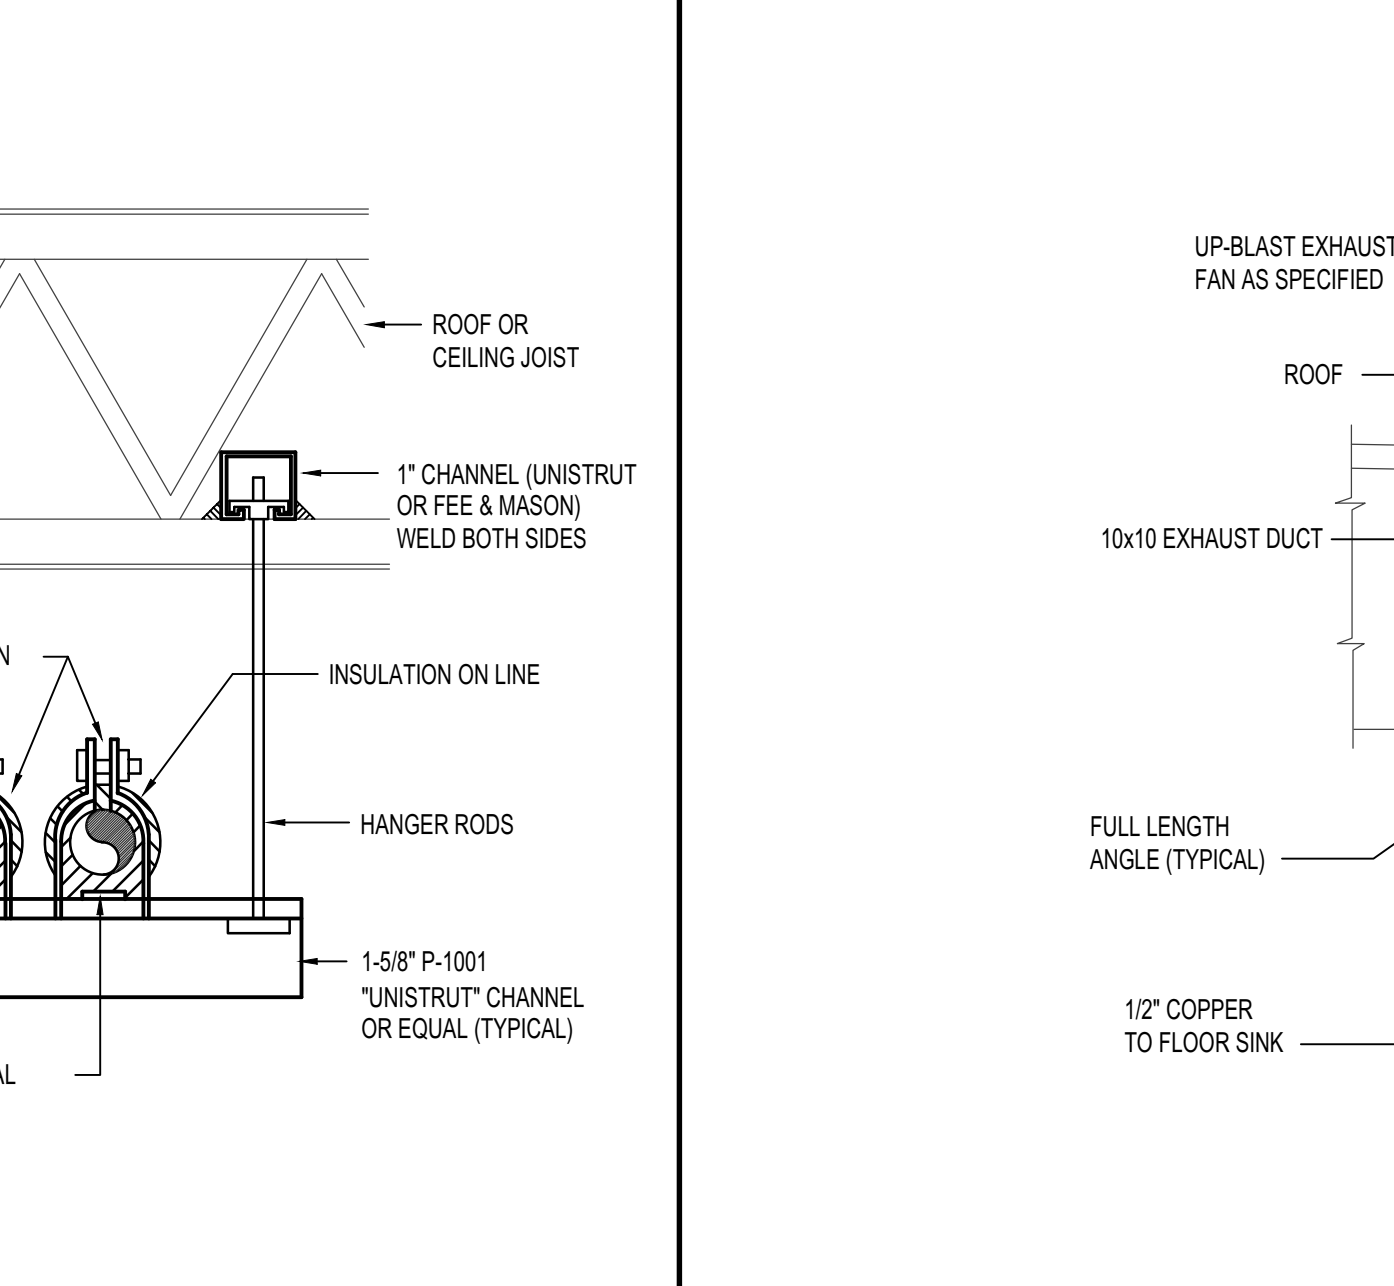


Q PIPE SUPPORT DETAIL NO SCALE

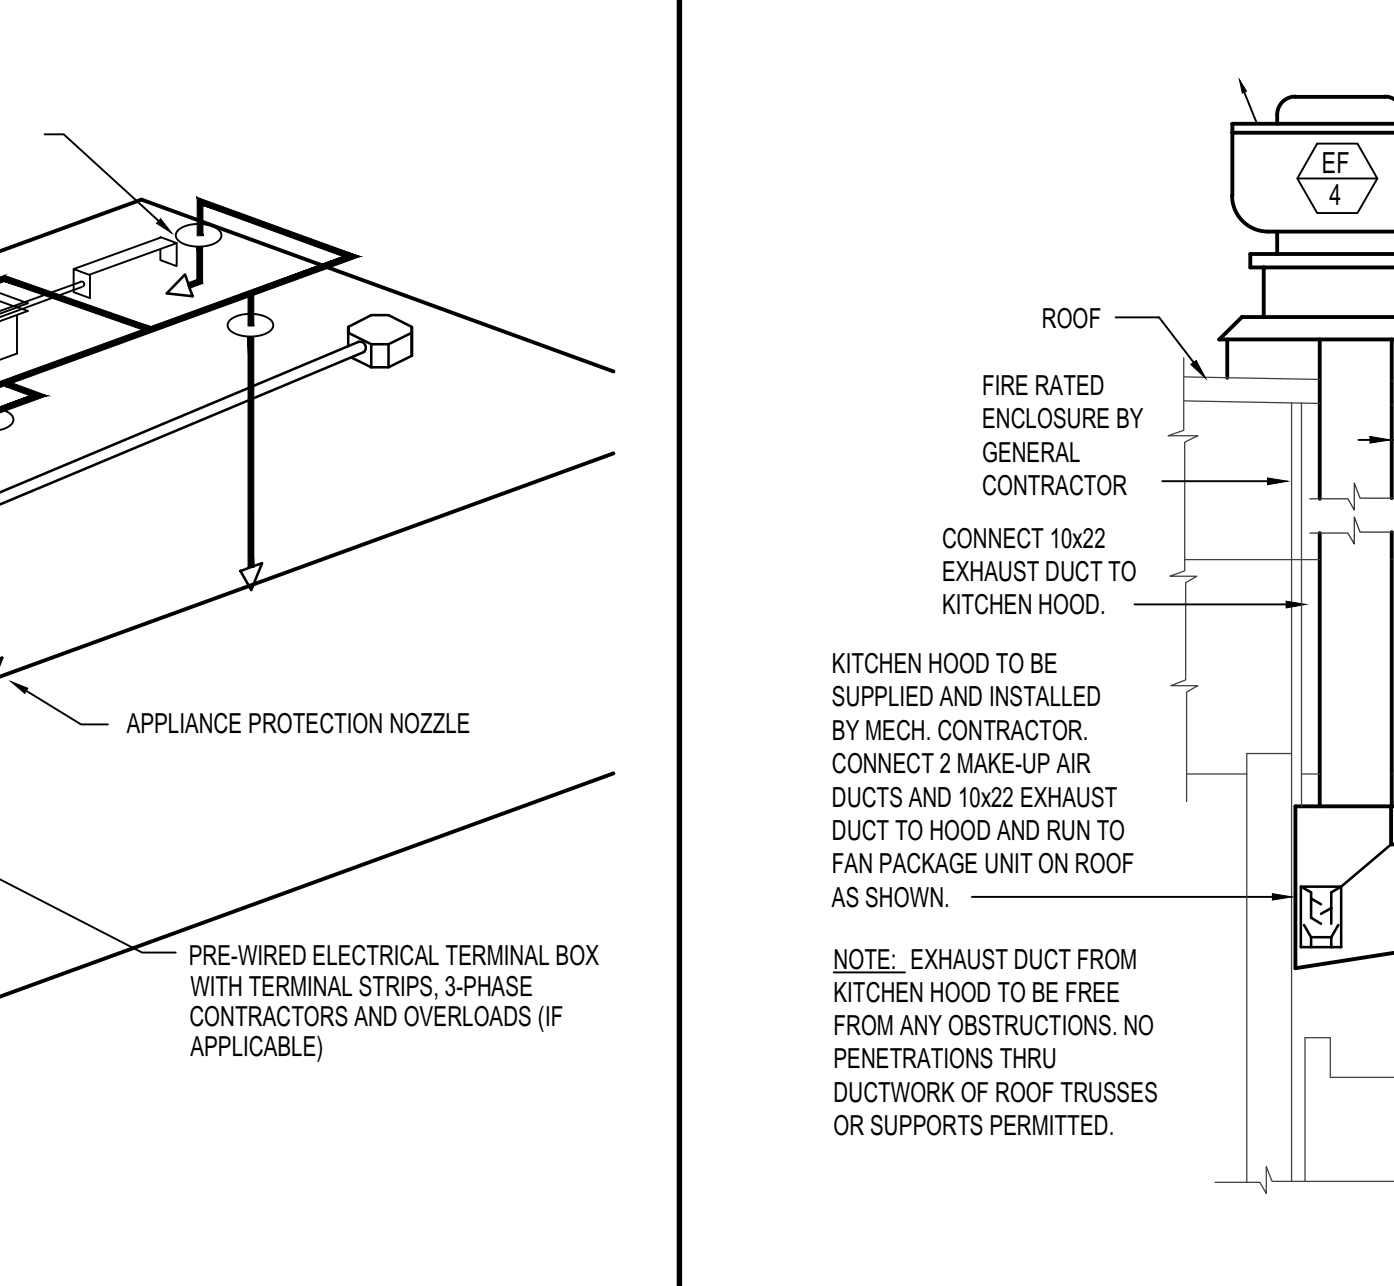


V KITCHEN HOOD SECTION NO SCALE

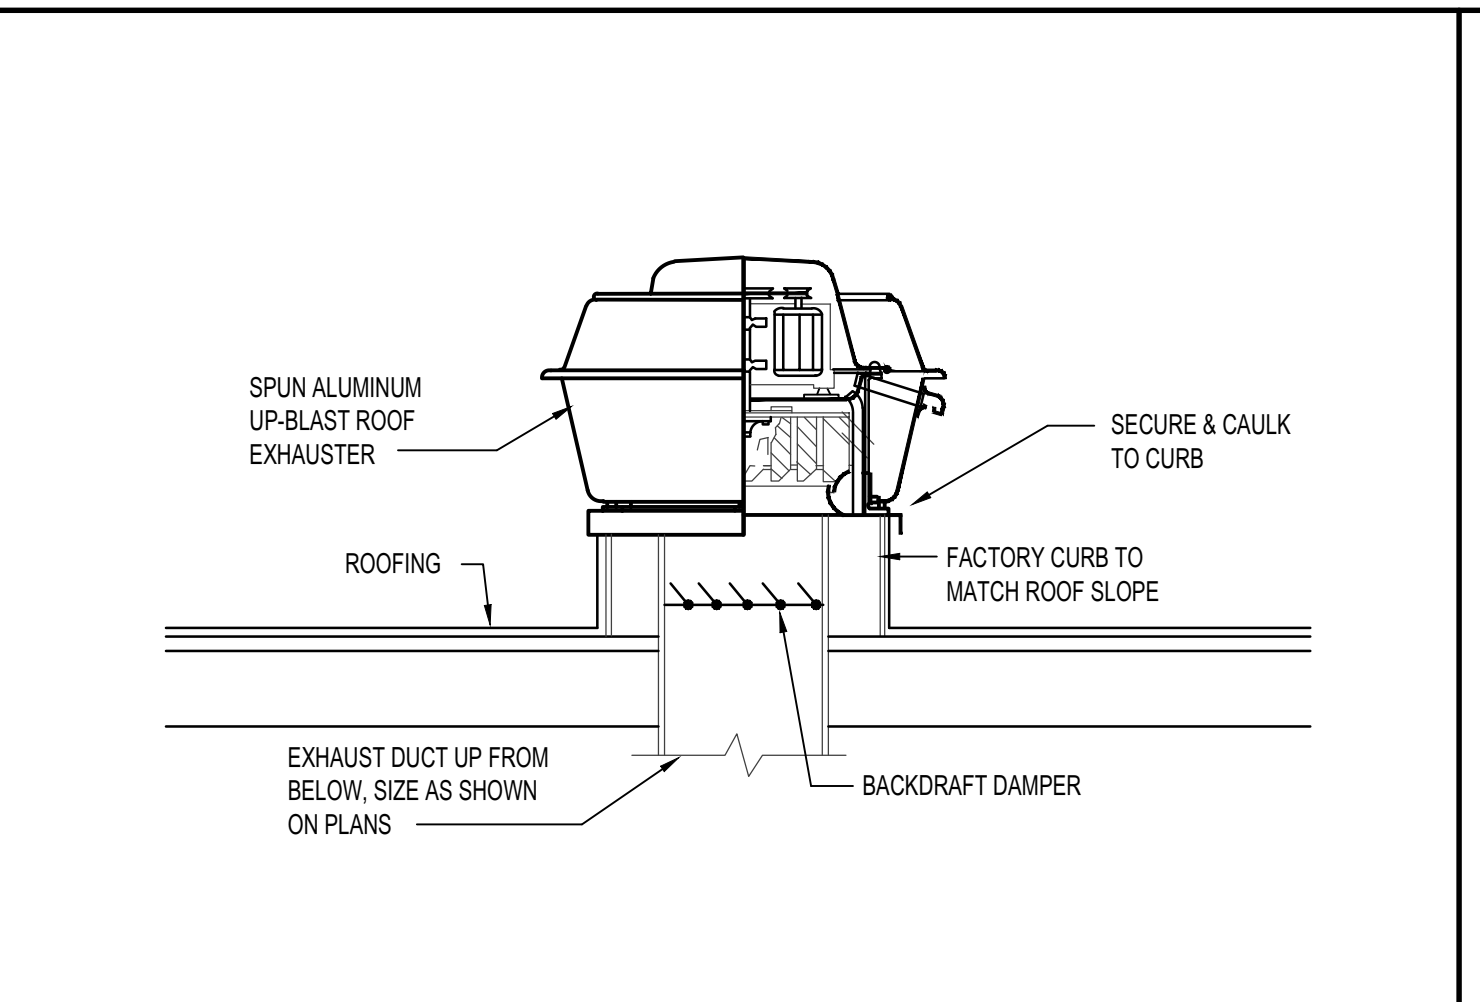


D ROOF TOP EXHAUST FAN DETAIL NO SCALE

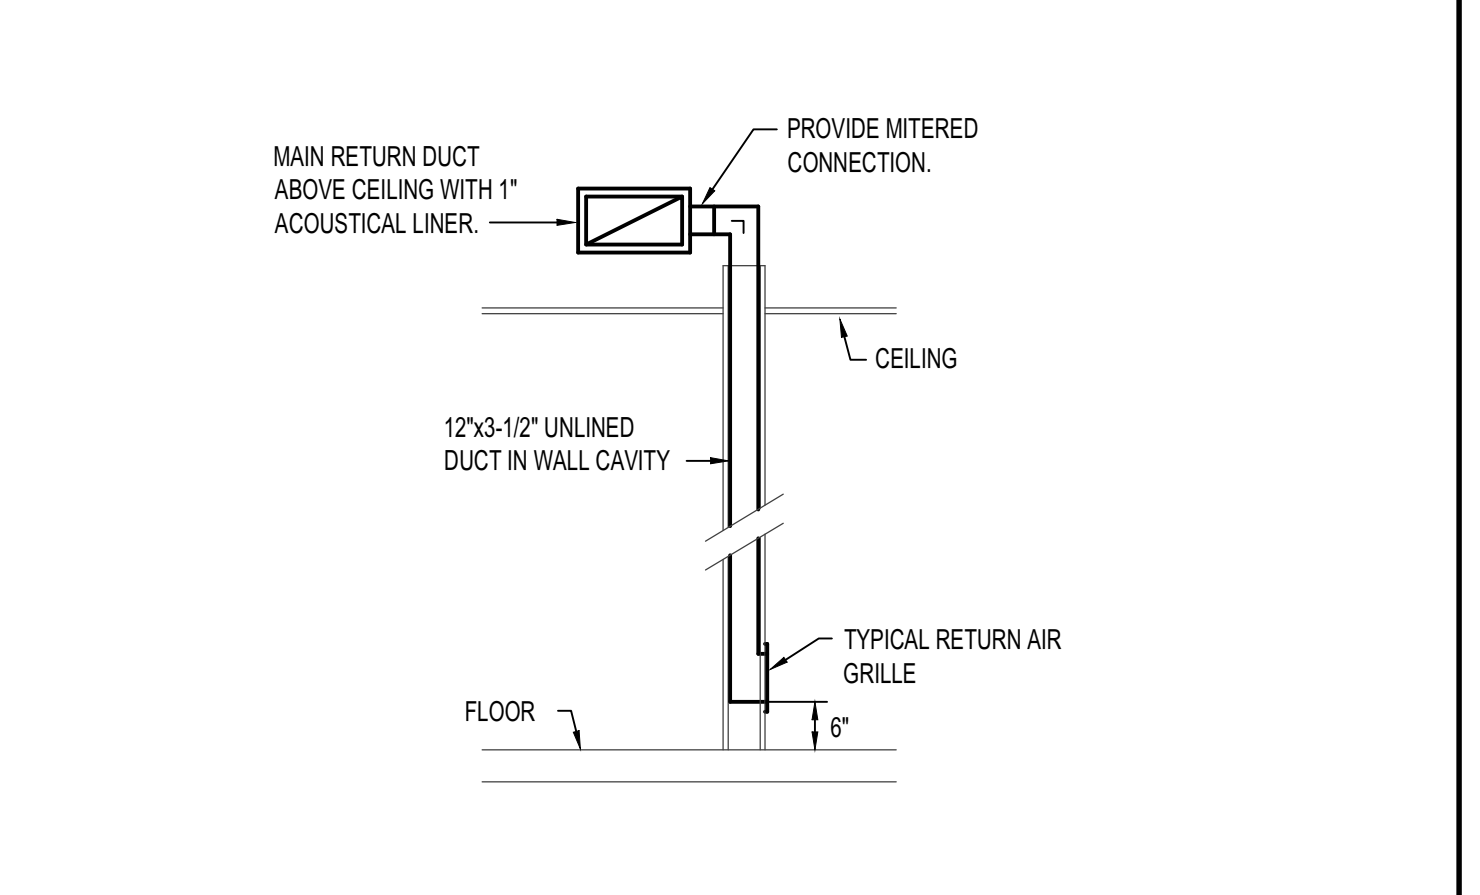


J RETURN AIR GRILLE DETAIL NO SCALE

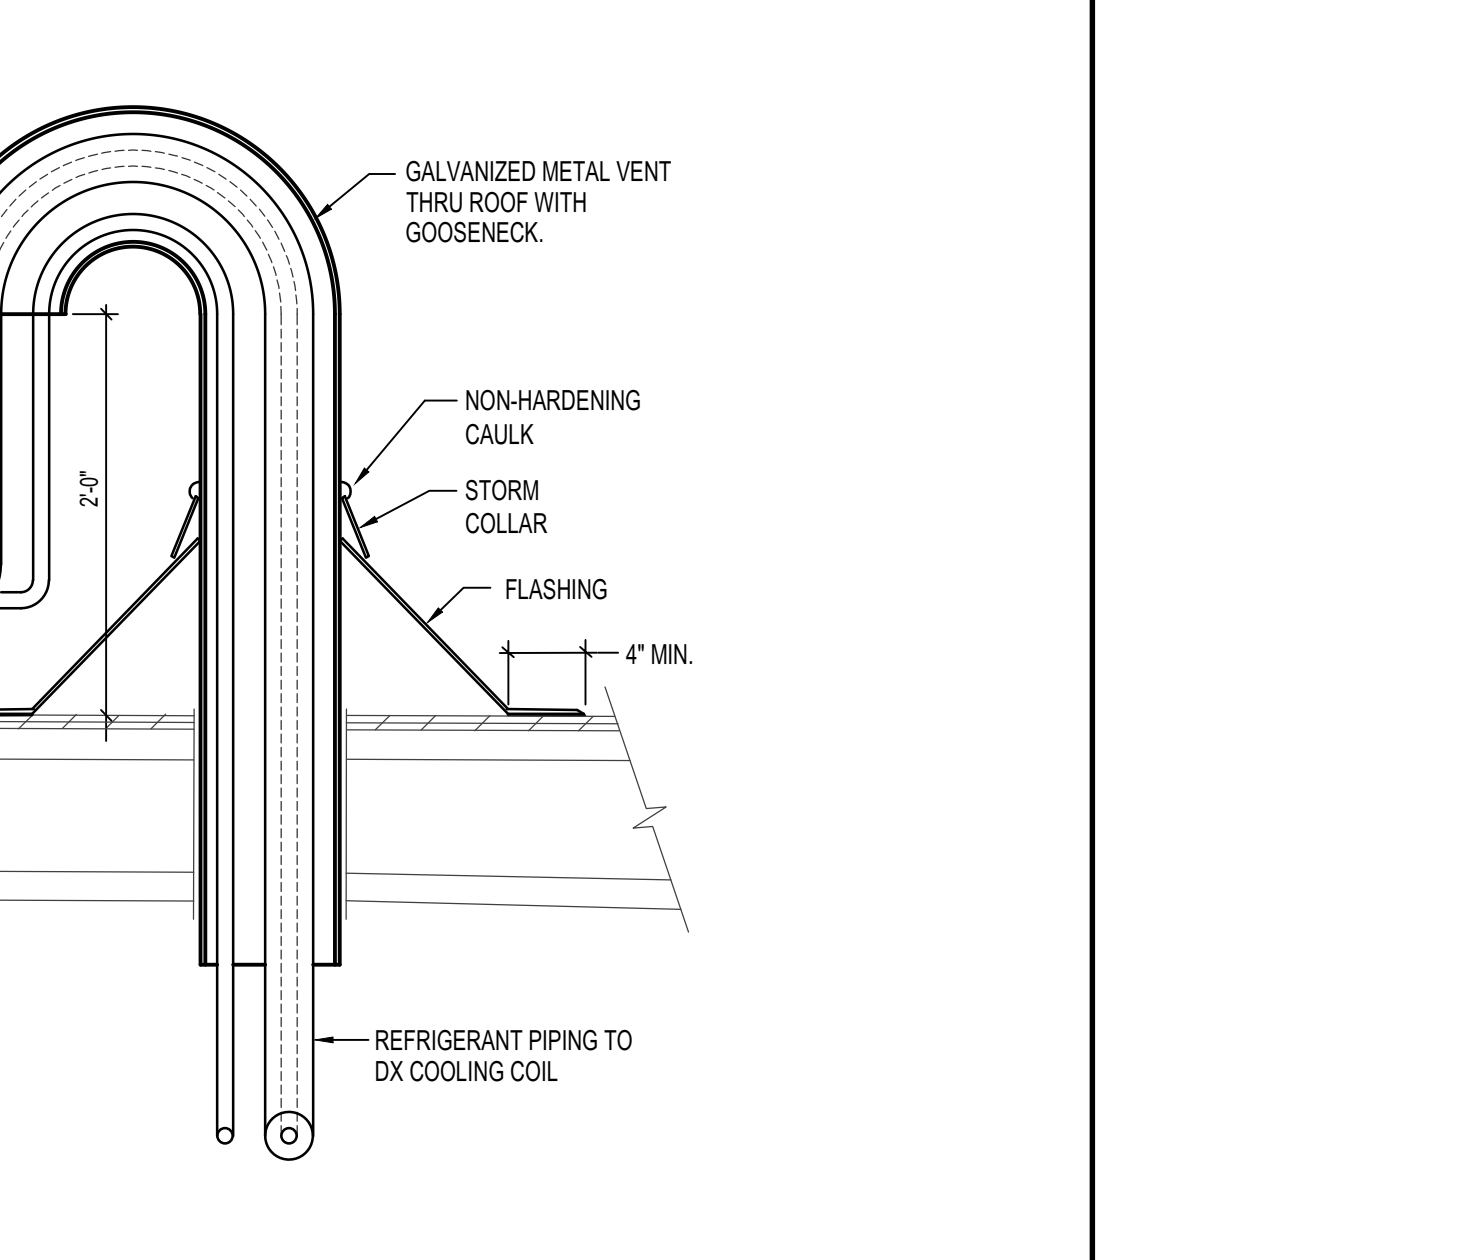


O REFRIGERANT PIPING DIAGRAM NO SCALE

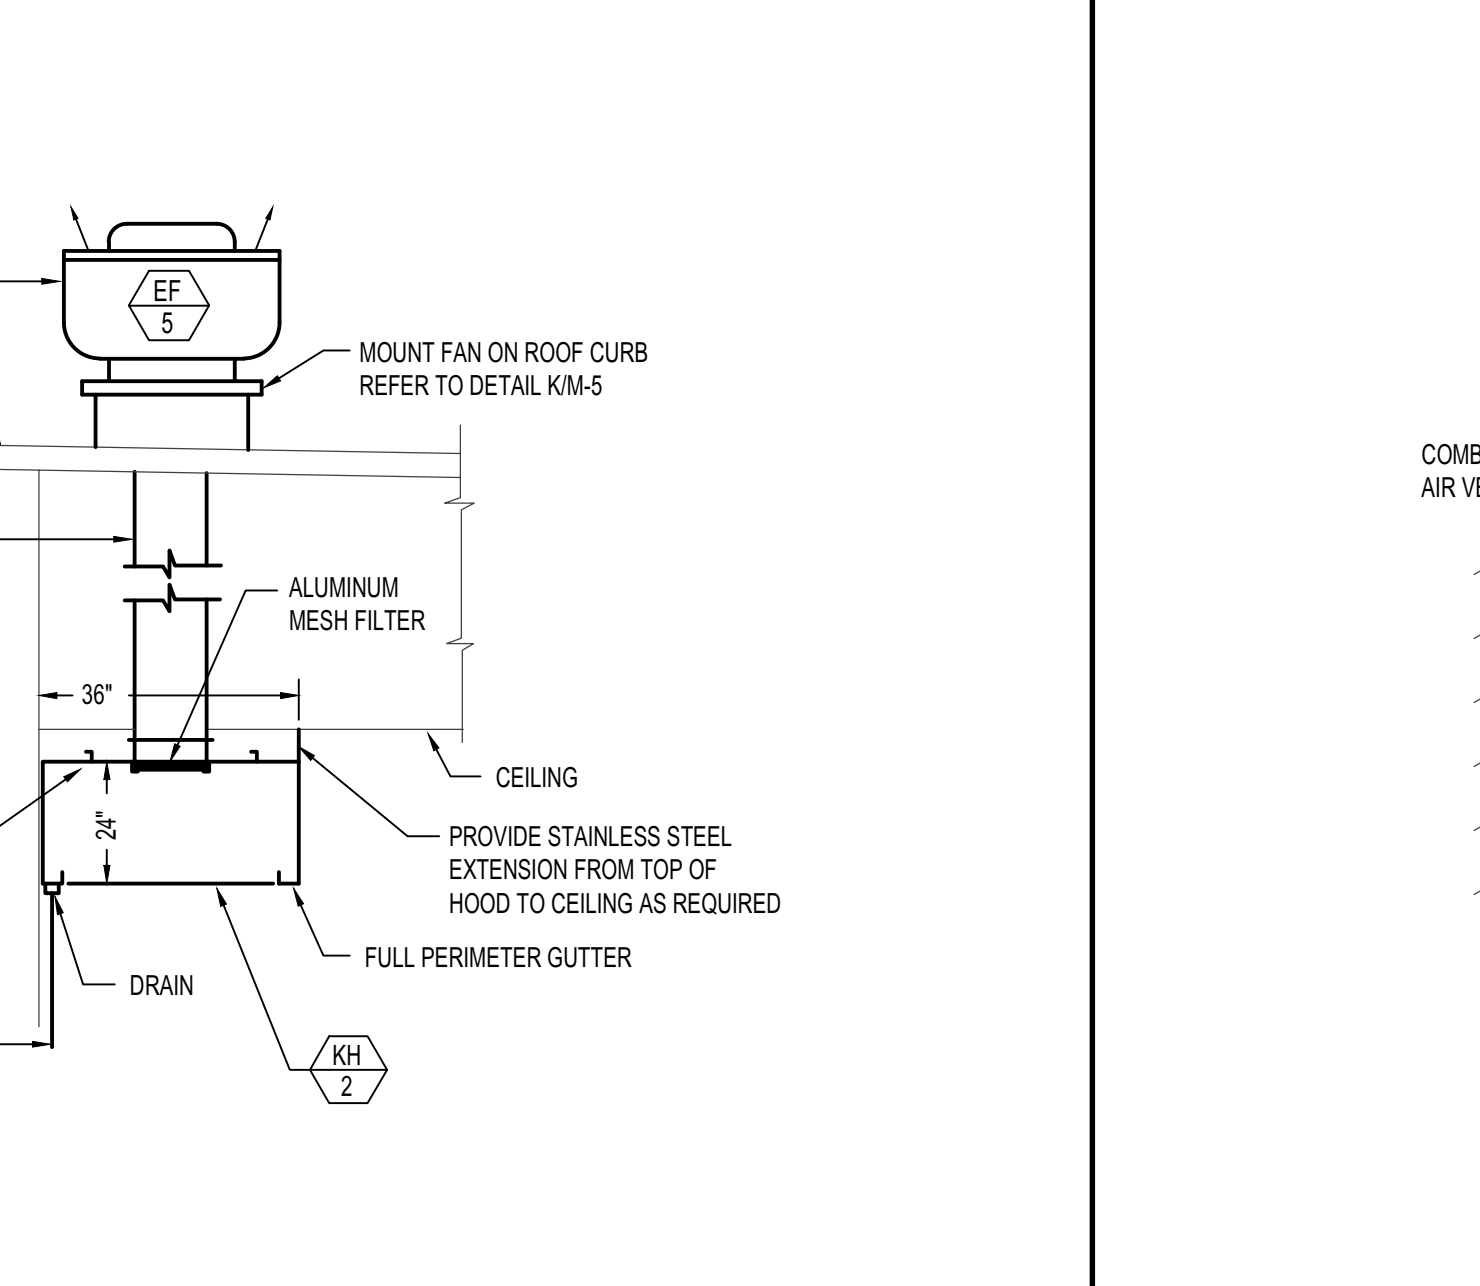


R DISHWASHER HOOD DETAIL NO SCALE

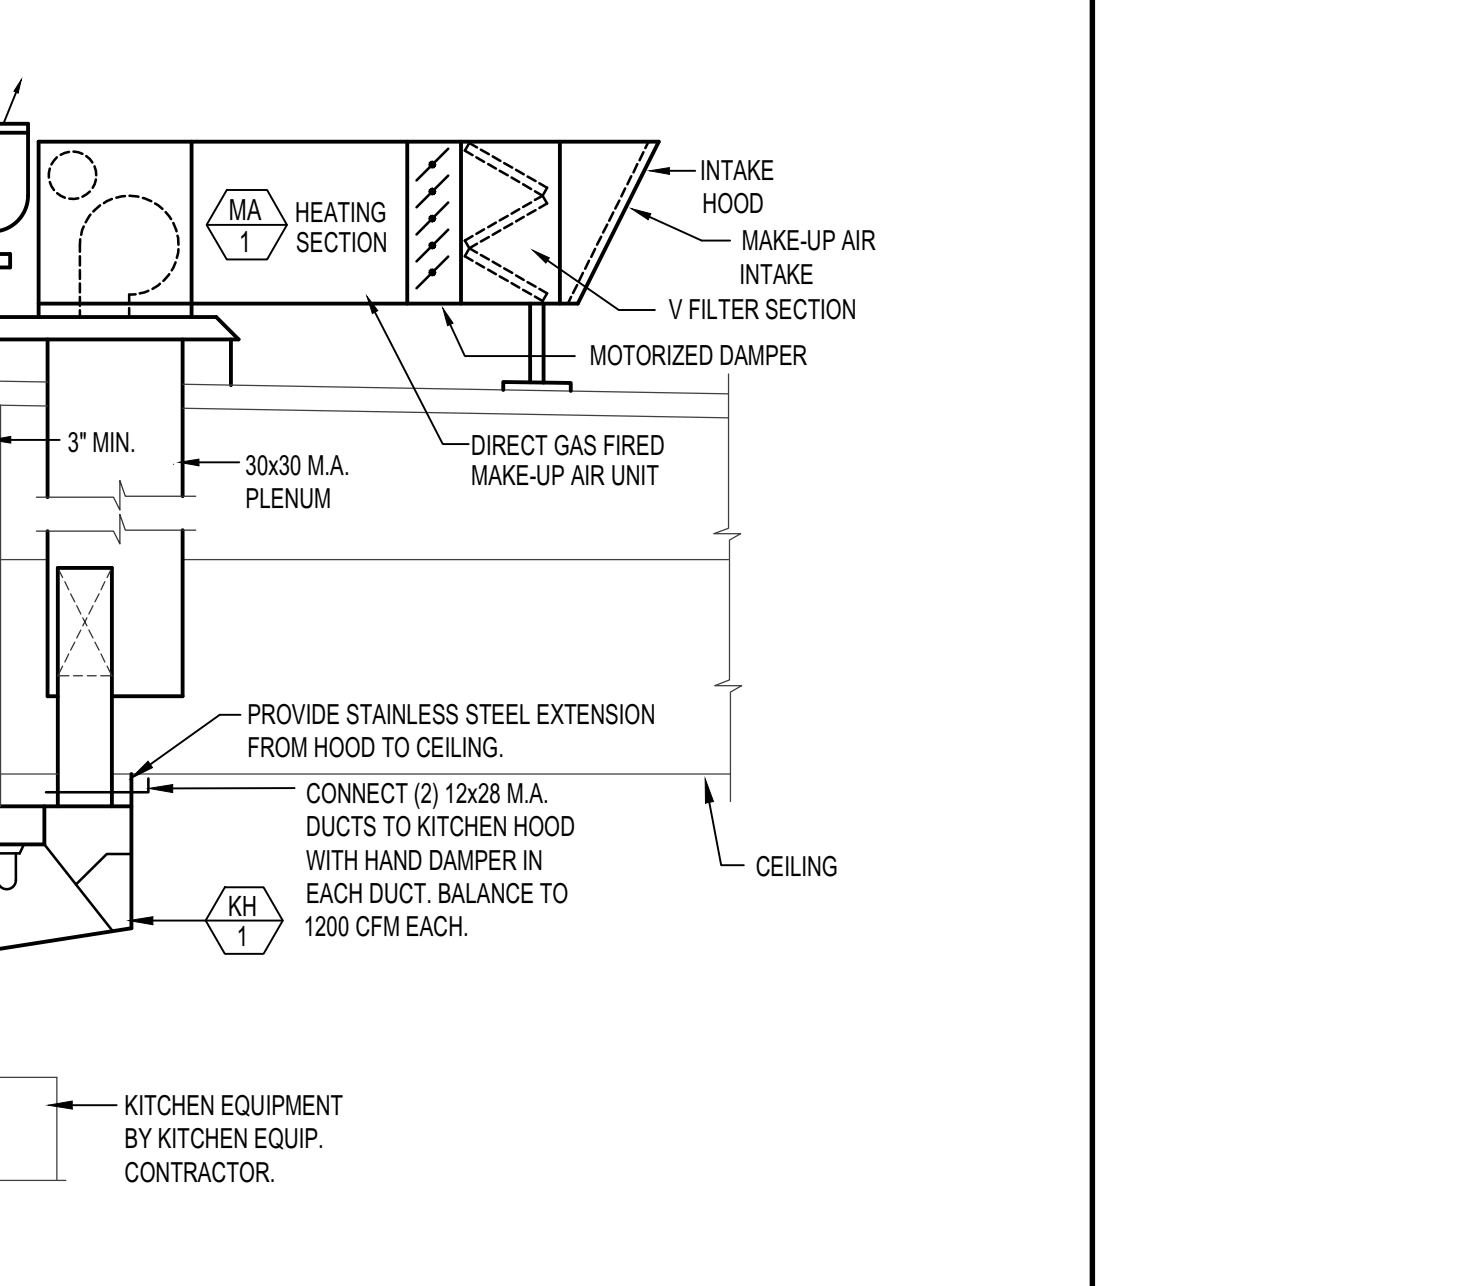


V KITCHEN HOOD SECTION NO SCALE

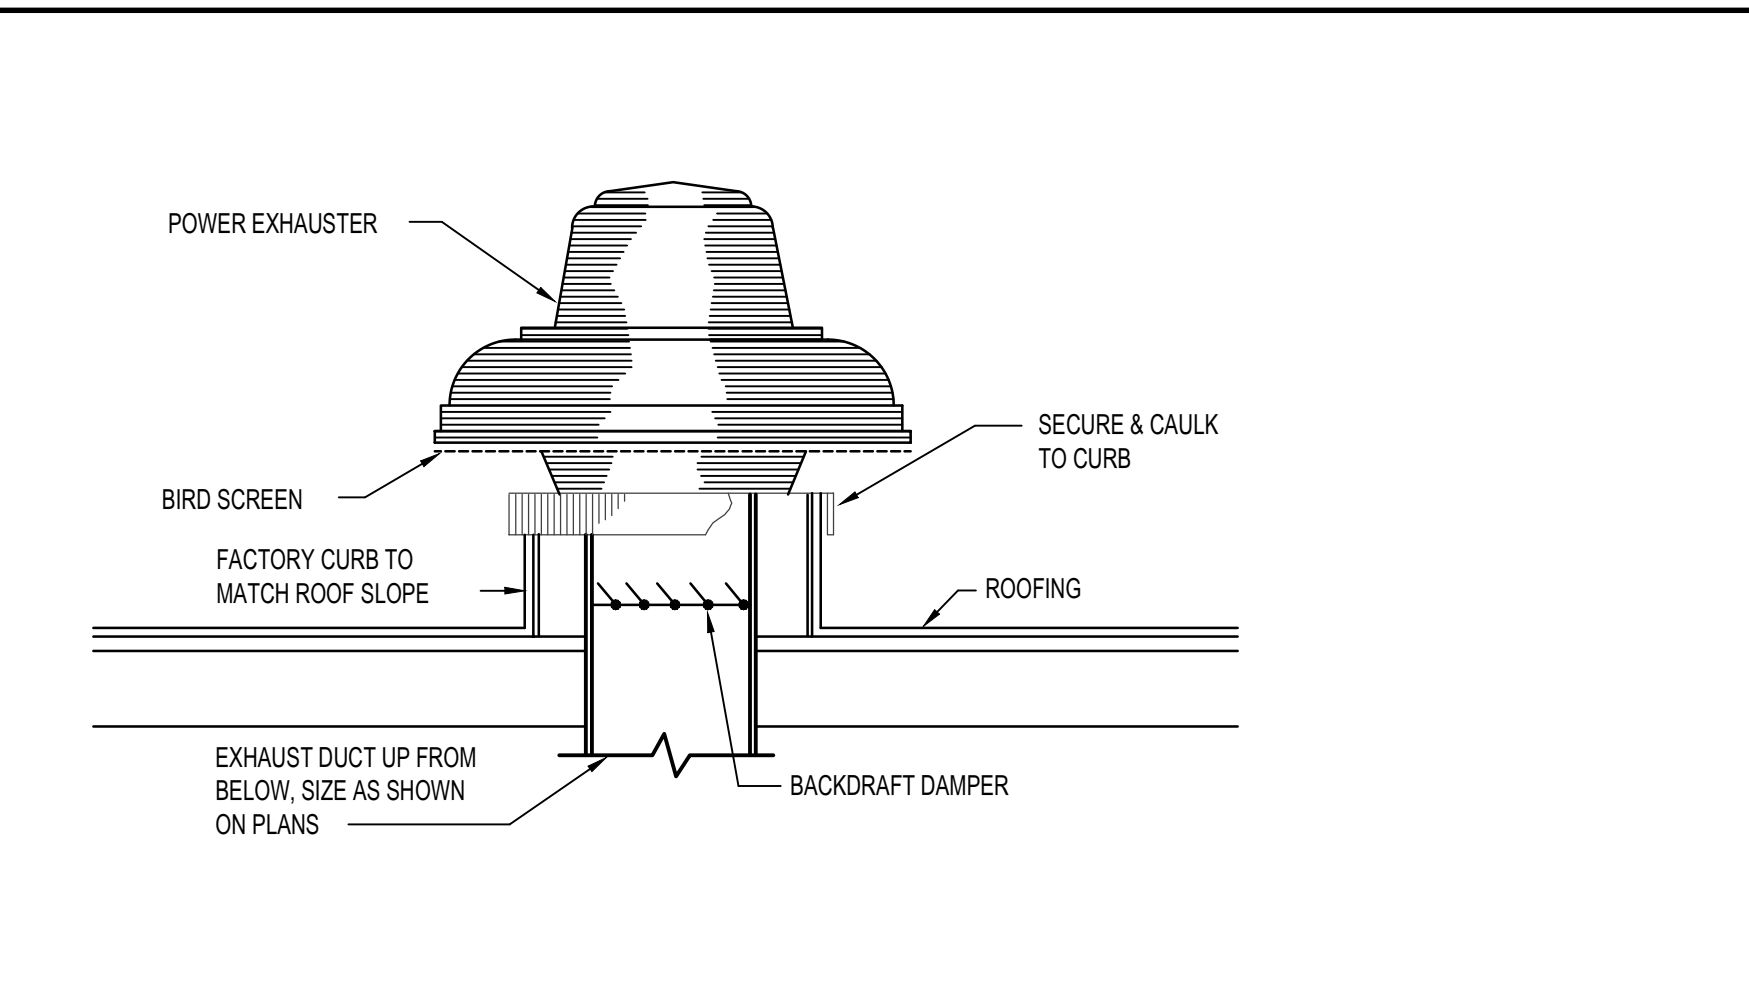


E ROOF TOP EXHAUST FAN DETAIL NO SCALE

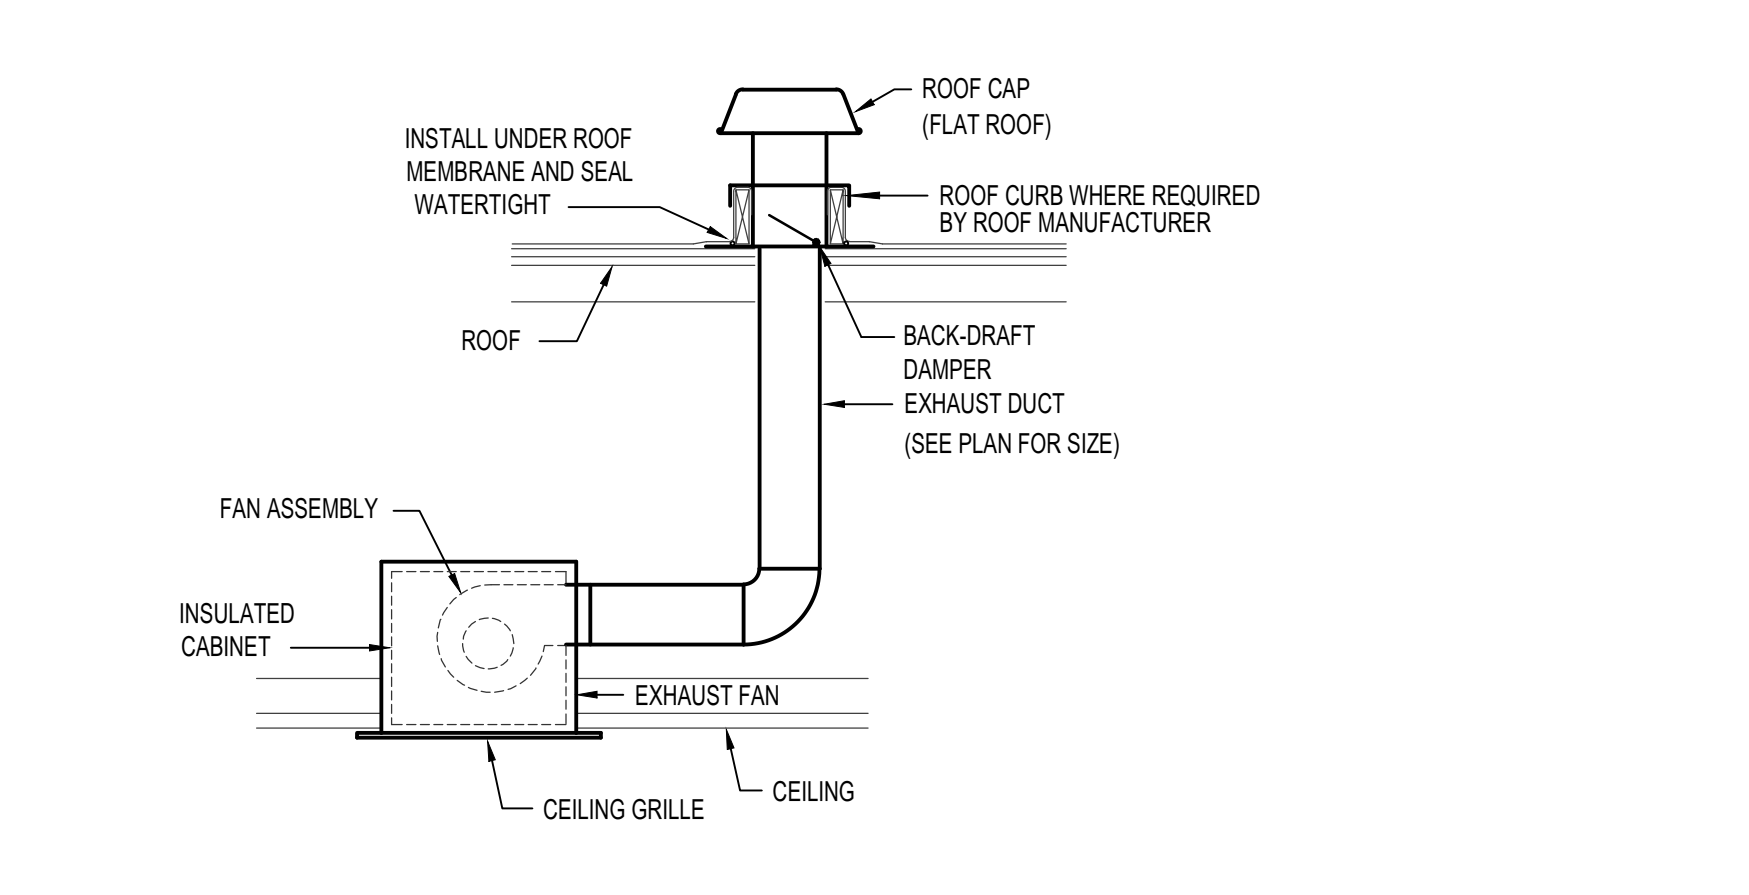


K CEILING MOUNTED EXHAUST FAN NO SCALE

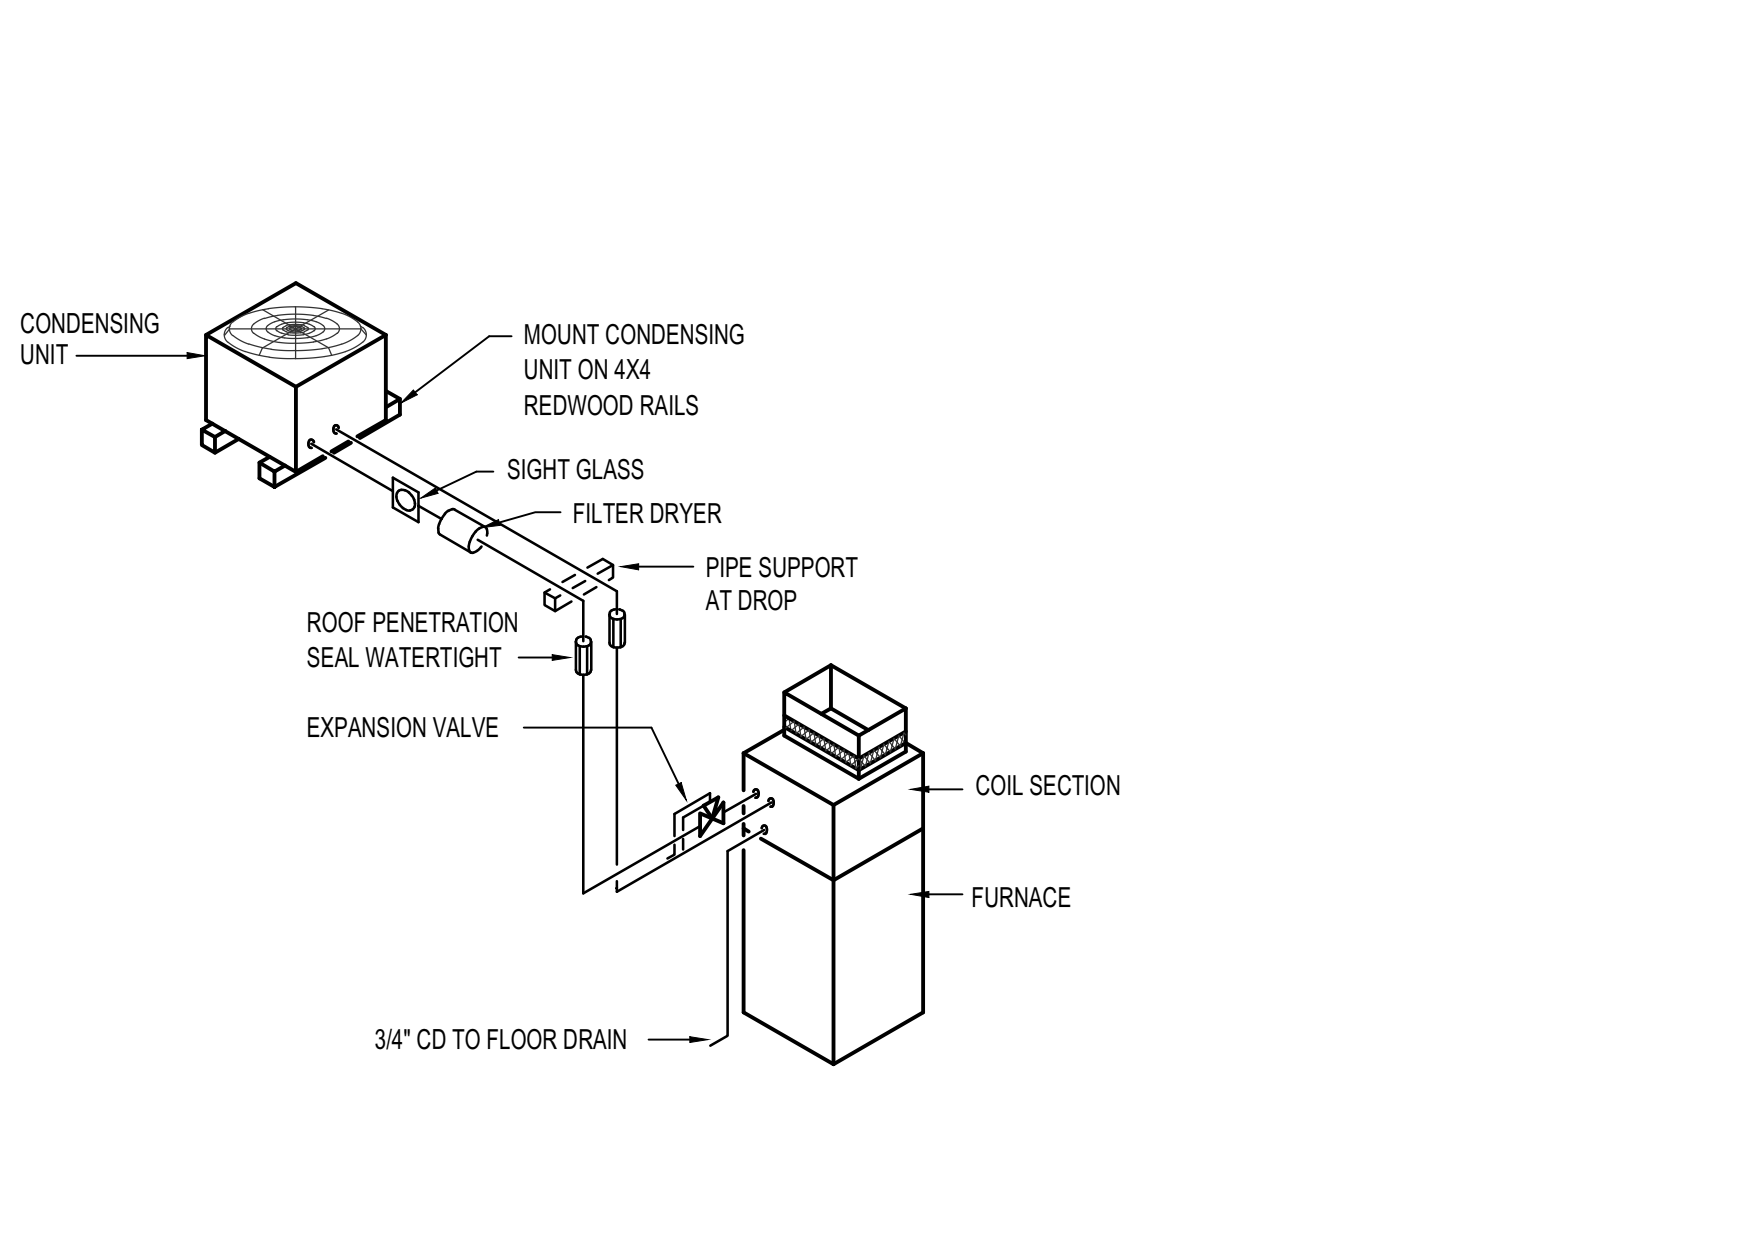

S FURNACE VENT TERMINATION DETAIL NO SCALE

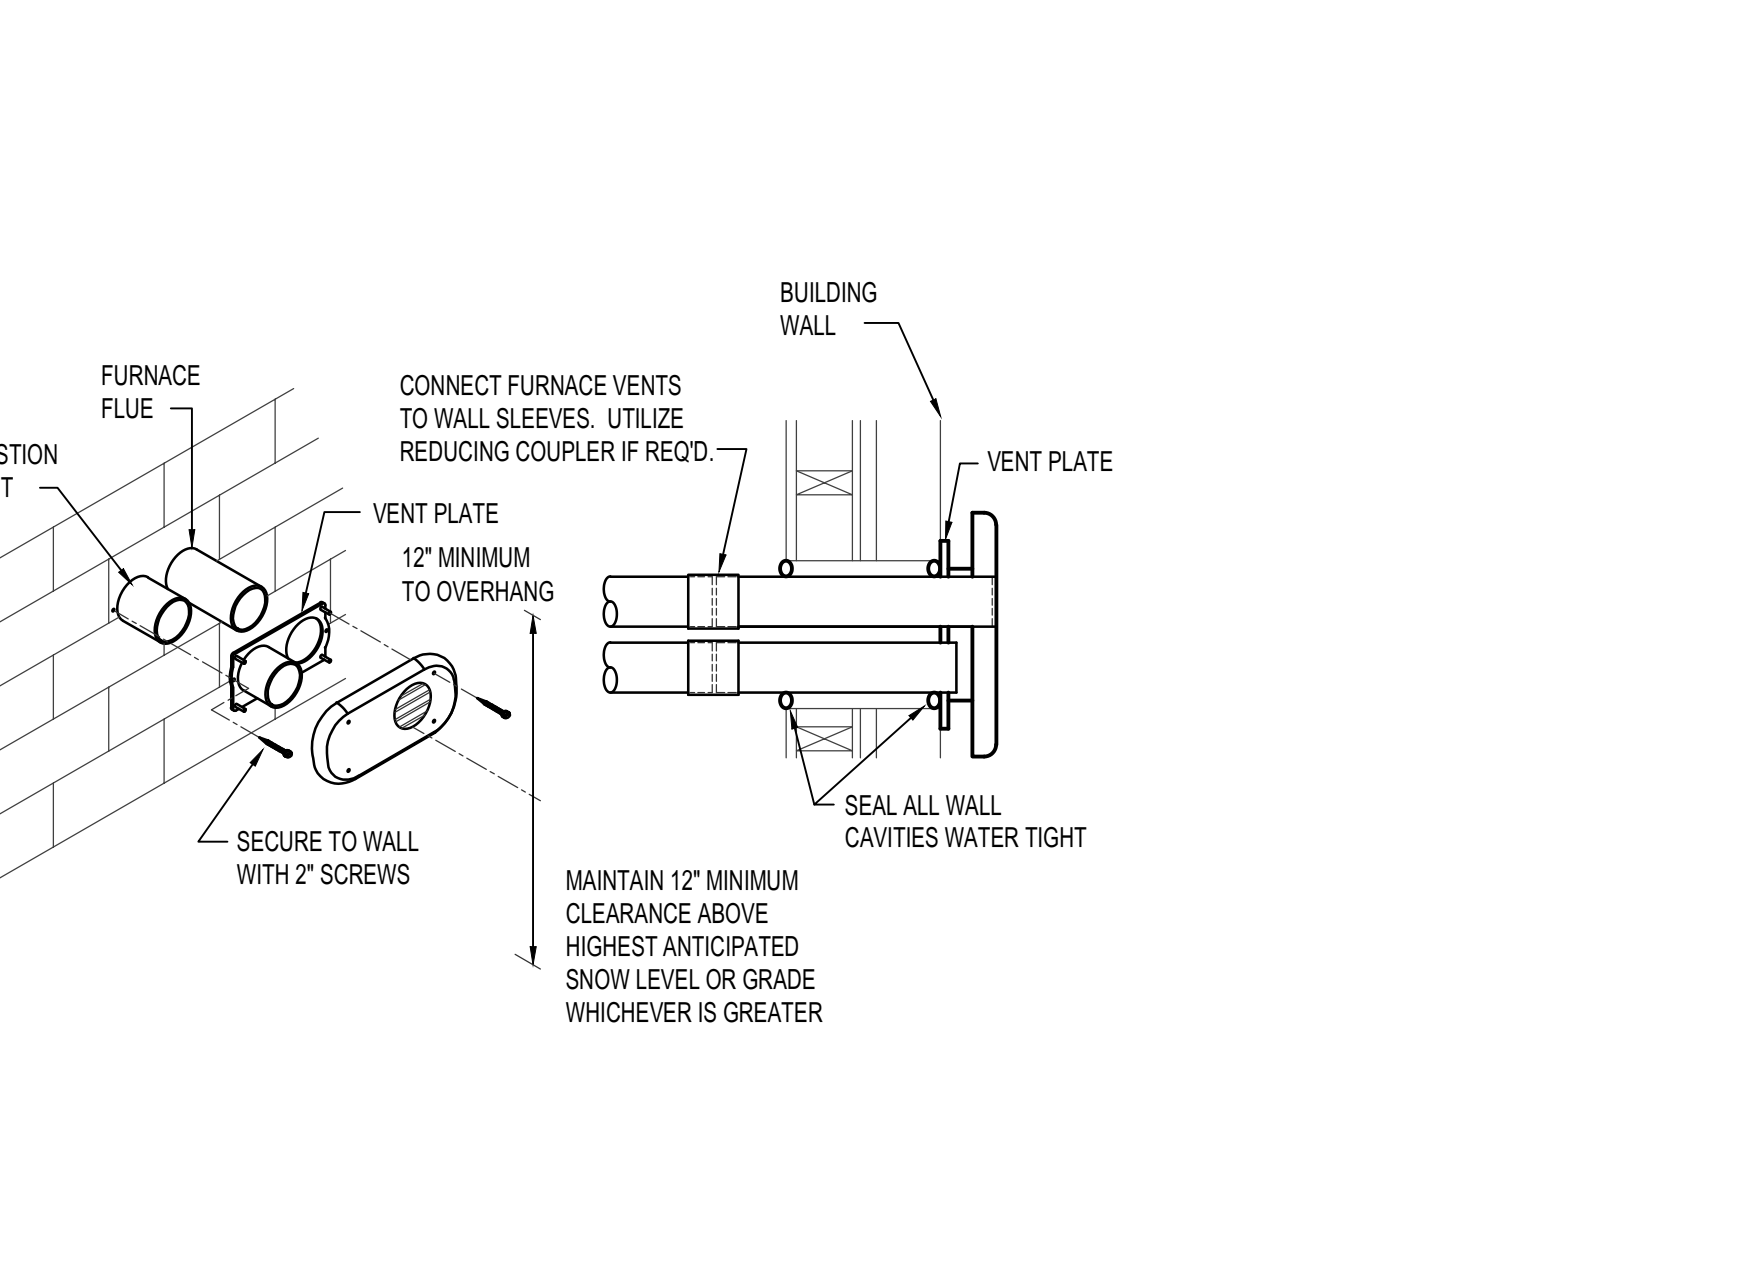

R DISHWASHER HOOD DETAIL NO SCALE

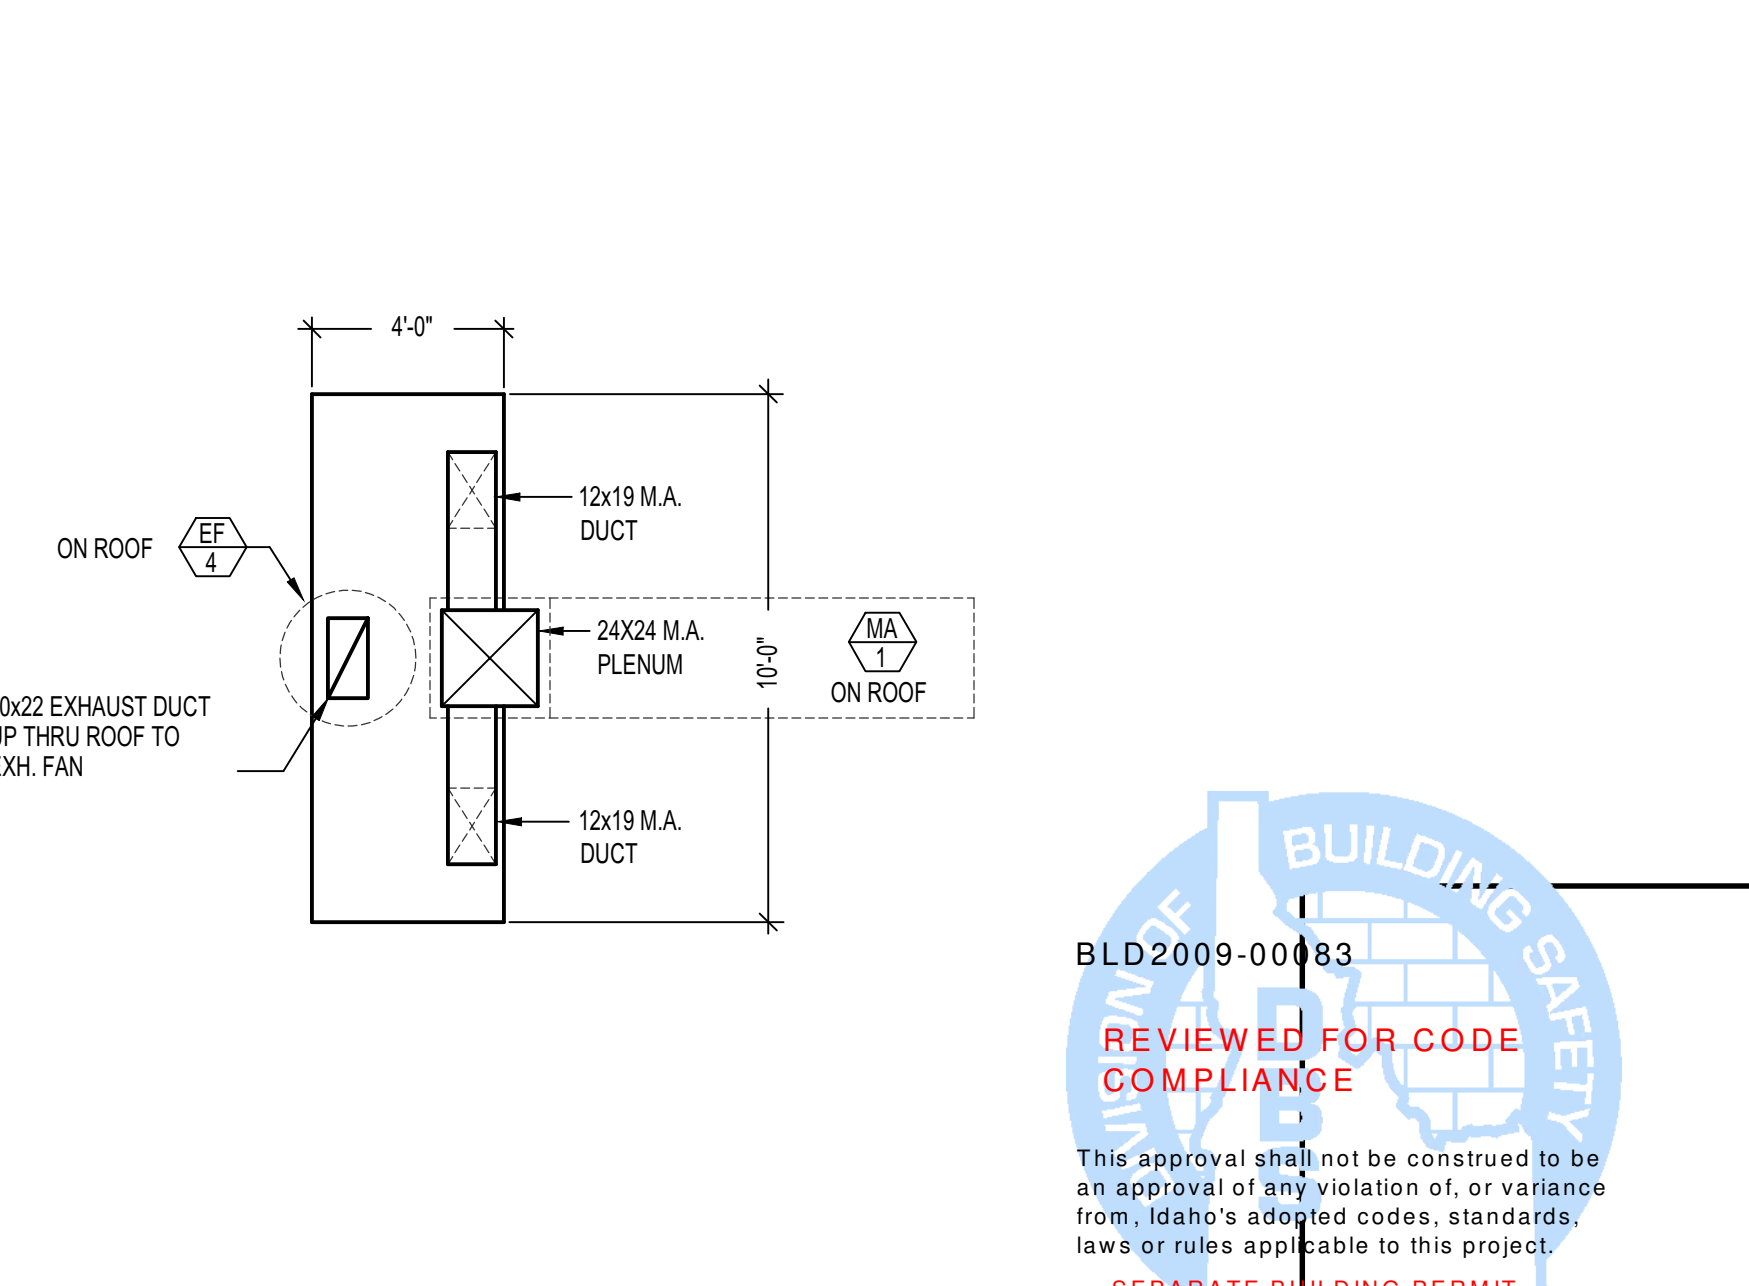

W KITCHEN HOOD DETAIL NO SCALE

Myers Anderson
 Architecture
 Interior Design
 Historic Preservation

122 South Main Street • Pocatello, Idaho 83201 • Tel: (208) 233-3114 • Fax: (208) 232-3702
 227 Appleton Street, Suite 201 • Pocatello, Wyoming 82401 • Tel: (307) 239-0244

BID SET
3-22-2021

Professional Engineer
 Registered
 State of Idaho
 License No. 15000
 Date: Jan 29, 2021

Engineered Systems Associates
 1355 EAST CENTER
 POCATELLO, IDAHO 83201
 PHONE: (208) 233-0501
 FAX: (208) 233-0529
 EMAIL: esa@engsys.com
 ESA JOB NUMBER: 18093

DPW PROJECT NO. 19240
IDAHO STATE UNIVERSITY
ALUMNI & VISITOR CENTER
POCATELLO, IDAHO

MECHANICAL DETAILS AND DIAGRAMS

CONTRACTOR SHALL VERIFY ALL DIMENSIONS & CONDITIONS SHOWN OR IMPLIED.
 DRAWING SCALE APPLIES TO 3/4" X 4 1/4" SHEET (SEE ARCH. PLAN).
 REVISION DATE

REVIEWED FOR BUILDING PERMIT COMPLIANCE
 BLD2009-00483

APPROVED FOR CONSTRUCTION

DRAWN BY: M. JENSEN
 CHECKED BY: D. SUDWICKS
 JOB NUMBER: 96548-13B
 PROJECT DATE: FEBRUARY 2021
 SHEET **M301** 4 OF 5