


- PLAN NOTES:**
- 1 DROP DUCTWORK DOWN IN CHASE TO SERVE LOWER LEVEL BELOW. SEE SHEET M-1 FOR CONTINUATION OF DUCTWORK.
 - 2 RUN DUCTWORK SERVING LOWER LEVEL AS HIGH AS POSSIBLE IN BETWEEN WEB OF ROOF JOISTS AND PARALLEL WITH JOISTS TO AVOID CONFLICT WITH DUCTWORK SERVING SECOND LEVEL.
 - 3 INSTALL UL RATED SMOKE DETECTOR IN RETURN AIR DUCT FOR EMERGENCY FAN SHUT-DOWN. INTERLOCK WITH UNIT.

LICENSED ARCHITECT AR-2650
 MARLA R. MORGAN
 STATE OF IDAHO

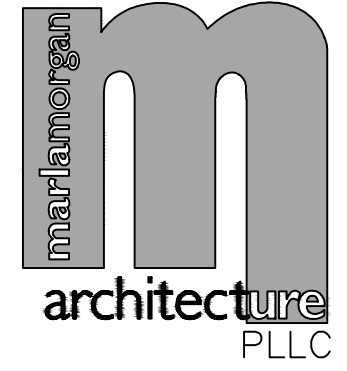

MARLA MORGAN, Architect
 Ph: 208.270.2244
 E-MAIL: morganmrm@cableone.net


OWNER: **Dr. Deirdre Conway**
IDAHO FERTILITY CENTER
 535 West Sunnyside Road Idaho Falls, ID 83402

SHEET CONTENTS

SECOND FLOOR MECHANICAL PLAN


REVISIONS	DATE	DESCRIPTION

SHEET NUMBER
M-2 OF 3

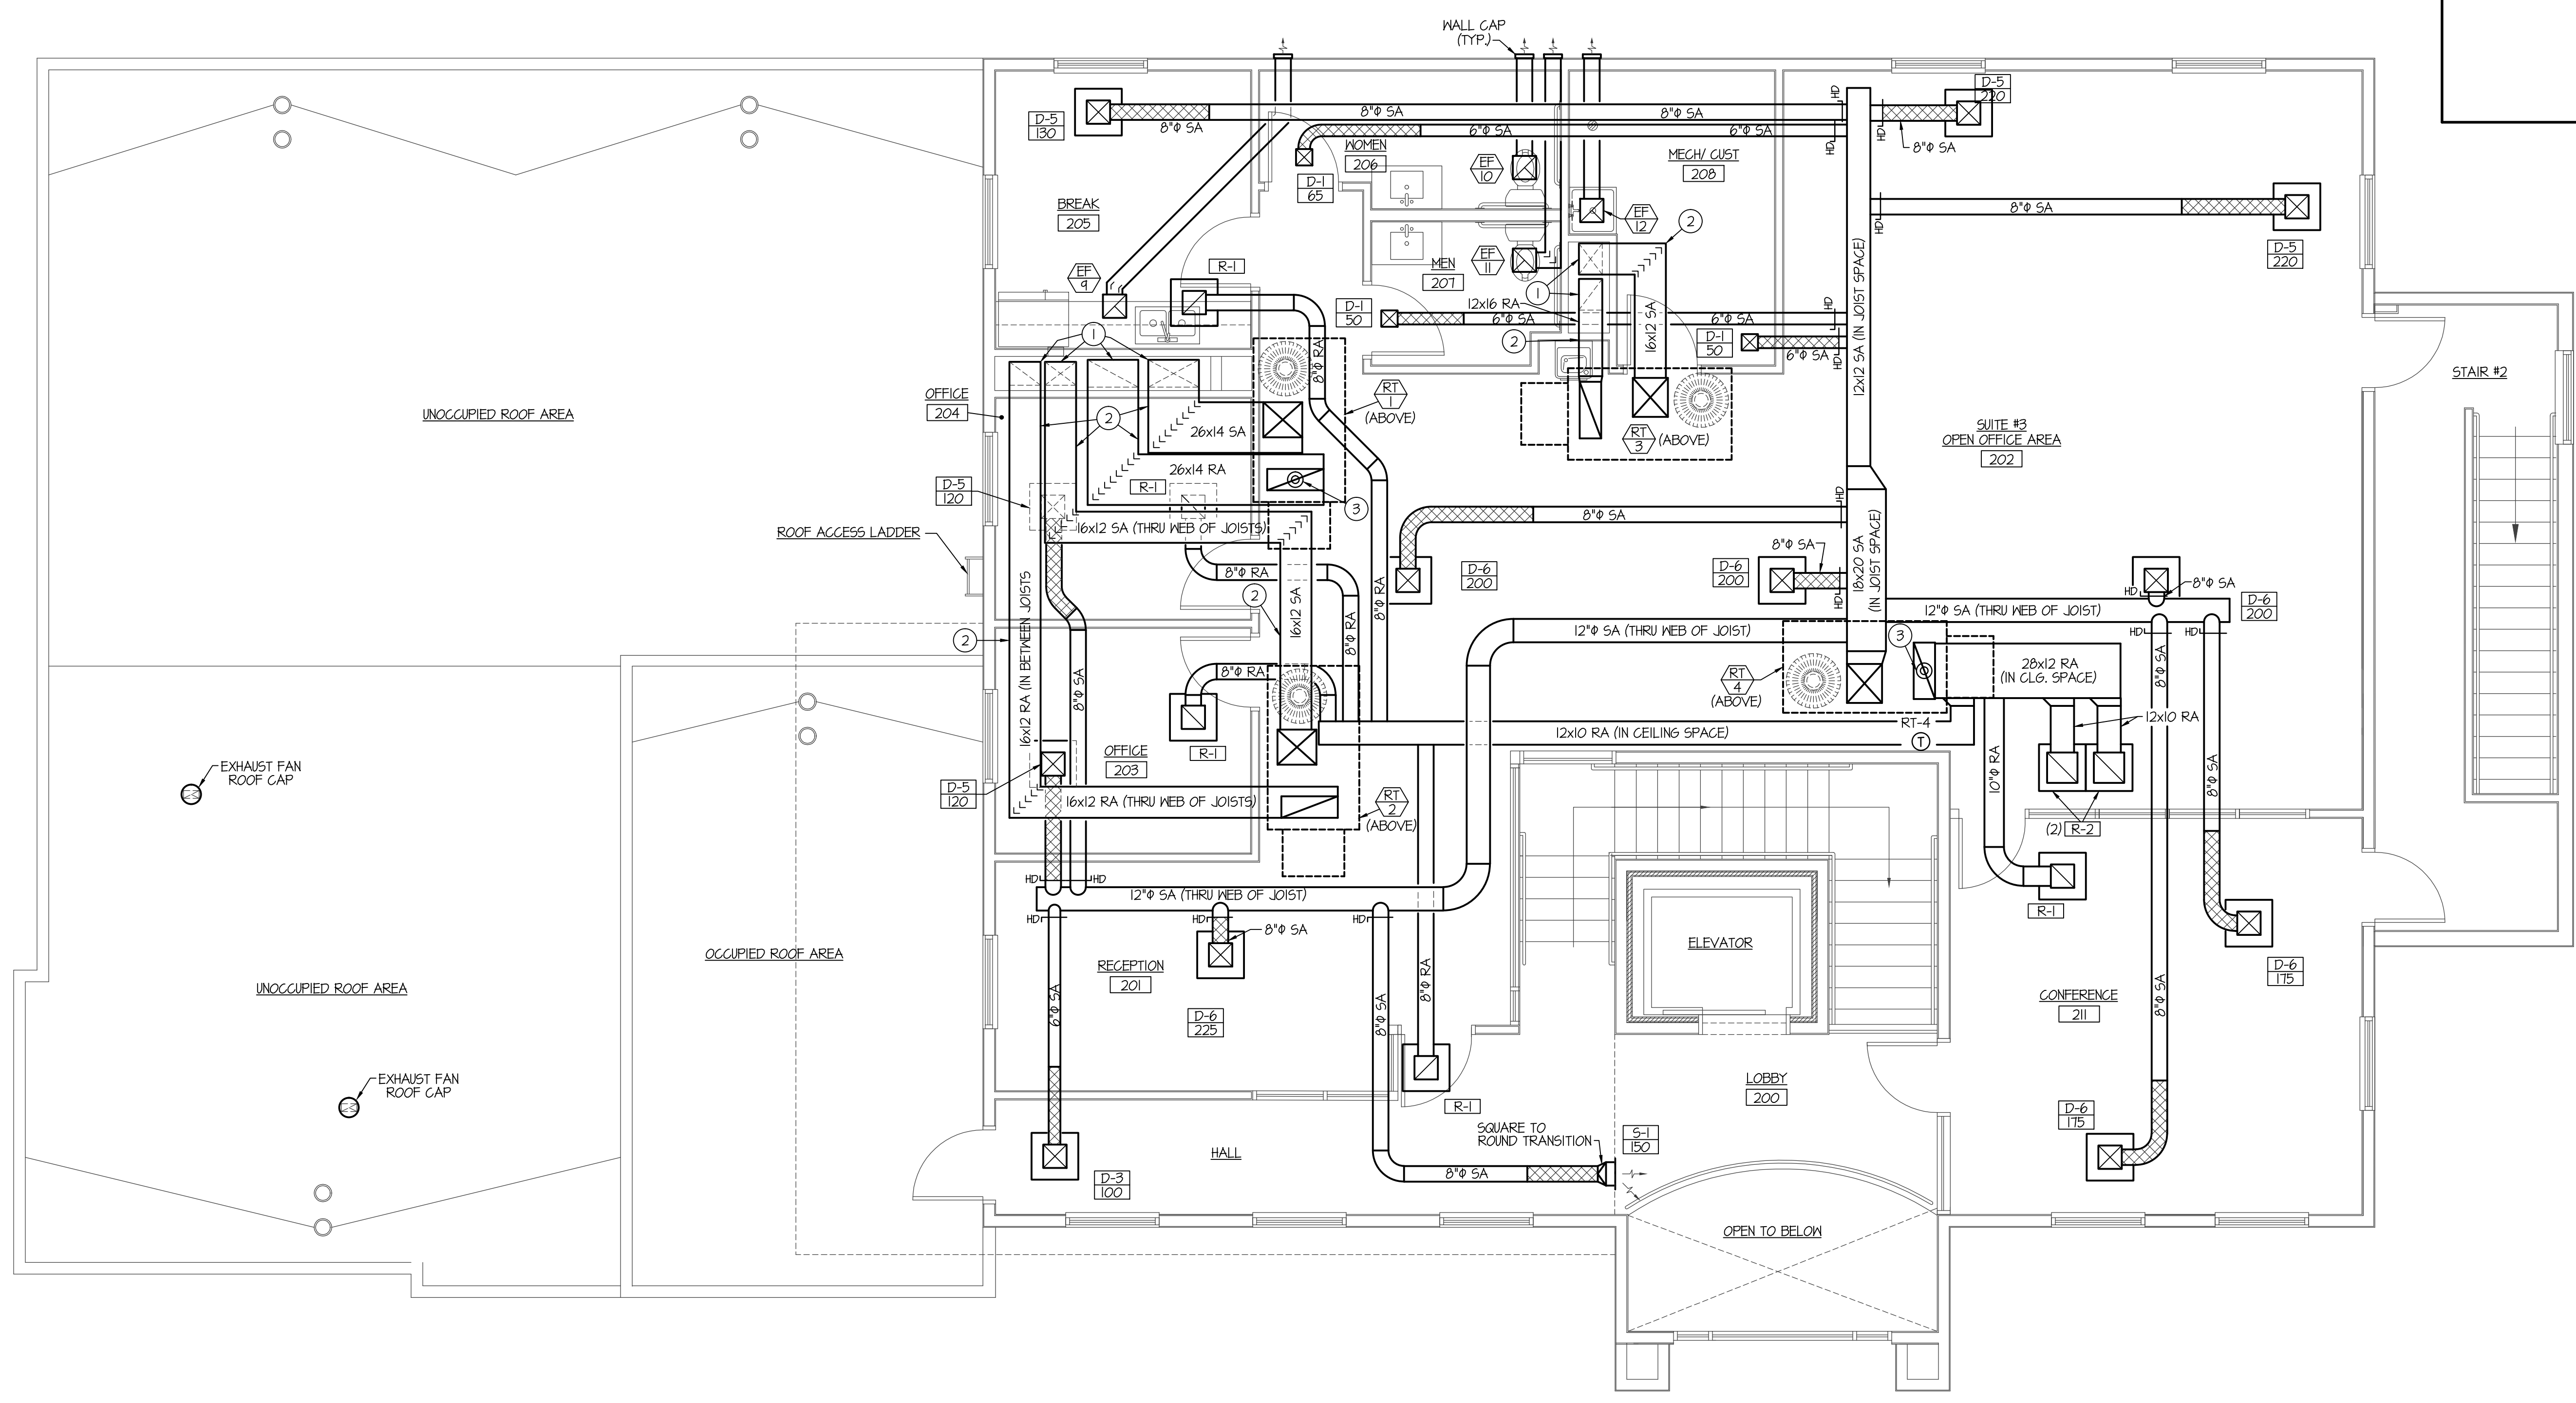

SECOND FLOOR MECHANICAL PLAN
 SCALE: 1/4" = 1'-0" 

ORIGINAL DRAWING SIGNED BY: DWAYNE C. SUDWEEKS
 DATE ORIGINAL SIGNED: FEB. 26, 2019
 ORIGINAL ON FILE AT ENGINEERED SYSTEMS ASSOCIATES
 1355 EAST CENTER, POCA TELLO, IDAHO 83201

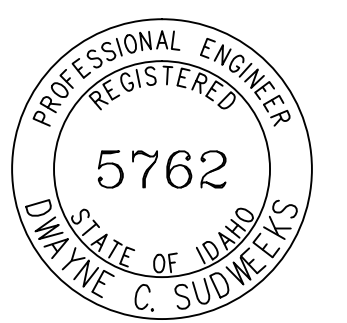

Engineered Systems Associates
 1355 EAST CENTER
 POCA TELLO, IDAHO 83201
 PHONE: (208) 233-0501
 FAX: (208) 233-0529
 EMAIL: eso@engsystems.com
 ESA JOB NUMBER: 18097