


PLAN NOTES:

- 1 SEE CIVIL SITE PLAN FOR CONTINUATION OF 4" WASTE LINE.
- 2 SEE CIVIL SITE PLAN FOR CONTINUATION OF 1-1/2" DOMESTIC COLD WATER MAIN.
- 3 GAS METER BY LOCAL GAS COMPANY SIZED FOR 242,000 BTU AT 2 PSI DELIVERY PRESSURE.
- 4 RISE 1-1/2" DOMESTIC CW MAIN UP THRU SLAB INTO JANITOR ROOM TO PRESSURE REDUCING STATION. SEE DETAIL ON SHEET P200.
- 5 1-1/4" LAWN SPRINKLER STUB. SEE WATER PRESSURE REDUCING STATION DETAIL ON SHEET P200.
- 6 RUN DOMESTIC CW AND GAS PIPING EXPOSED ON CEILING AS HIGH AS POSSIBLE.
- 7 TYPICAL ISOLATION BALL VALVE.
- 8 DROP 3/4" (2 PSI) GAS LINE DOWN FROM CEILING AND CONNECT TO FURNACE. INSTALL 2 PSI TO OZ. REGULATOR SIZED FOR ACTUAL BTU LOAD OF FURNACE PROVIDED. CONNECT 3/4" (OZ.) GAS LINE TO FURNACE COMPLETE WITH SHUT-OFF VALVE, FLEXIBLE CONNECTION AND DIRT LEG. SEE DETAIL ON SHEET P200.
- 9 INSTALL PLUMBING VTR NEAR PEAK OF METAL ROOF TO PREVENT SNOW SHEAR. SEAL ROOF PENETRATION WEATHERTIGHT.

PLUMBING LEGEND	
SYMBOL	DESCRIPTION
V	VENT
VTR	VENT THRU ROOF
CO	CLEANOUT
WCO	WALL CLEANOUT
COTG	CLEANOUT TO GRADE
—	PIPE DROP
—	PIPE RISE
—	BALL TYPE ISOLATION VALVE
—	SOIL OR WASTE PIPING
—	CONDENSATE DRAIN PIPING
—	VENT LINE PIPING
—	DOMESTIC SOFT COLD WATER
—	DOMESTIC HOT WATER PIPING
—	HOT WATER REIRC. PIPING
—	NATURAL GAS PIPING

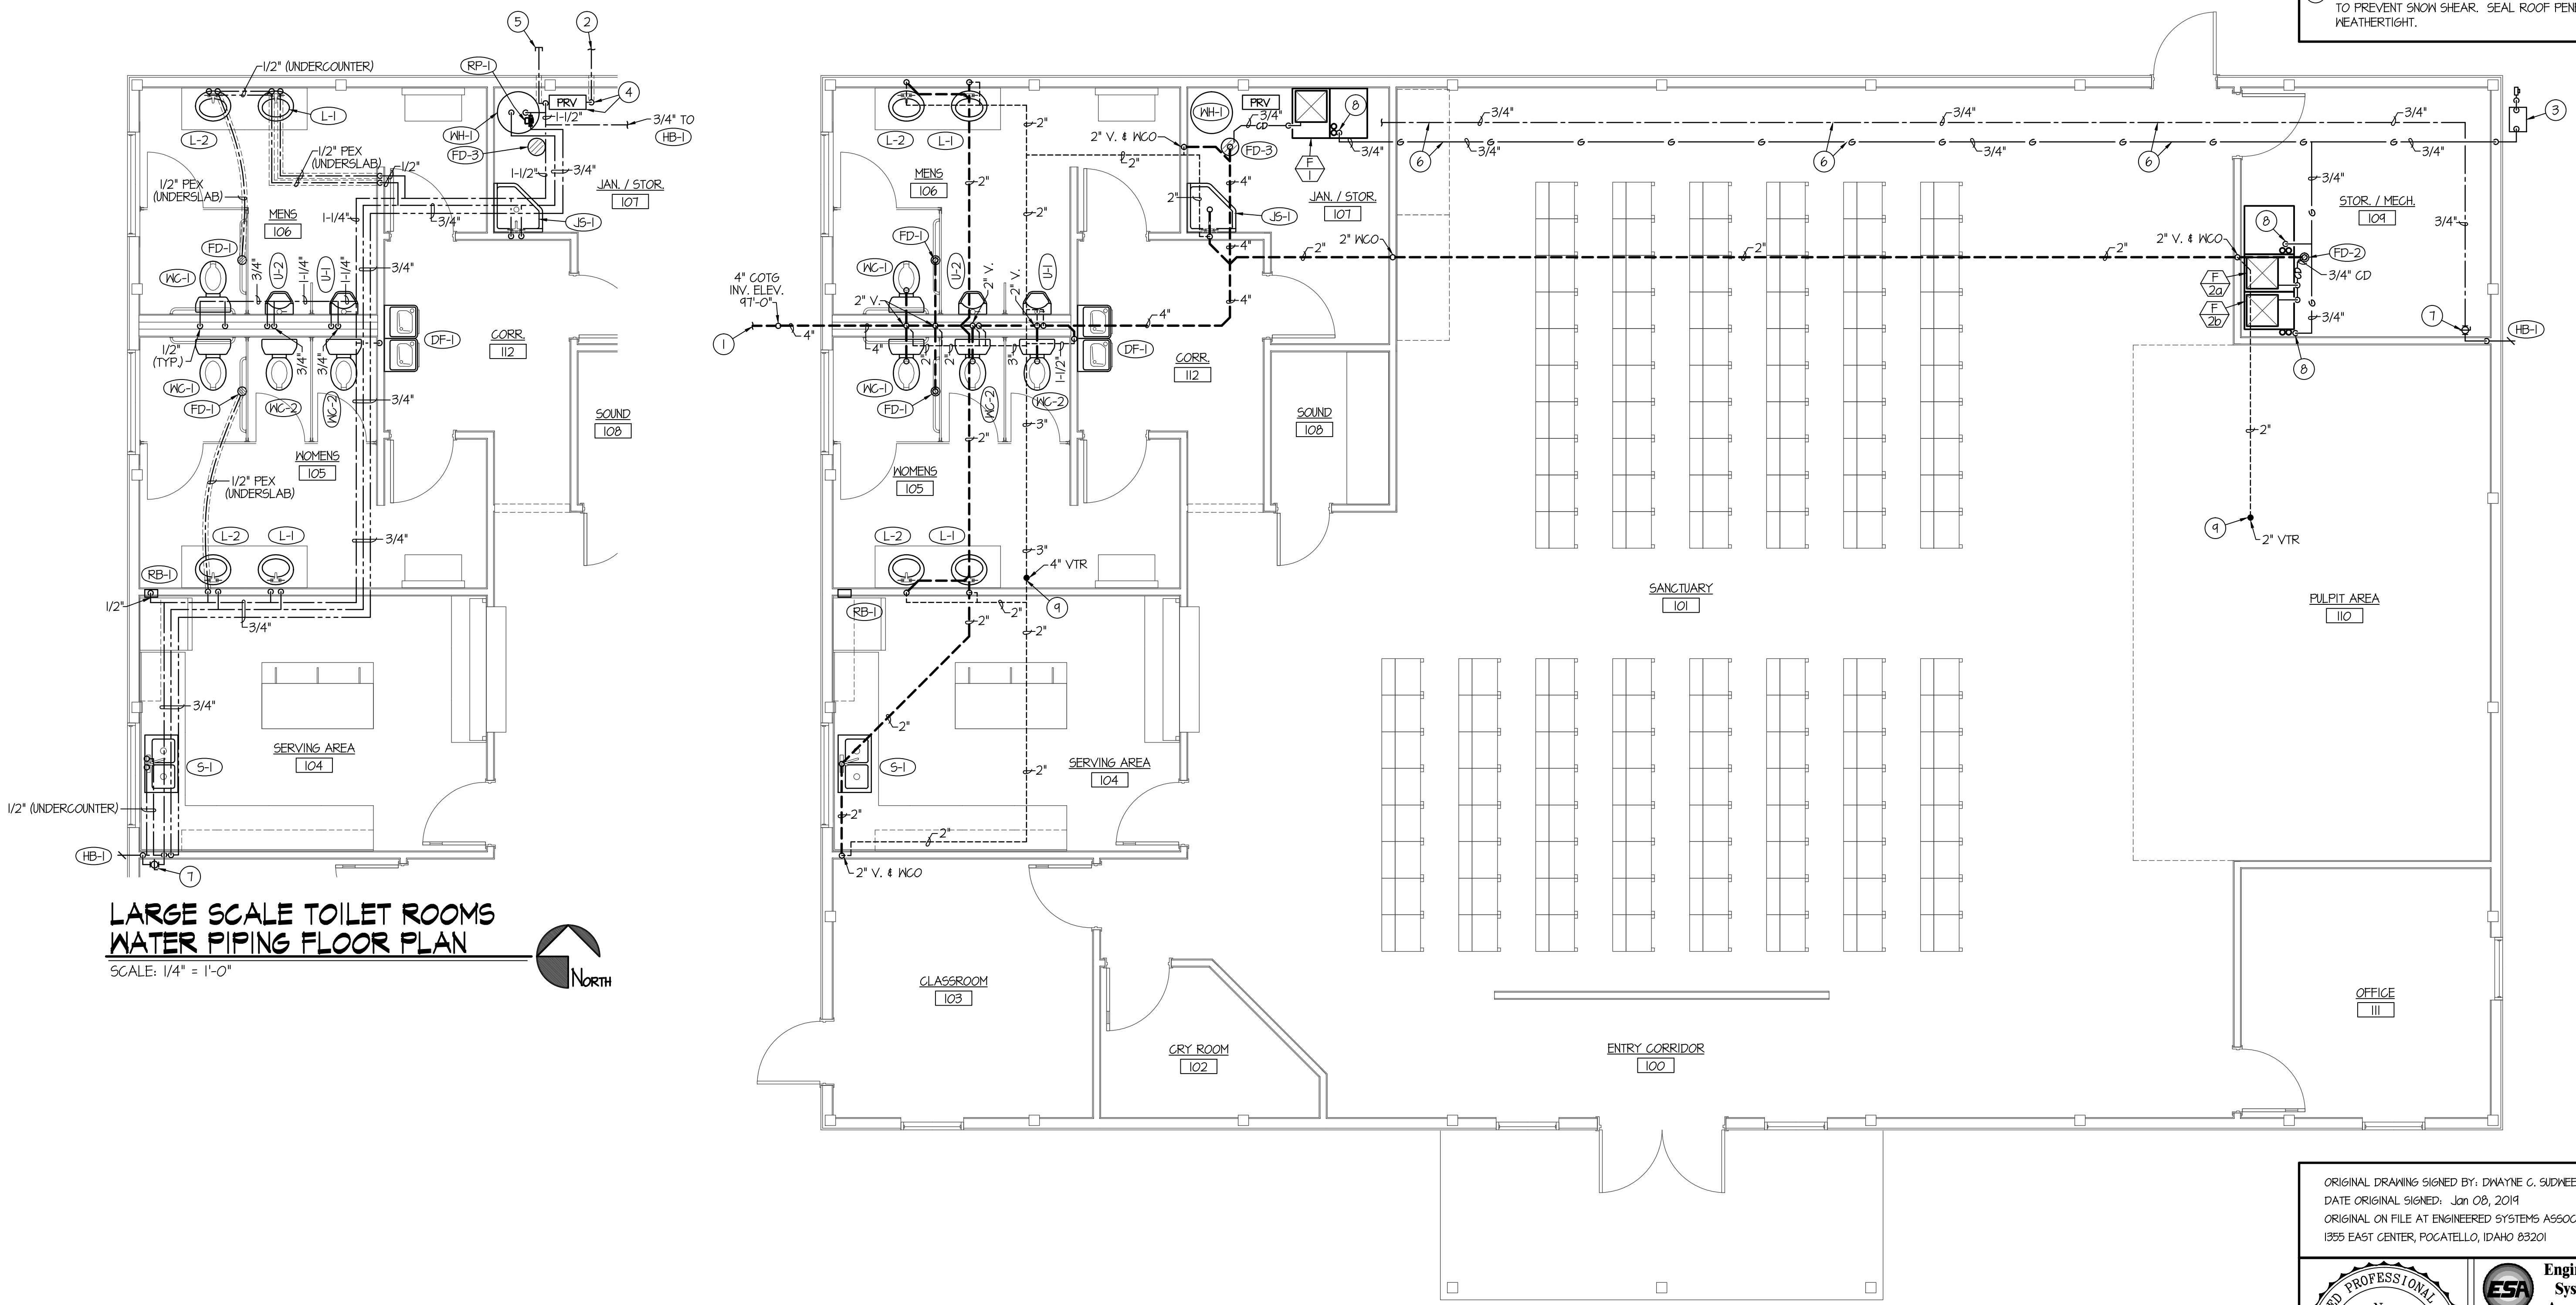

LARGE SCALE TOILET ROOMS WATER PIPING FLOOR PLAN

SCALE: 1/4" = 1'-0"




FLOOR PLAN - PLUMBING

SCALE: 1/4" = 1'-0"



ORIGINAL DRAWING SIGNED BY: DWAYNE C. SUDWEEKS
 DATE ORIGINAL SIGNED: Jan 08, 2019
 ORIGINAL ON FILE AT ENGINEERED SYSTEMS ASSOCIATES
 1355 EAST CENTER, POCATELLO, IDAHO 83201

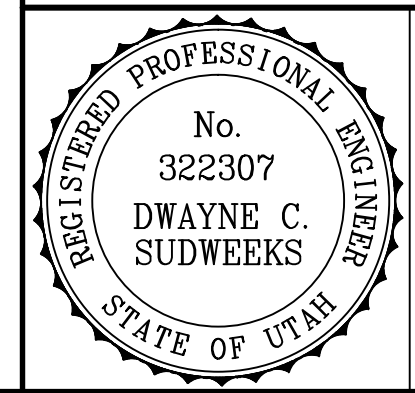

Engineered Systems Associates
 1355 EAST CENTER
 POCATELLO, IDAHO 83201
 PHONE: (208) 233-0501
 FAX: (208) 233-0529
 EMAIL: esa@engsystems.com
 ESA JOB NUMBER: 18102

PLUMBING FLOOR PLANS

SHEET NUMBER:

P100

DO NOT SCALE DRAWING

New Tenant Improvement For:
WASATCH COWBOY CHURCH
 5603 SOUTH 6700 WEST
 HOOPER, UT 84315

PROJECT:

SEAL:

REV	DATE	DESCRIPTION