


**PLAN NOTES:**

- 1 RISE 6" FIRE LINE UP THRU SLAB INTO RISER ROOM TO 6" FIRE RISER ASSEMBLY. SEE DETAIL ON SHEET P300.
- 2 RISE 2" DOMESTIC CW MAIN UP THRU SLAB INTO RISER ROOM TO WATER PRESSURE REDUCING STATION. SEE DETAIL ON SHEET P300.
- 3 SEE CIVIL SITE PLAN FOR CONTINUATION OF PIPING.
- 4 INSTALL FIRE SPRINKLER PIPING AND HEADS AS PER NFPA 13 CODE REQUIREMENTS THROUGHOUT ENTIRE BUILDING.
- 5 RISE NEW 2" CW MAIN FROM RISER ROOM AND RUN PIPING AS HIGH AS POSSIBLE AT OPEN ROOF STRUCTURE ABOVE. SEE SHEET P102 FOR CONTINUATION OF PIPING.
- 6 6" ROOF DRAIN AND 6" ROOF OVERFLOW DRAIN PIPING DN. FROM ABOVE. SEE SHEET P102 FOR CONTINUATION OF PIPING.
- 7 RISE 2" (2 PSI) GAS LINE UP EXPOSED TO CEILING OF UPPER LEVEL. SEE SHEET P102 FOR CONTINUATION OF PIPING.
- 8 GAS METER BY LOCAL GAS COMPANY SIZED FOR 4,214,900 BTU LOAD AT 2 PSI DELIVERY PRESSURE.


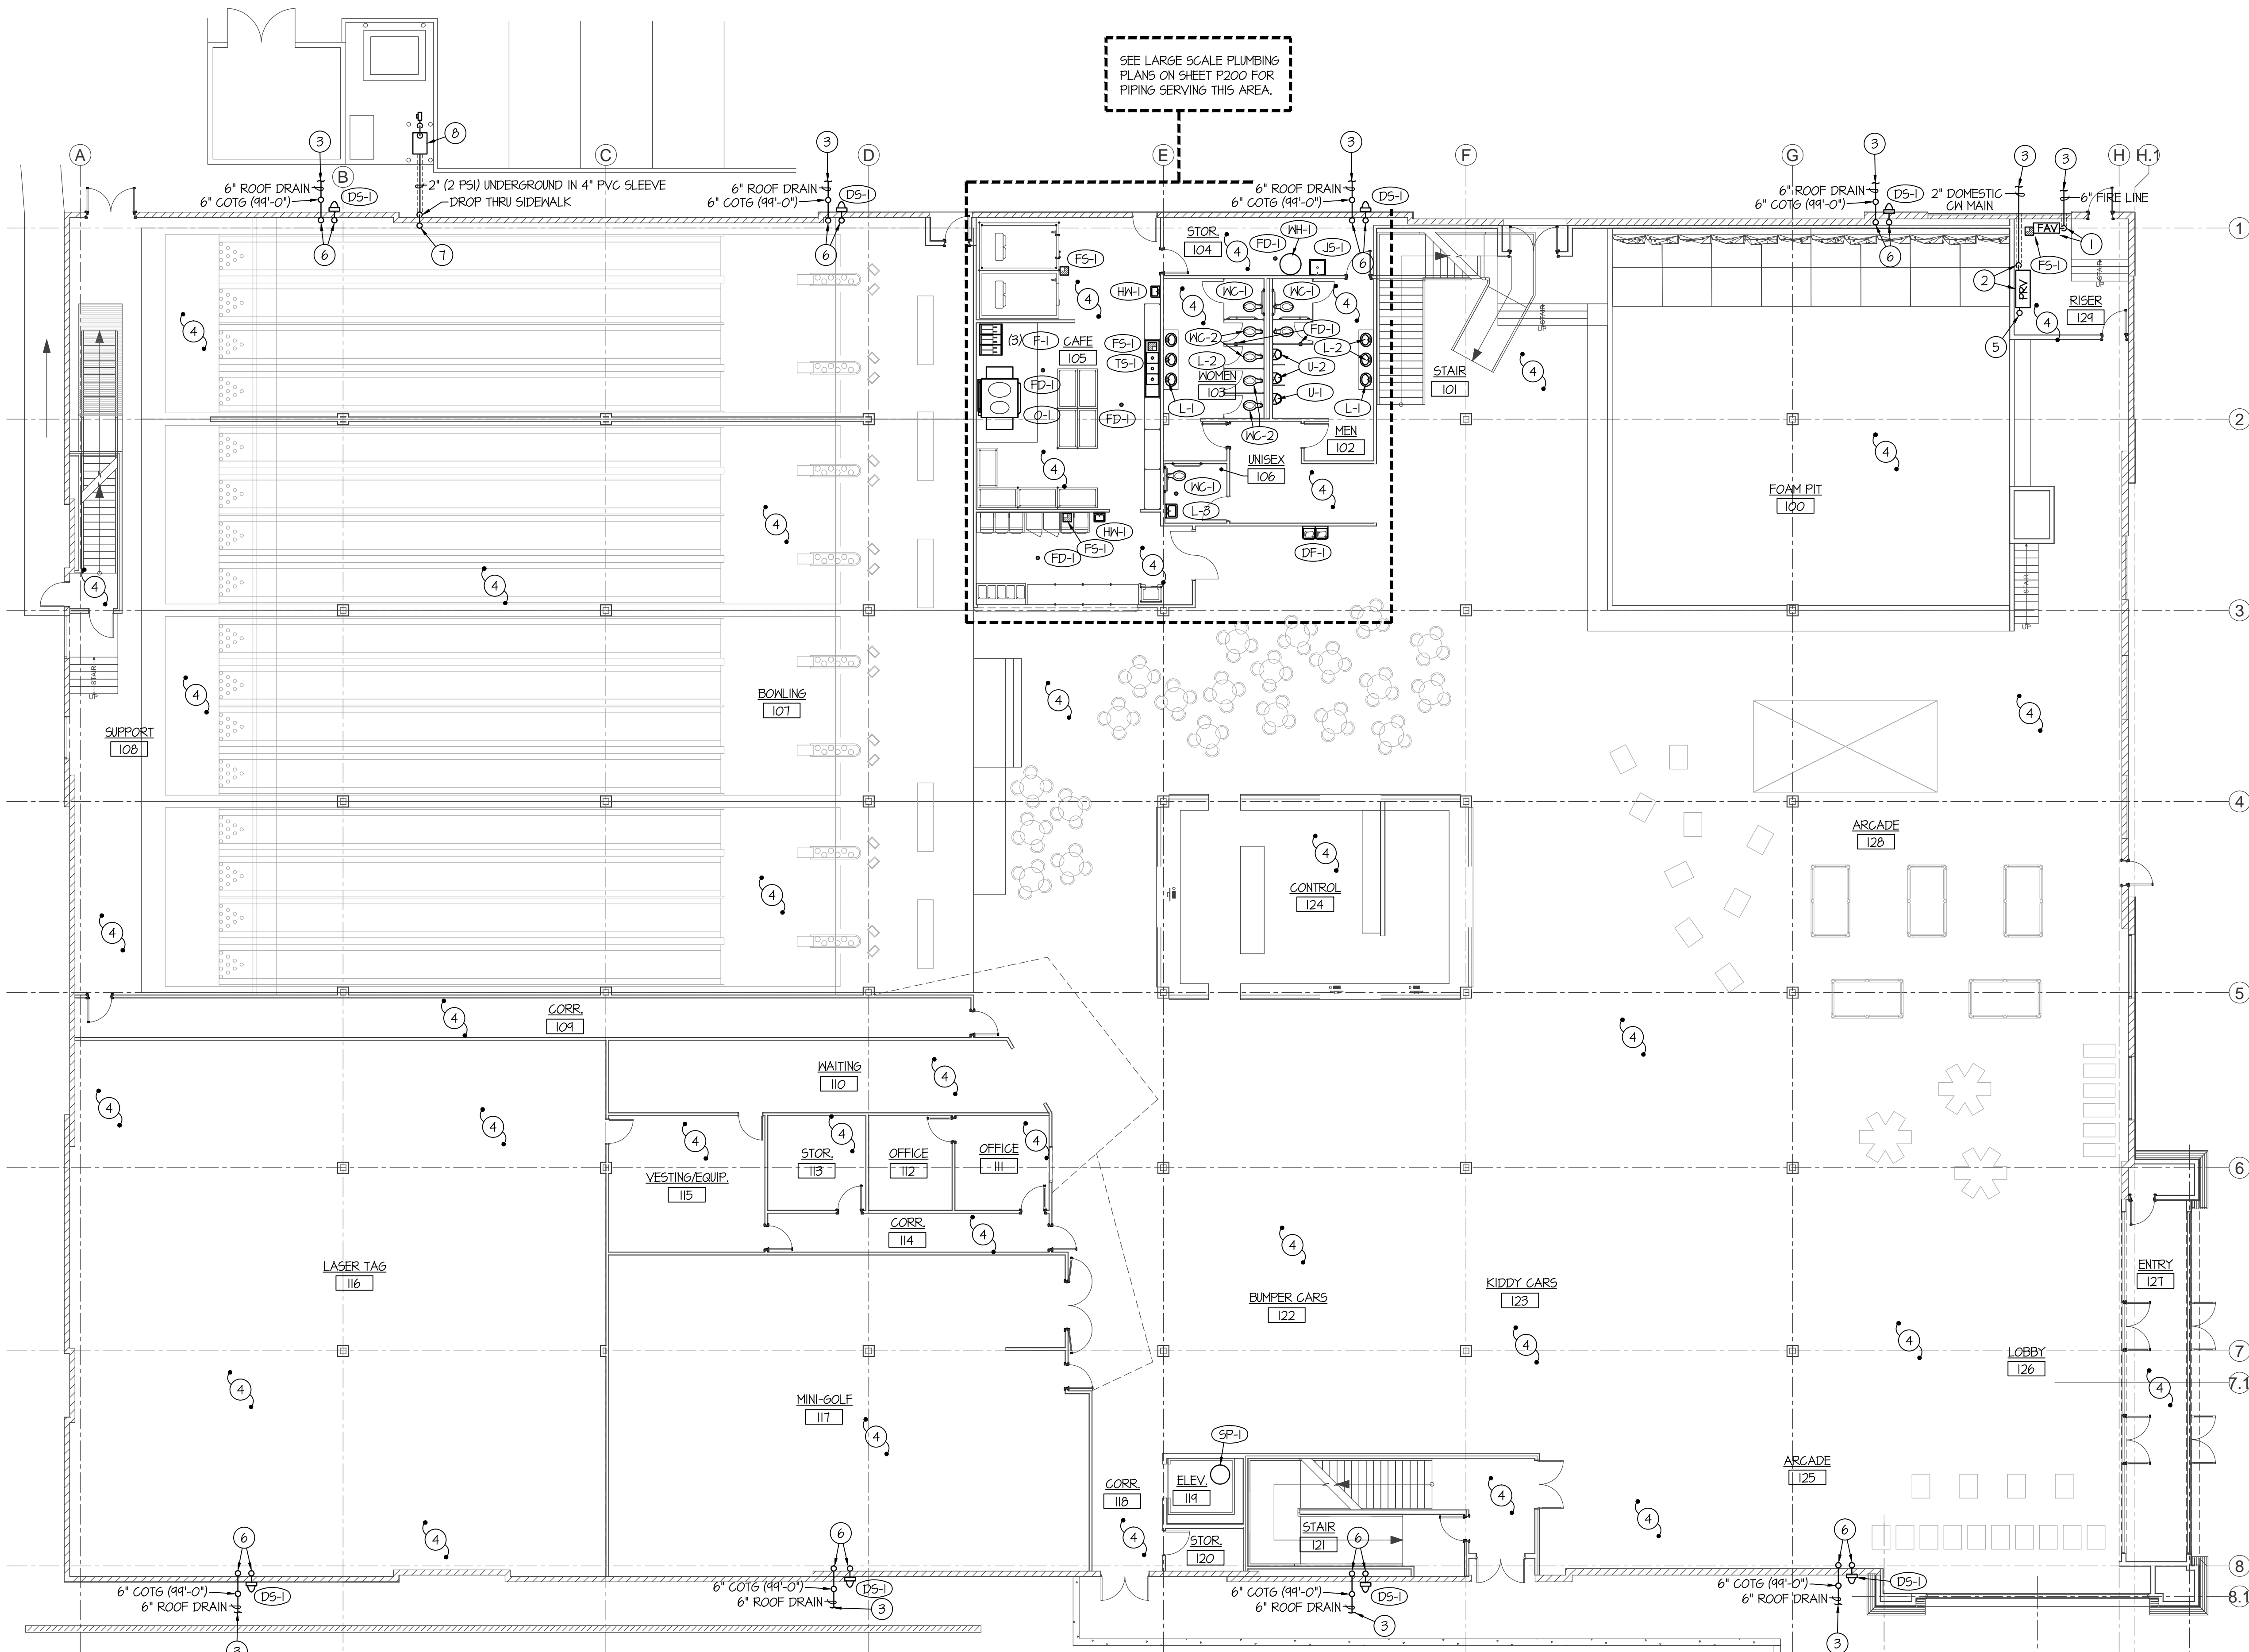


SEE LARGE SCALE PLUMBING PLANS ON SHEET P200 FOR PIPING SERVING THIS AREA.

**PLUMBING LEGEND**

SYMBOL	DESCRIPTION
V	VENT
VTR	VENT THRU ROOF
CO	CLEANOUT
WCO	WALL CLEANOUT
COTG	CLEANOUT TO GRADE
—○—	PIPE DROP
—○—	PIPE RISE
—○—	BALL TYPE ISOLATION VALVE
---	SOIL OR WASTE PIPING
---	GREASE WASTE PIPING
---	VENT LINE PIPING
---	DOMESTIC SOFT COLD WATER
---	DOMESTIC HOT WATER PIPING
---	DOMESTIC HOT WATER REGIRC.
REL	ROOF DRAIN PIPING
RDO	ROOF OVERFLOW DRAIN PIPING
○	NATURAL GAS PIPING

**PLUMBING FLOOR PLAN**  
SCALE: 3/32" = 1'-0"

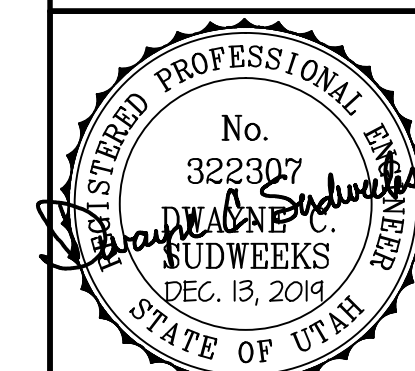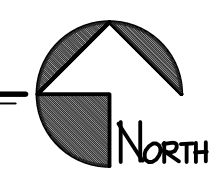

**Engineered Systems Associates**  
1355 EAST CENTER  
POCATELLO, IDAHO 83201  
PHONE: (208) 233-0501  
FAX: (208) 233-0529  
EMAIL: esa@engsystems.com  
ESA JOB NUMBER: 19014

SHEET TITLE:  
**MAIN LEVEL PLUMBING FLOOR PLAN**

SHEET NUMBER:  
**P101**

DO NOT SCALE DRAWING

PROJECT:  
New Building For:  
**THE RUSH FUNFLEX**  
JORDAN LANDING  
WEST JORDAN CITY, UTAH 84084

REV	DATE	DESCRIPTION

SEAL

MOUNTAIN WEST ARCHITECTURE 150 25TH STREET - OGDEN, UT 84401 | PH: 801-388-8052 | www.mountainwestarchitecture.com