

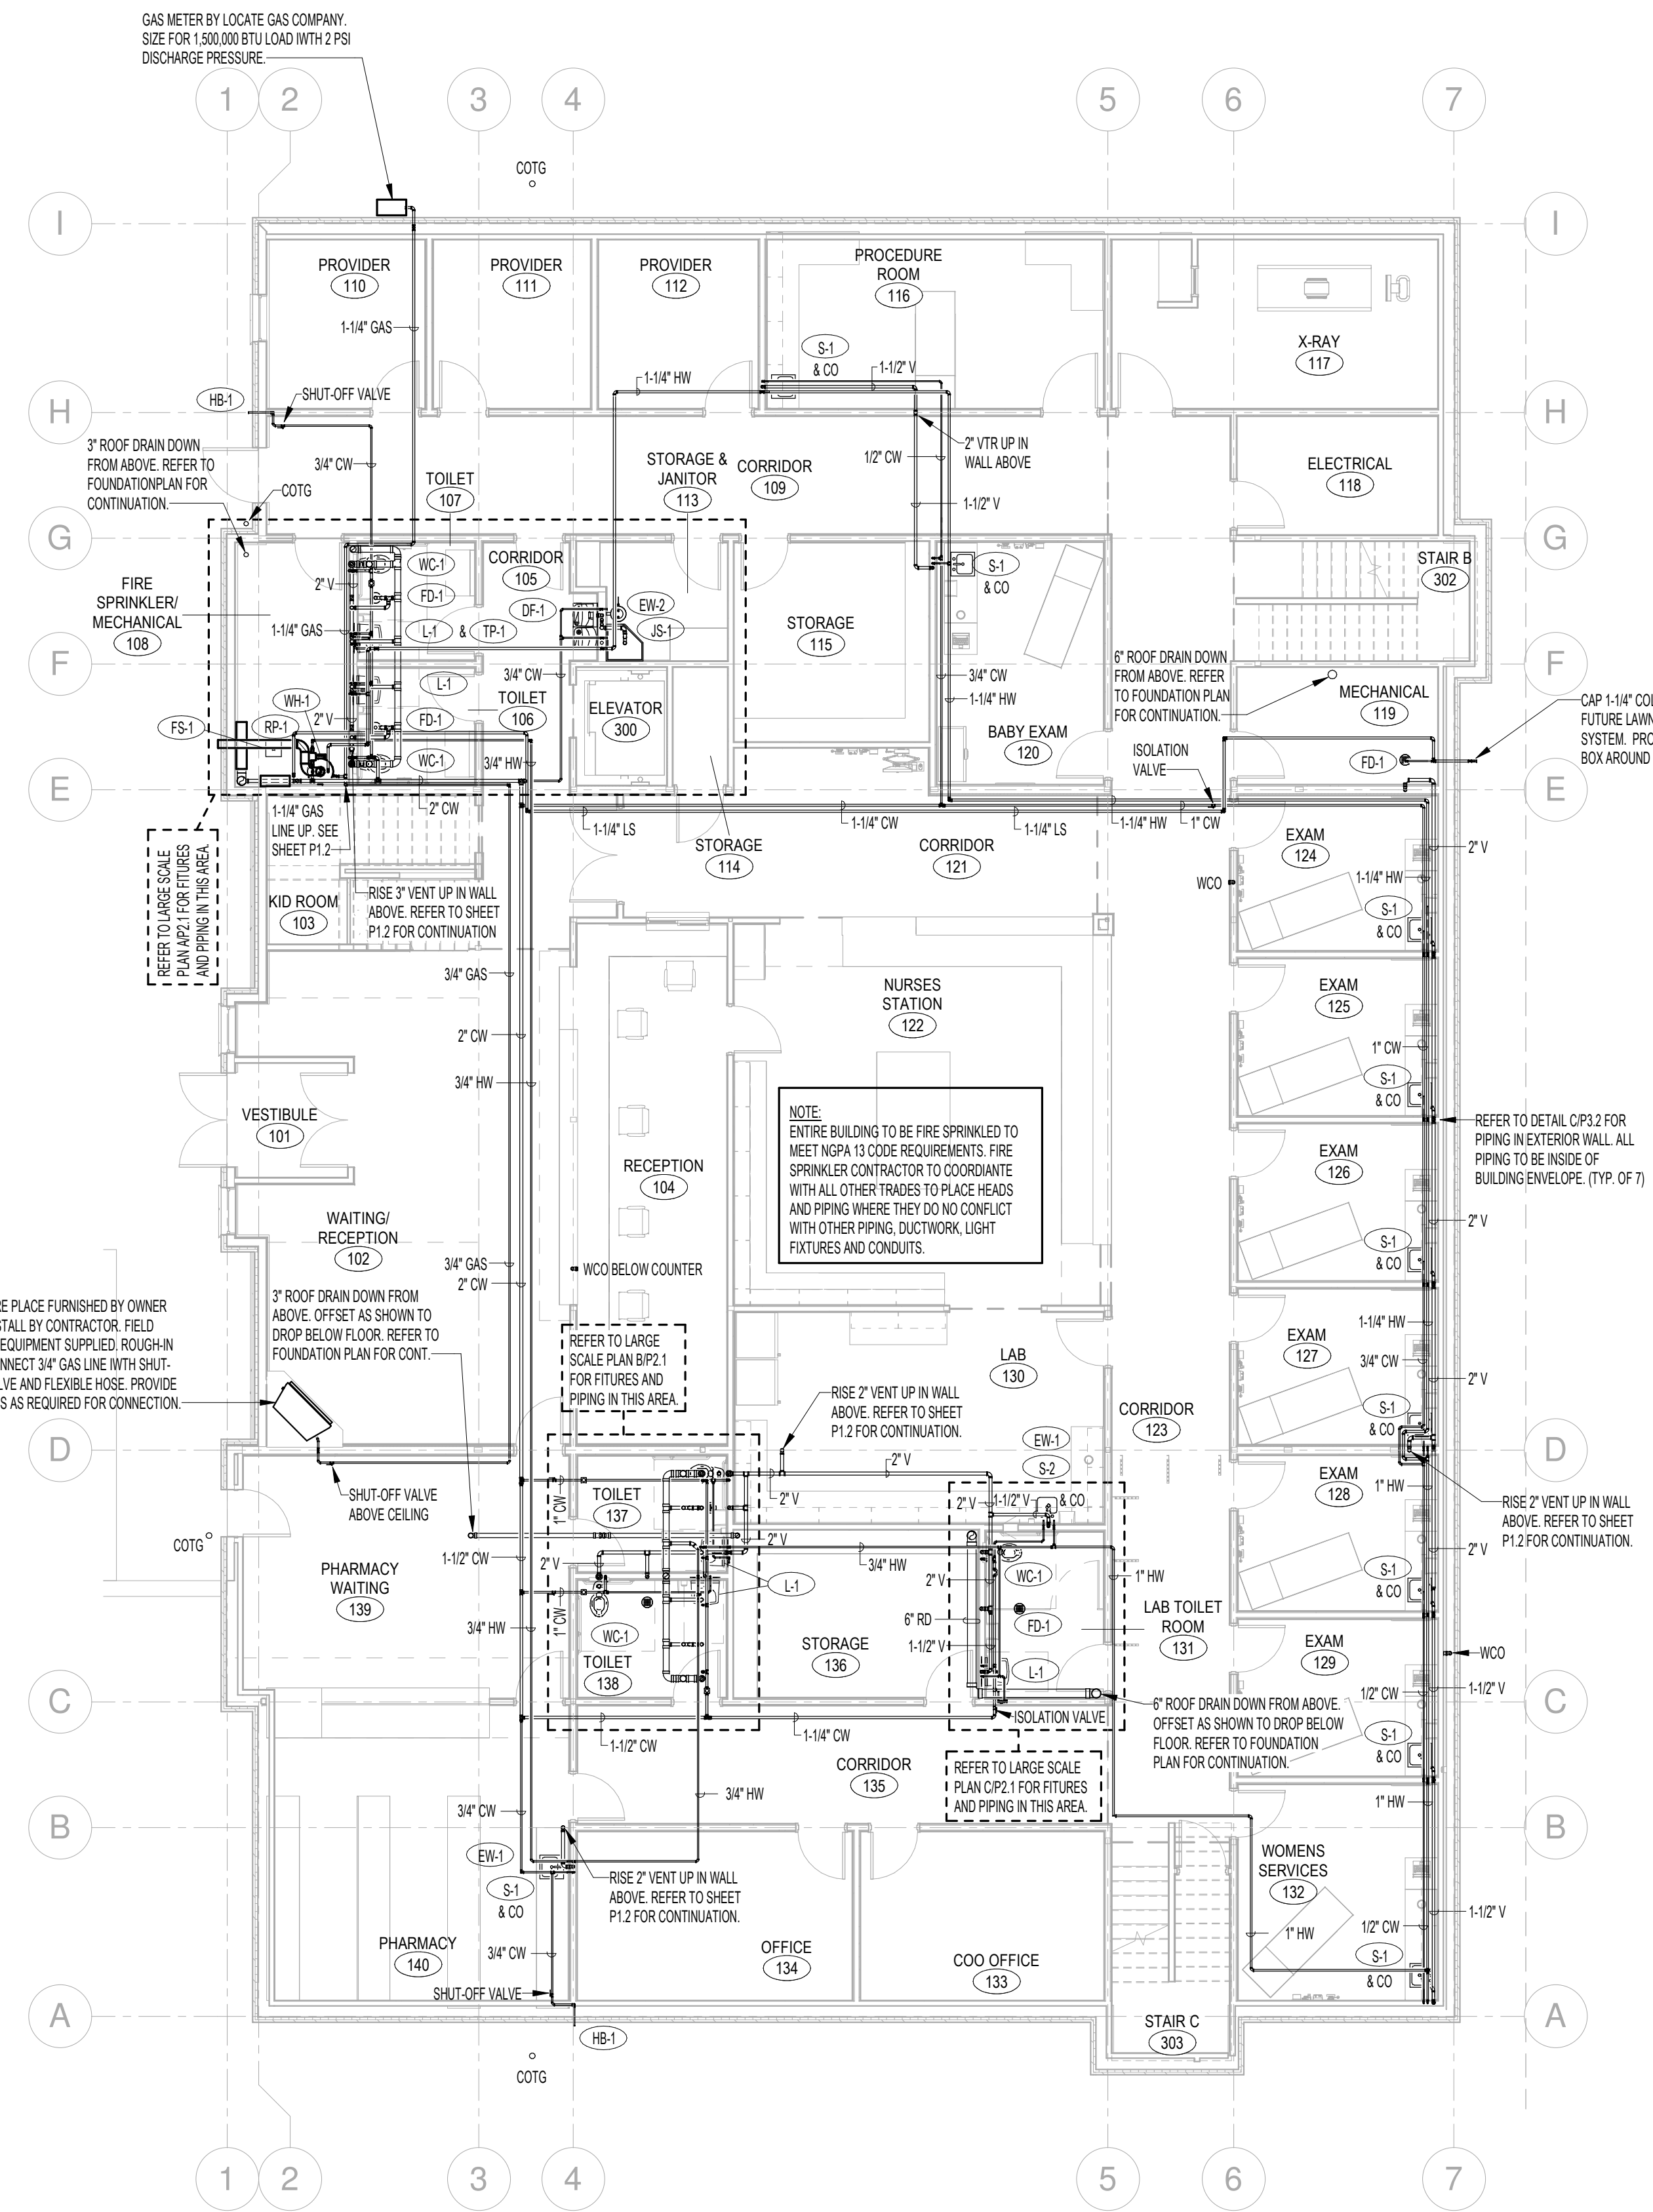
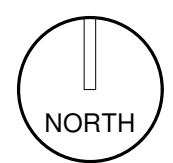


FOUNDATION PLUMBING PLAN
SCALE: 1/8" = 1'-0"

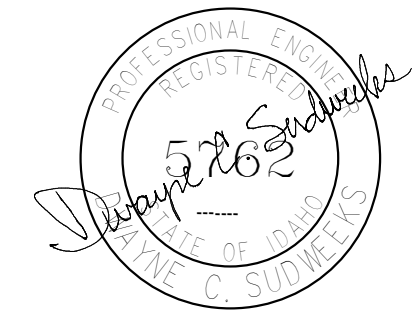

GROUND FLOOR PLUMBING PLAN
SCALE: 1/8" = 1'-0"

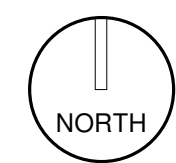

Ownership & Use of Documents
Drawings and specifications, as instruments of professional service are and shall remain the property of the architect. These documents are not to be used, in whole or in part for any project or purposes whatsoever, without the prior specific written authorization of GPC Architects PLLC.



GRAND PEAKS MEDICAL CLINIC
ST. ANTHONY, IDAHO



no.	description	date

project: 1804
date: 06/06/19

PLUMBING
FLOOR PLANS

sheet:
P1.1