



P-TAC SCHEDULE									
SYM.	SPEED	MCA	CHAR.	WEIGHT	DX COOLING		ELECTRIC HEAT		REMARKS
					B.T.U.	CFM	KW	CFM	
PC THRU PC 1B	HIGH	8.5	240/60/1	115 LBS	17,000	390	3.5	340	AMANA MODEL PTH153635A

ELECTRIC HEATER SCHEDULE						
SYM.	TYPE	BTU	KW	CHAR	CONTROL	REMARKS
EH 1	WALL MOUNTED	5110	1.5	240/60/1	INTEGRAL T-STAT	QMARK TYPE GRA2024-T2
EH 2	WALL MOUNTED	1280	.375	120/60/1	INTEGRAL T-STAT	QMARK TYPE GRA1512-T2


EXHAUST FAN SCHEDULE							
SYM.	TYPE	C.F.M.	S.P.E.	FLA	CHAR.	CONTROL	REMARKS
EF 1	CEILING	107	.25	1.5	120/60/1	WALL	CEILING MOUNTED EXHAUST FAN - AIRKING FRAS-100 WITH CEILING GRILLE, FIRE DAMPER, METAL DUCT COLLAR WITH BACK-DRAFT DAMPER AND EXTERIOR WALL CAP (TWIN CITY MODEL 641).
EF 2	CEILING	100	.25	1.5	120/60/1	WALL	CEILING MOUNTED EXHAUST FAN - BROAN MODEL AE50110DC WITH CEILING GRILLE, METAL DUCT COLLAR WITH BACK-DRAFT DAMPER AND ROOF CAP (TWIN CITY MODEL 634M).

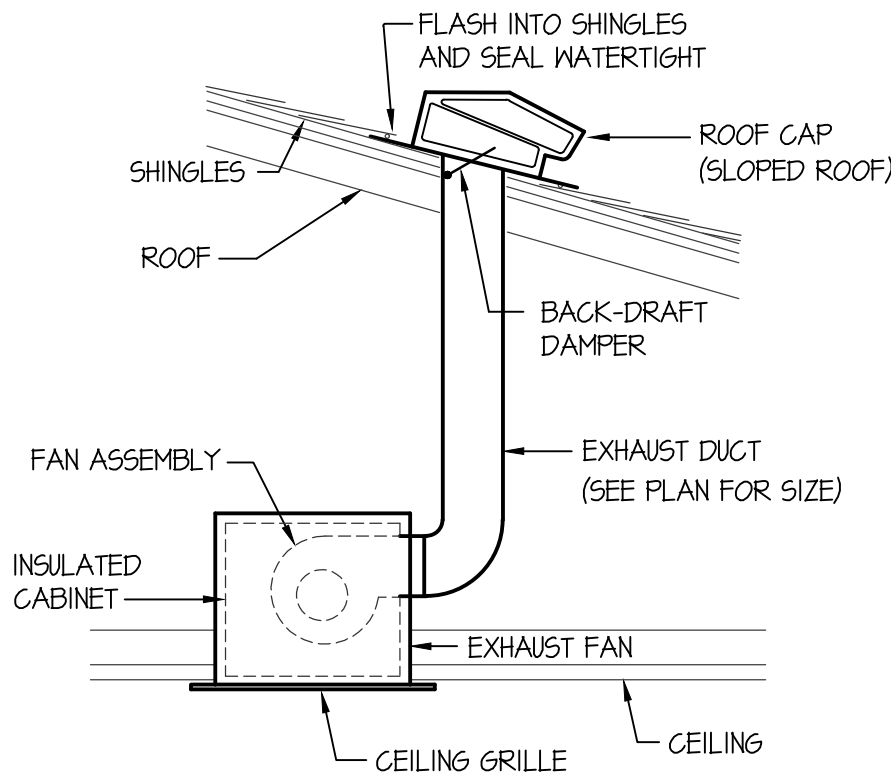


CEILING MOUNTED EXHAUST FAN DETAIL
NO SCALE

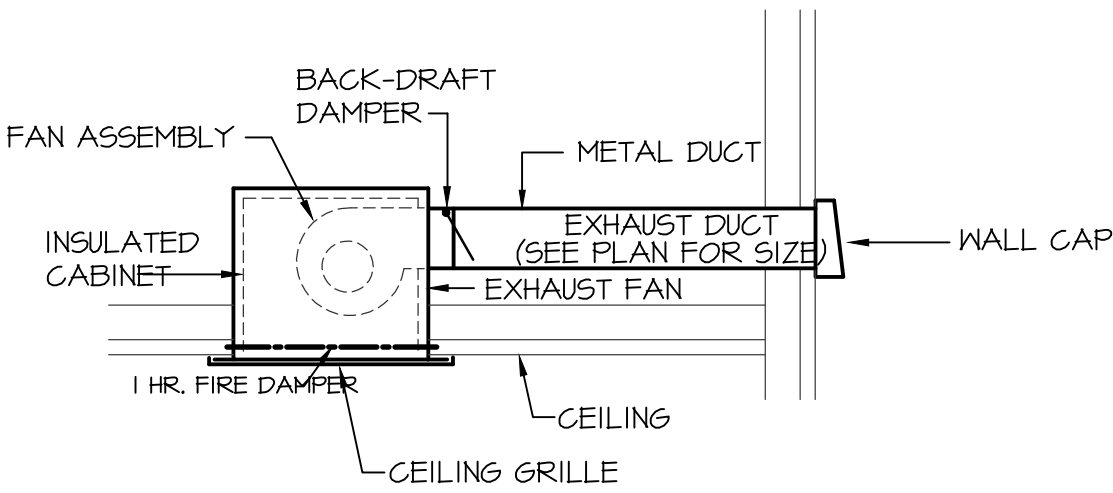

CEILING MOUNTED EXHAUST FAN DETAIL
NO SCALE

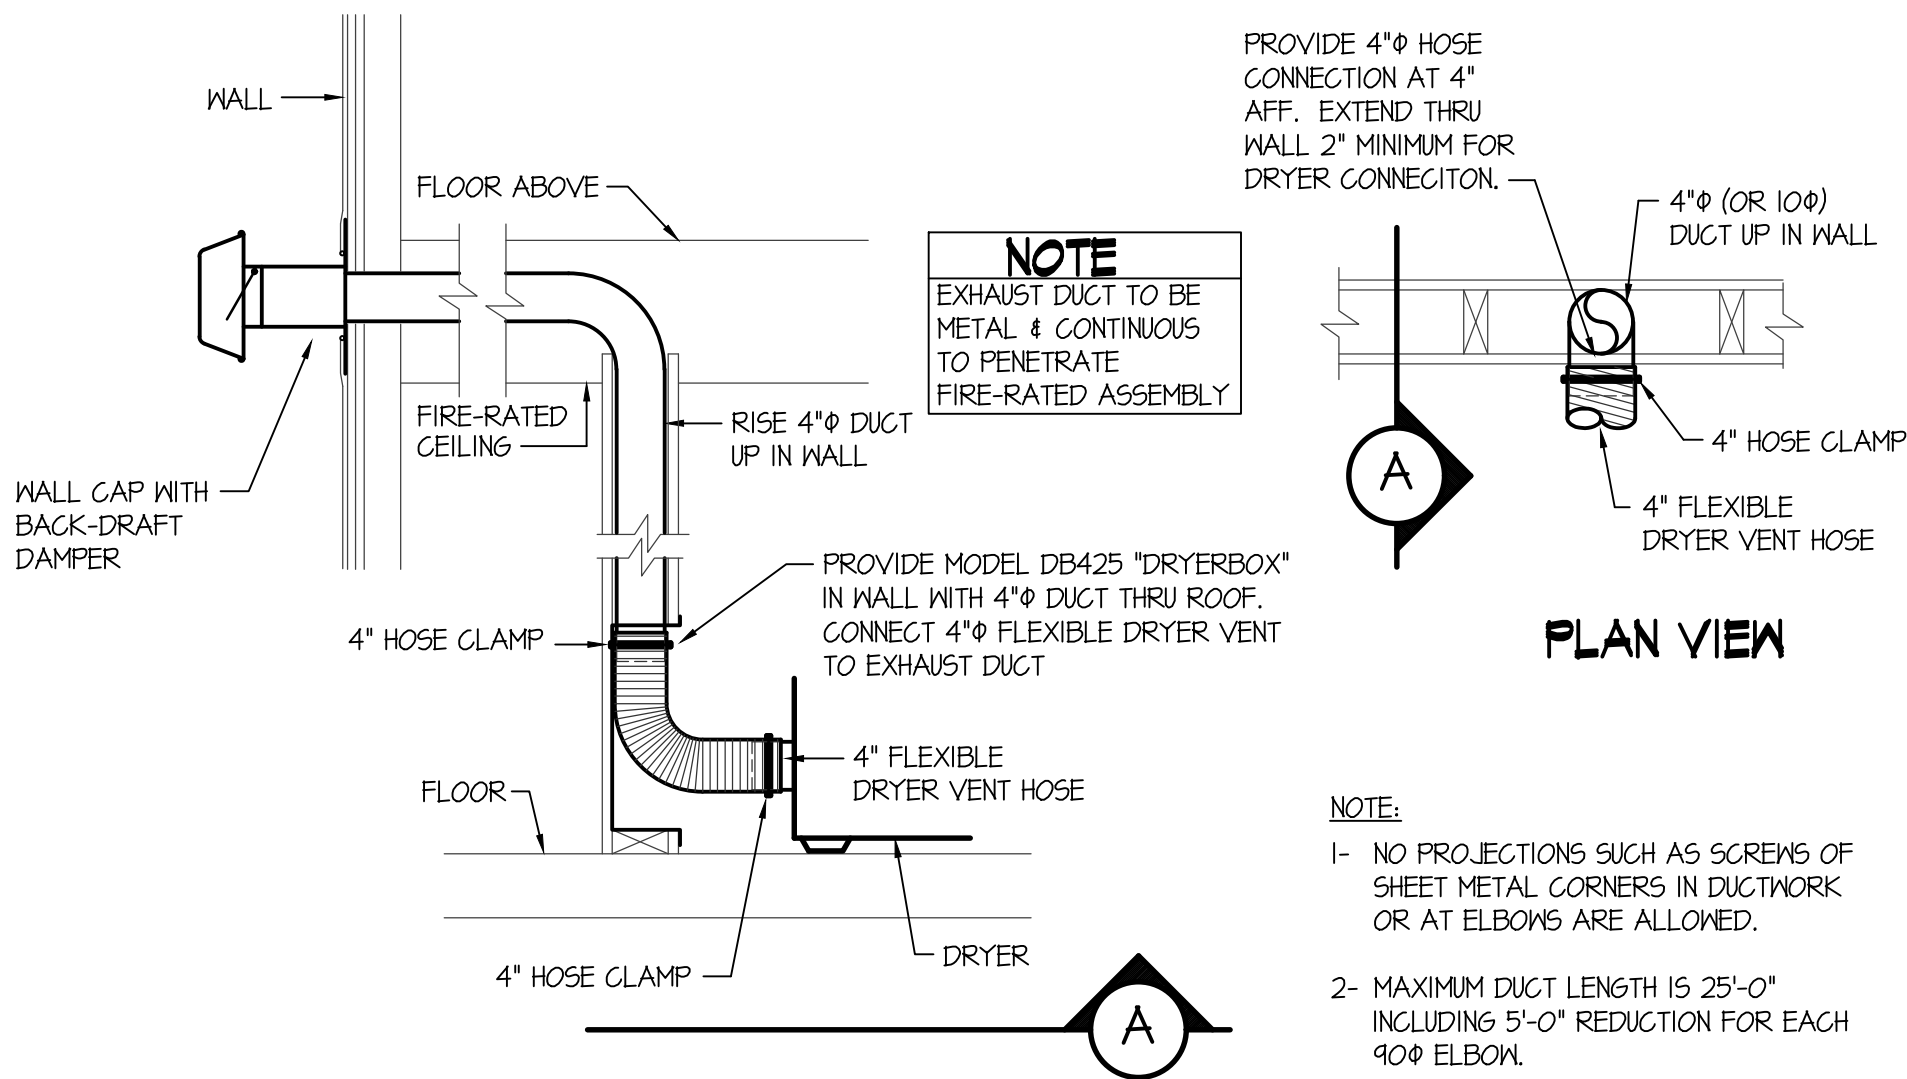

DRYER VENT DETAIL
NO SCALE

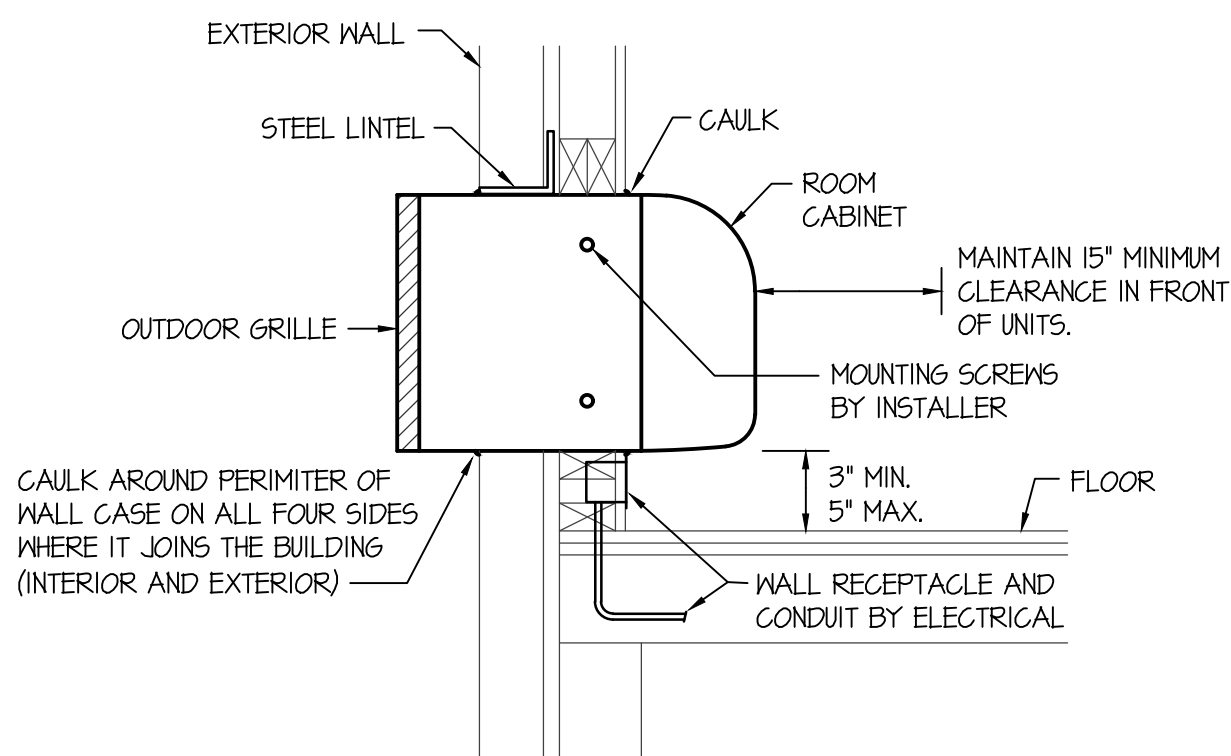

THRU-THE-WALL A/C UNIT DETAIL
NO SCALE

PROFESSIONAL ENGINEER
REGISTERED

DATE OF IDAHO
WATNE C. SUDWIKES

May 27, 2020

Engineered
Systems
Associates

1355 EAST CENTER
POCATELLO, IDAHO 83201

PHONE: (208) 233-0501
FAX: (208) 233-0529
EMAIL: eso@engsystems.com

ESA JOB NUMBER: 19095

A NEW FACILITY FOR:
VALLEY HOUSE
125 ROSE ST., TWIN FALLS, ID 83301
MECHANICAL DETAILS AND SCHEDULES

Laughlin Ricks Architecture
architecture/planning
935 Shoshone Street North * Twin Falls, Idaho 83301
(208) 736-8050 Fax: (208) 733-0950

DATE:
Drawn Checked

M2-0