




**A HEAT PUMP PIPING WITH AUTOMATIC 2-WAY VALVE** NO SCALE

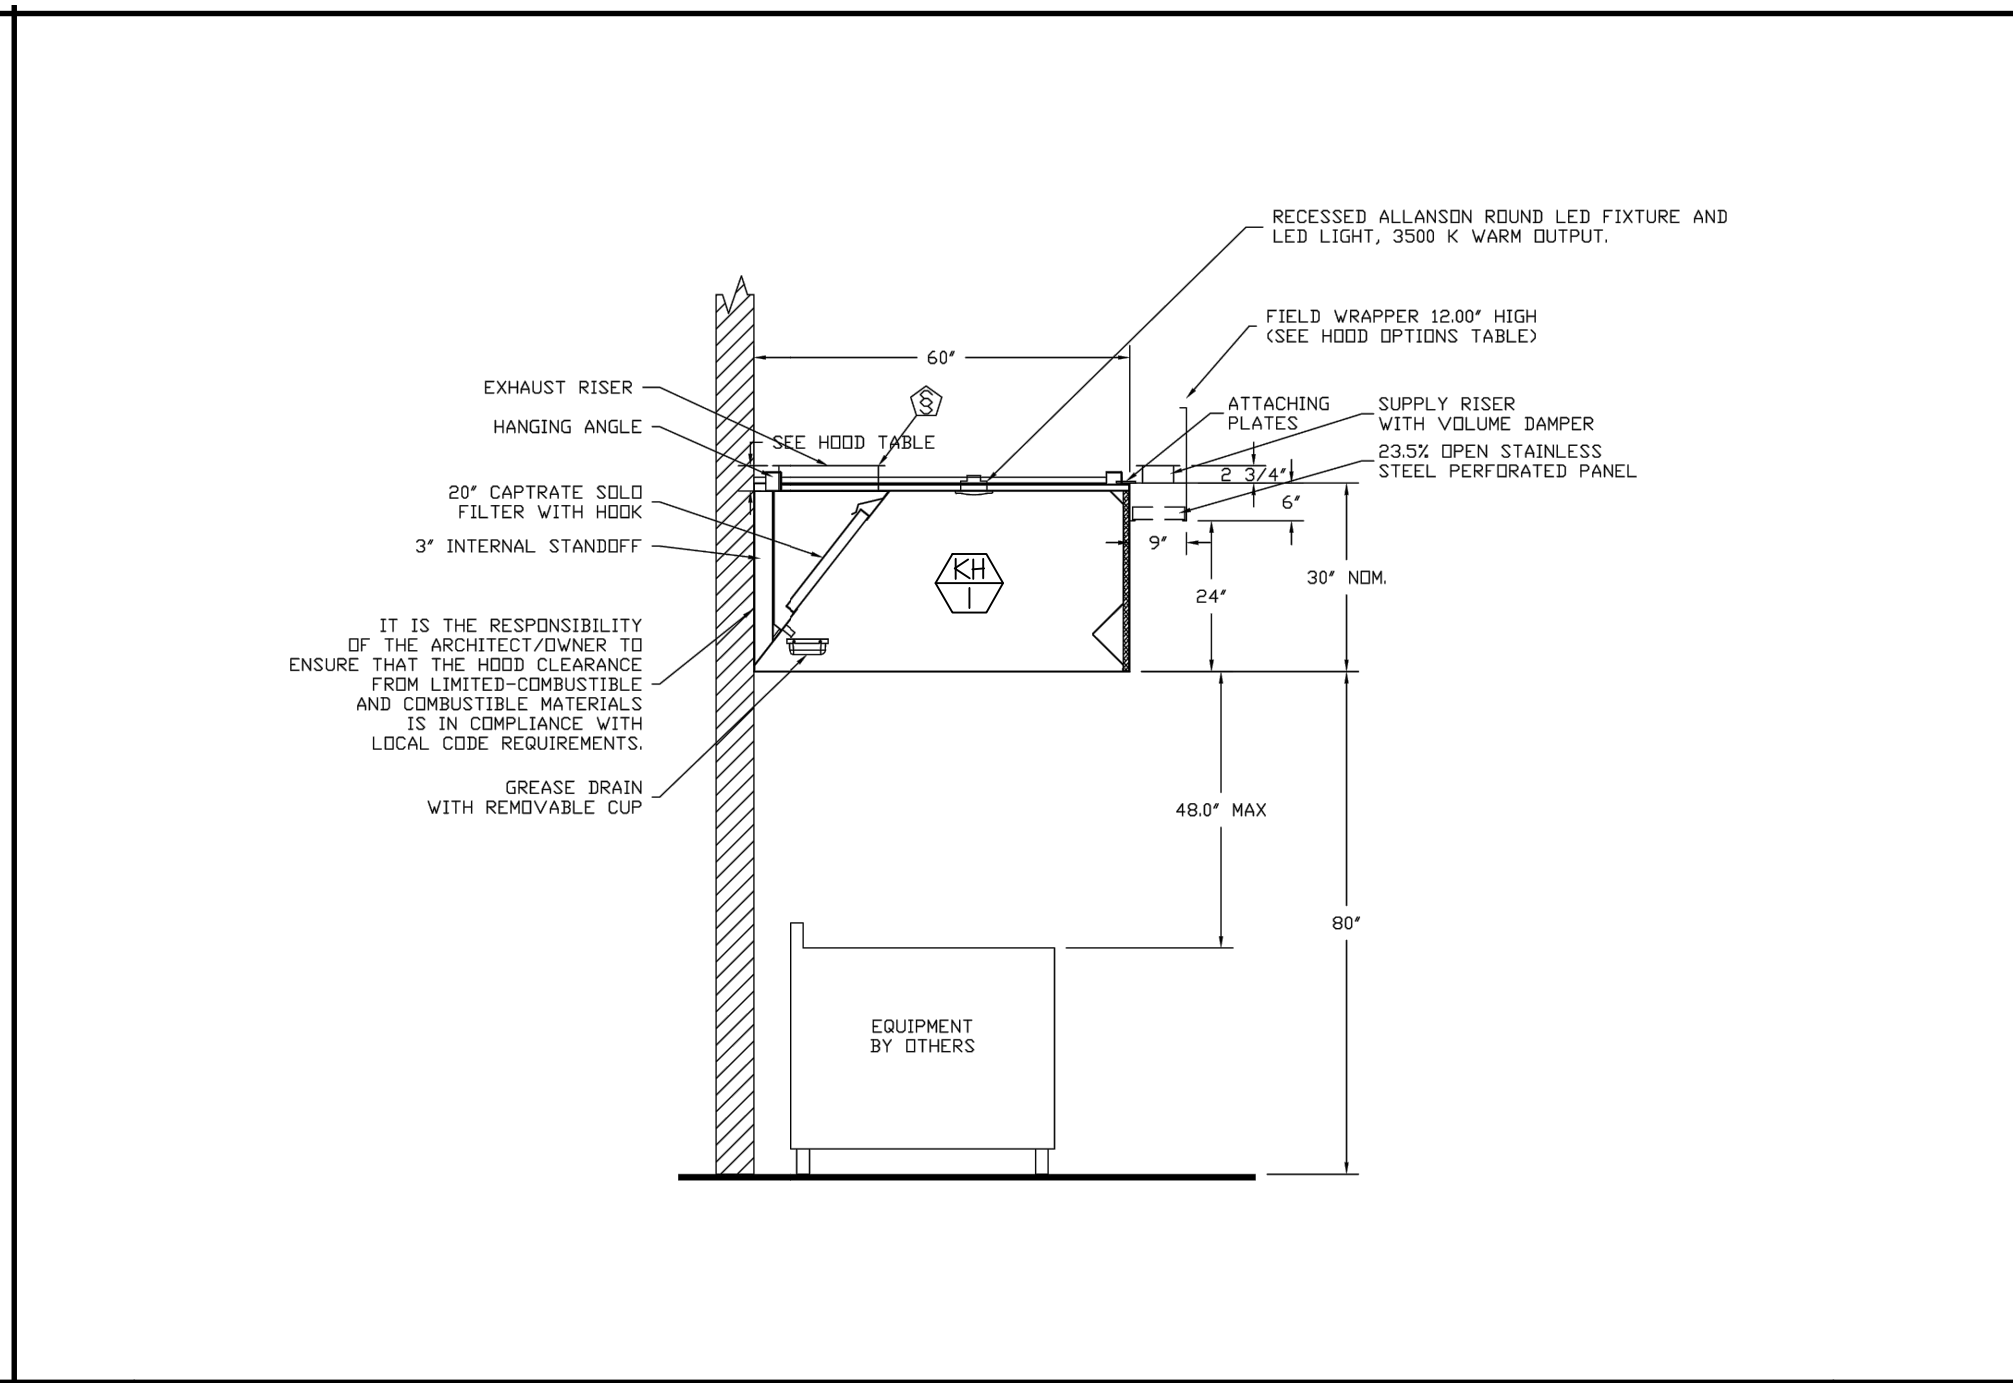


**B TYPICAL KITCHEN HOOD SECTION** NO SCALE

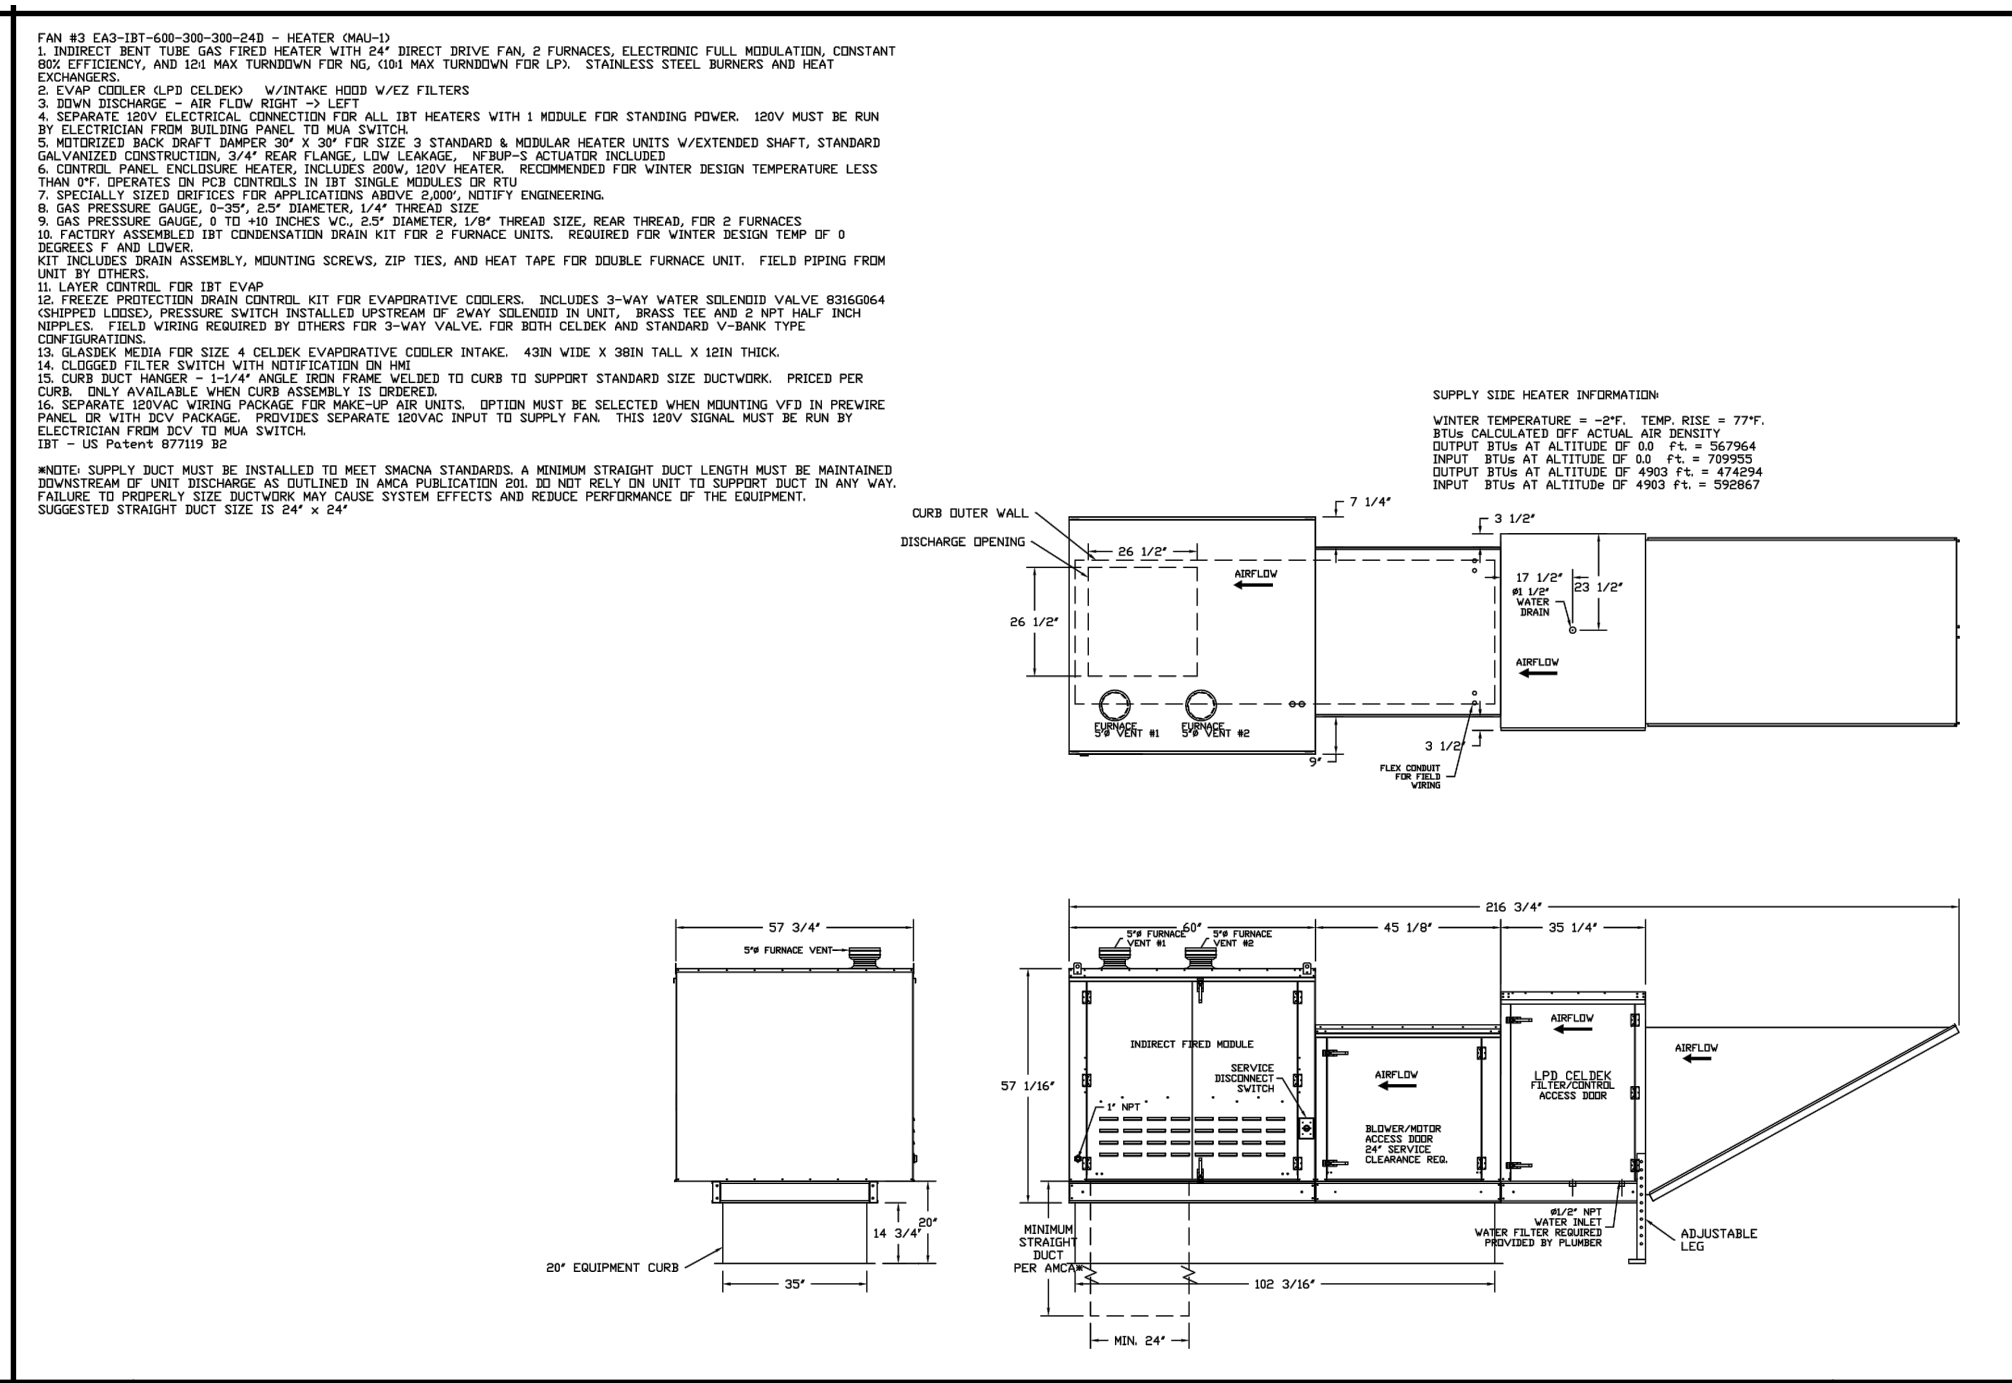


**C KITCHEN HOOD MAKE-UP AIR UNIT DETAIL** NO SCALE

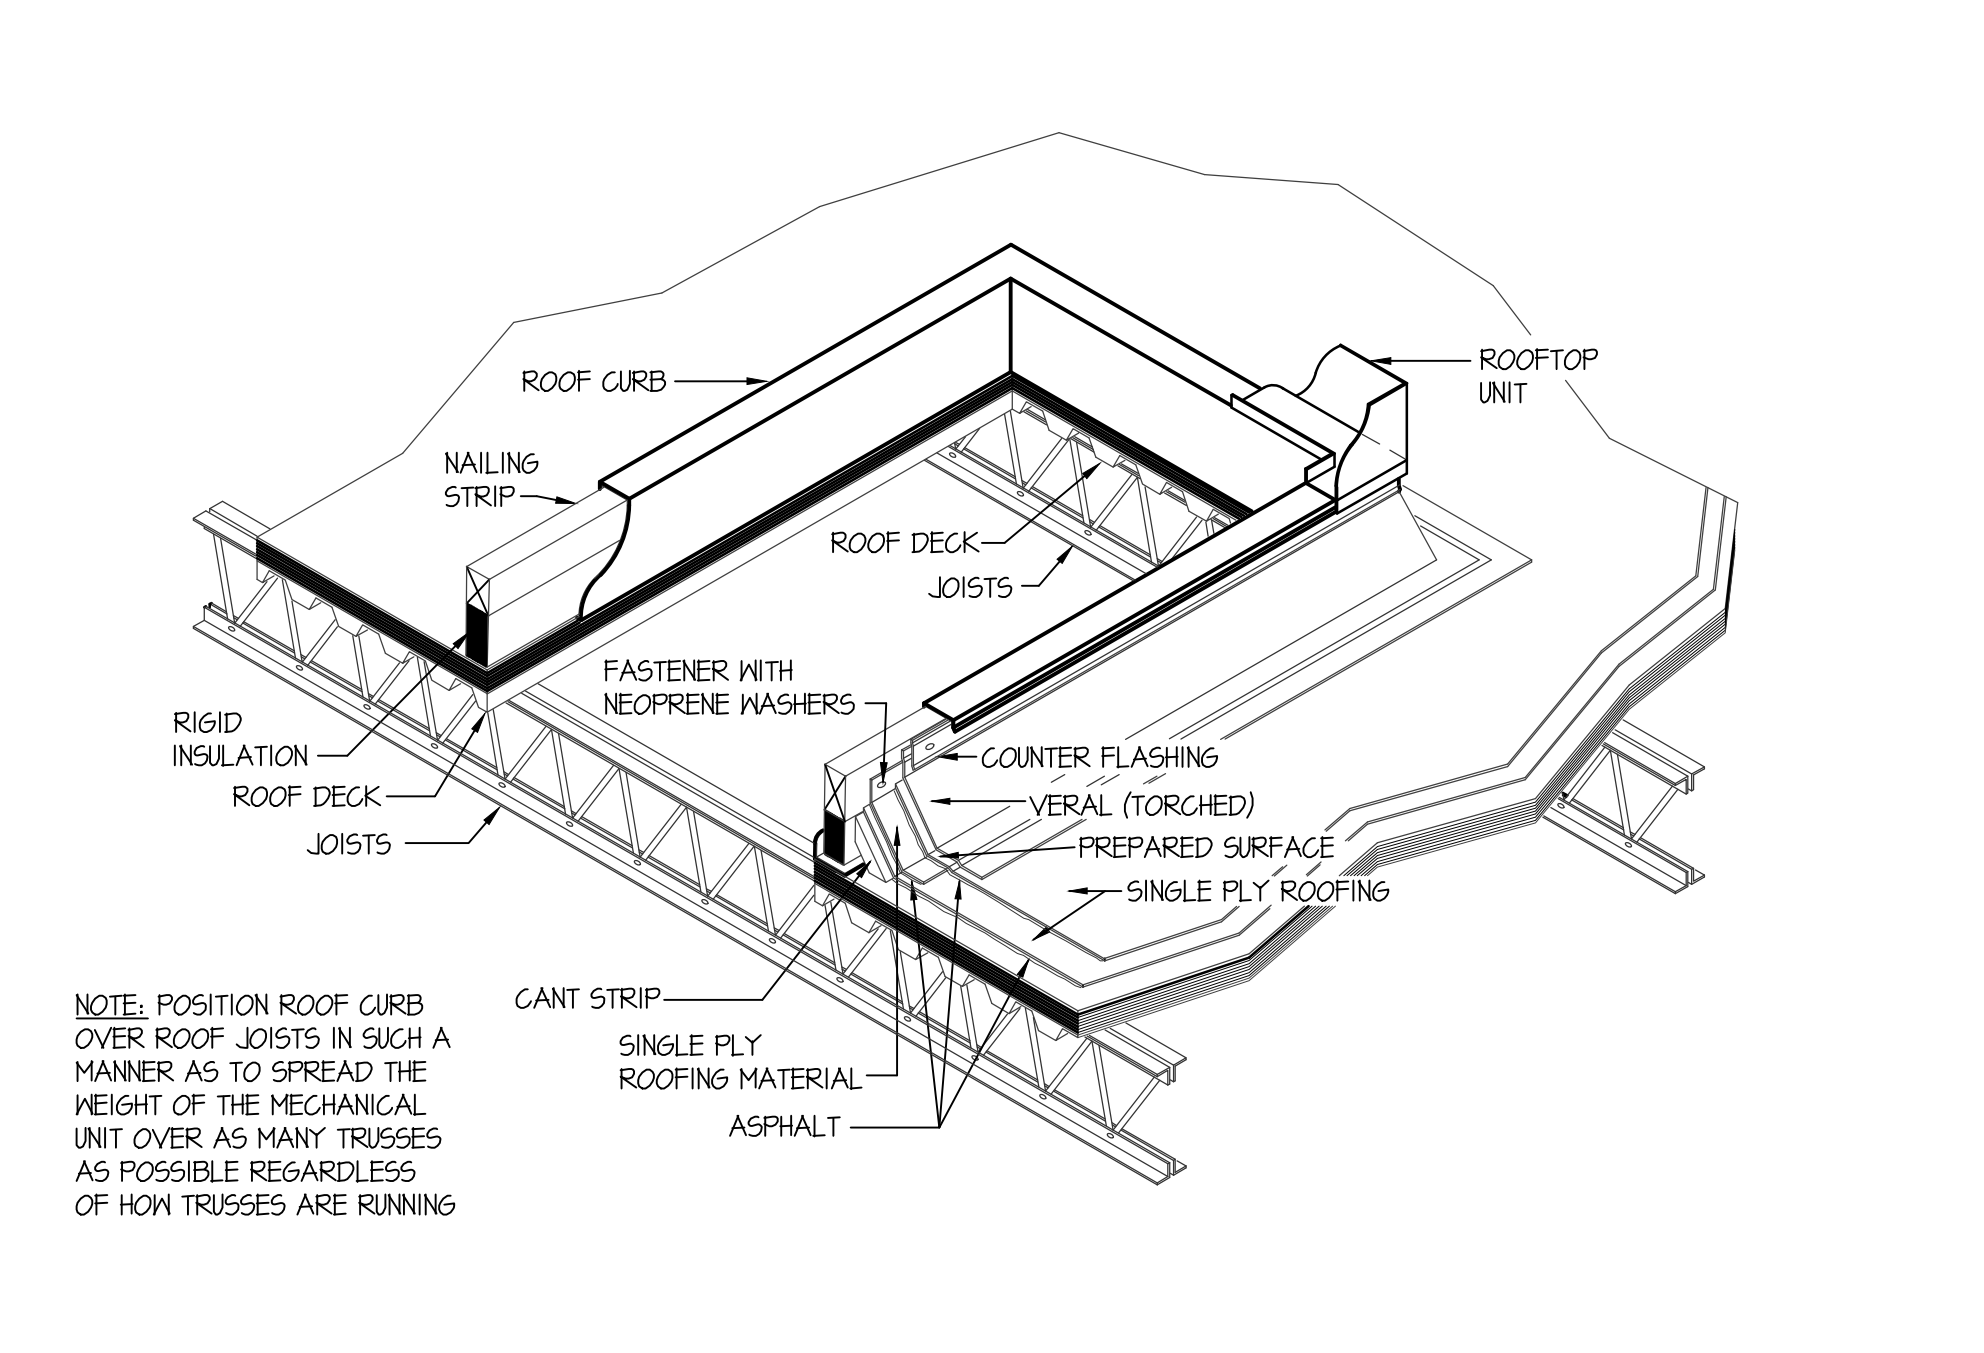


**D TYPICAL ROOF EQUIPMENT MOUNTING DETAIL** NO SCALE

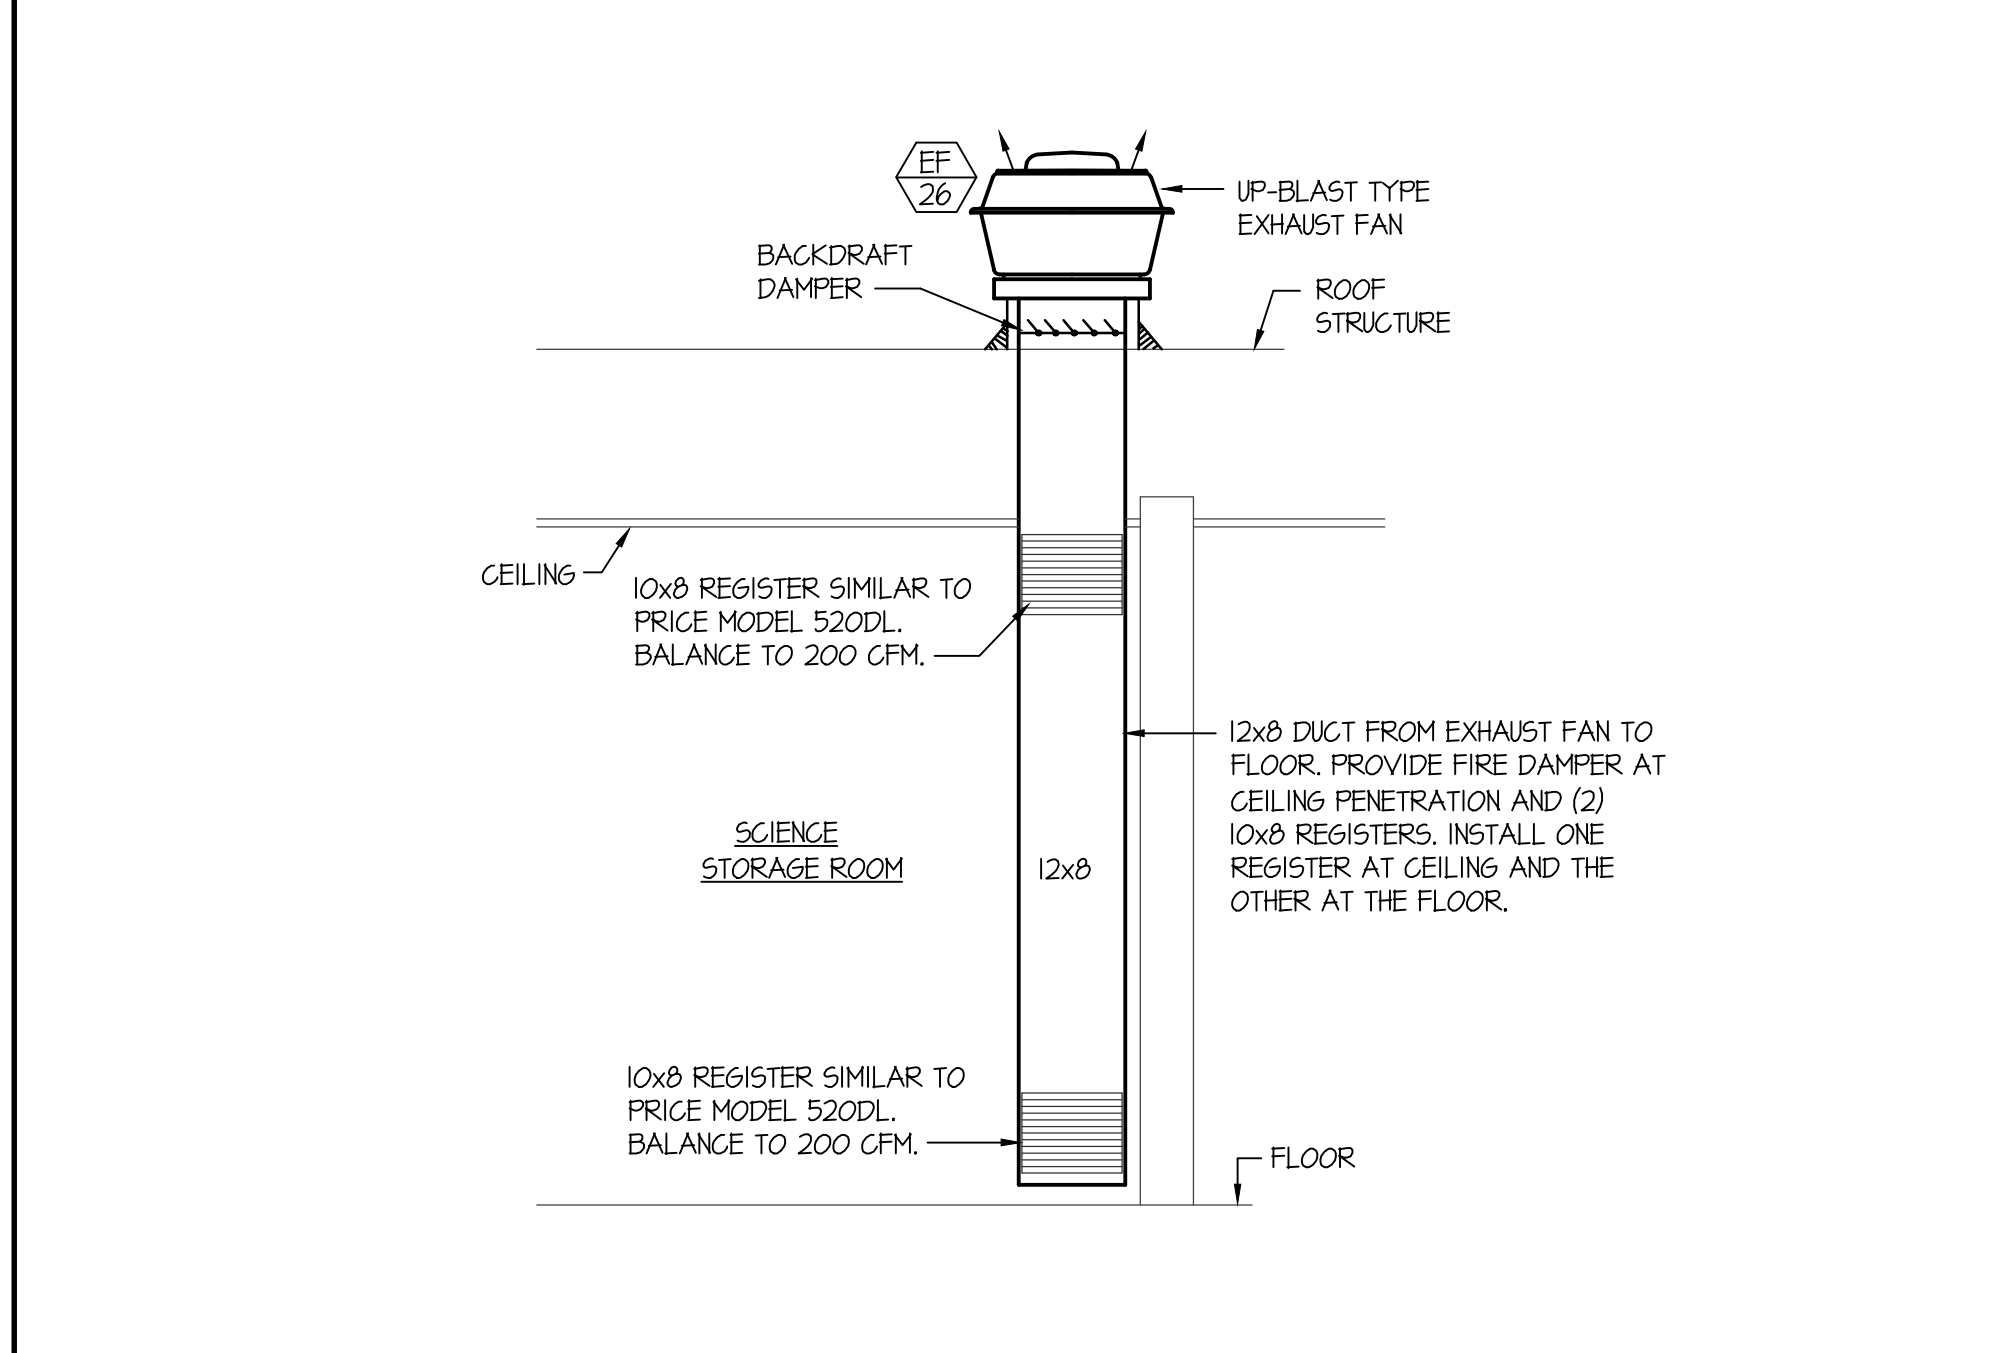


**E CHEMICAL STORAGE ROOM VENTILATION DETAIL** NO SCALE

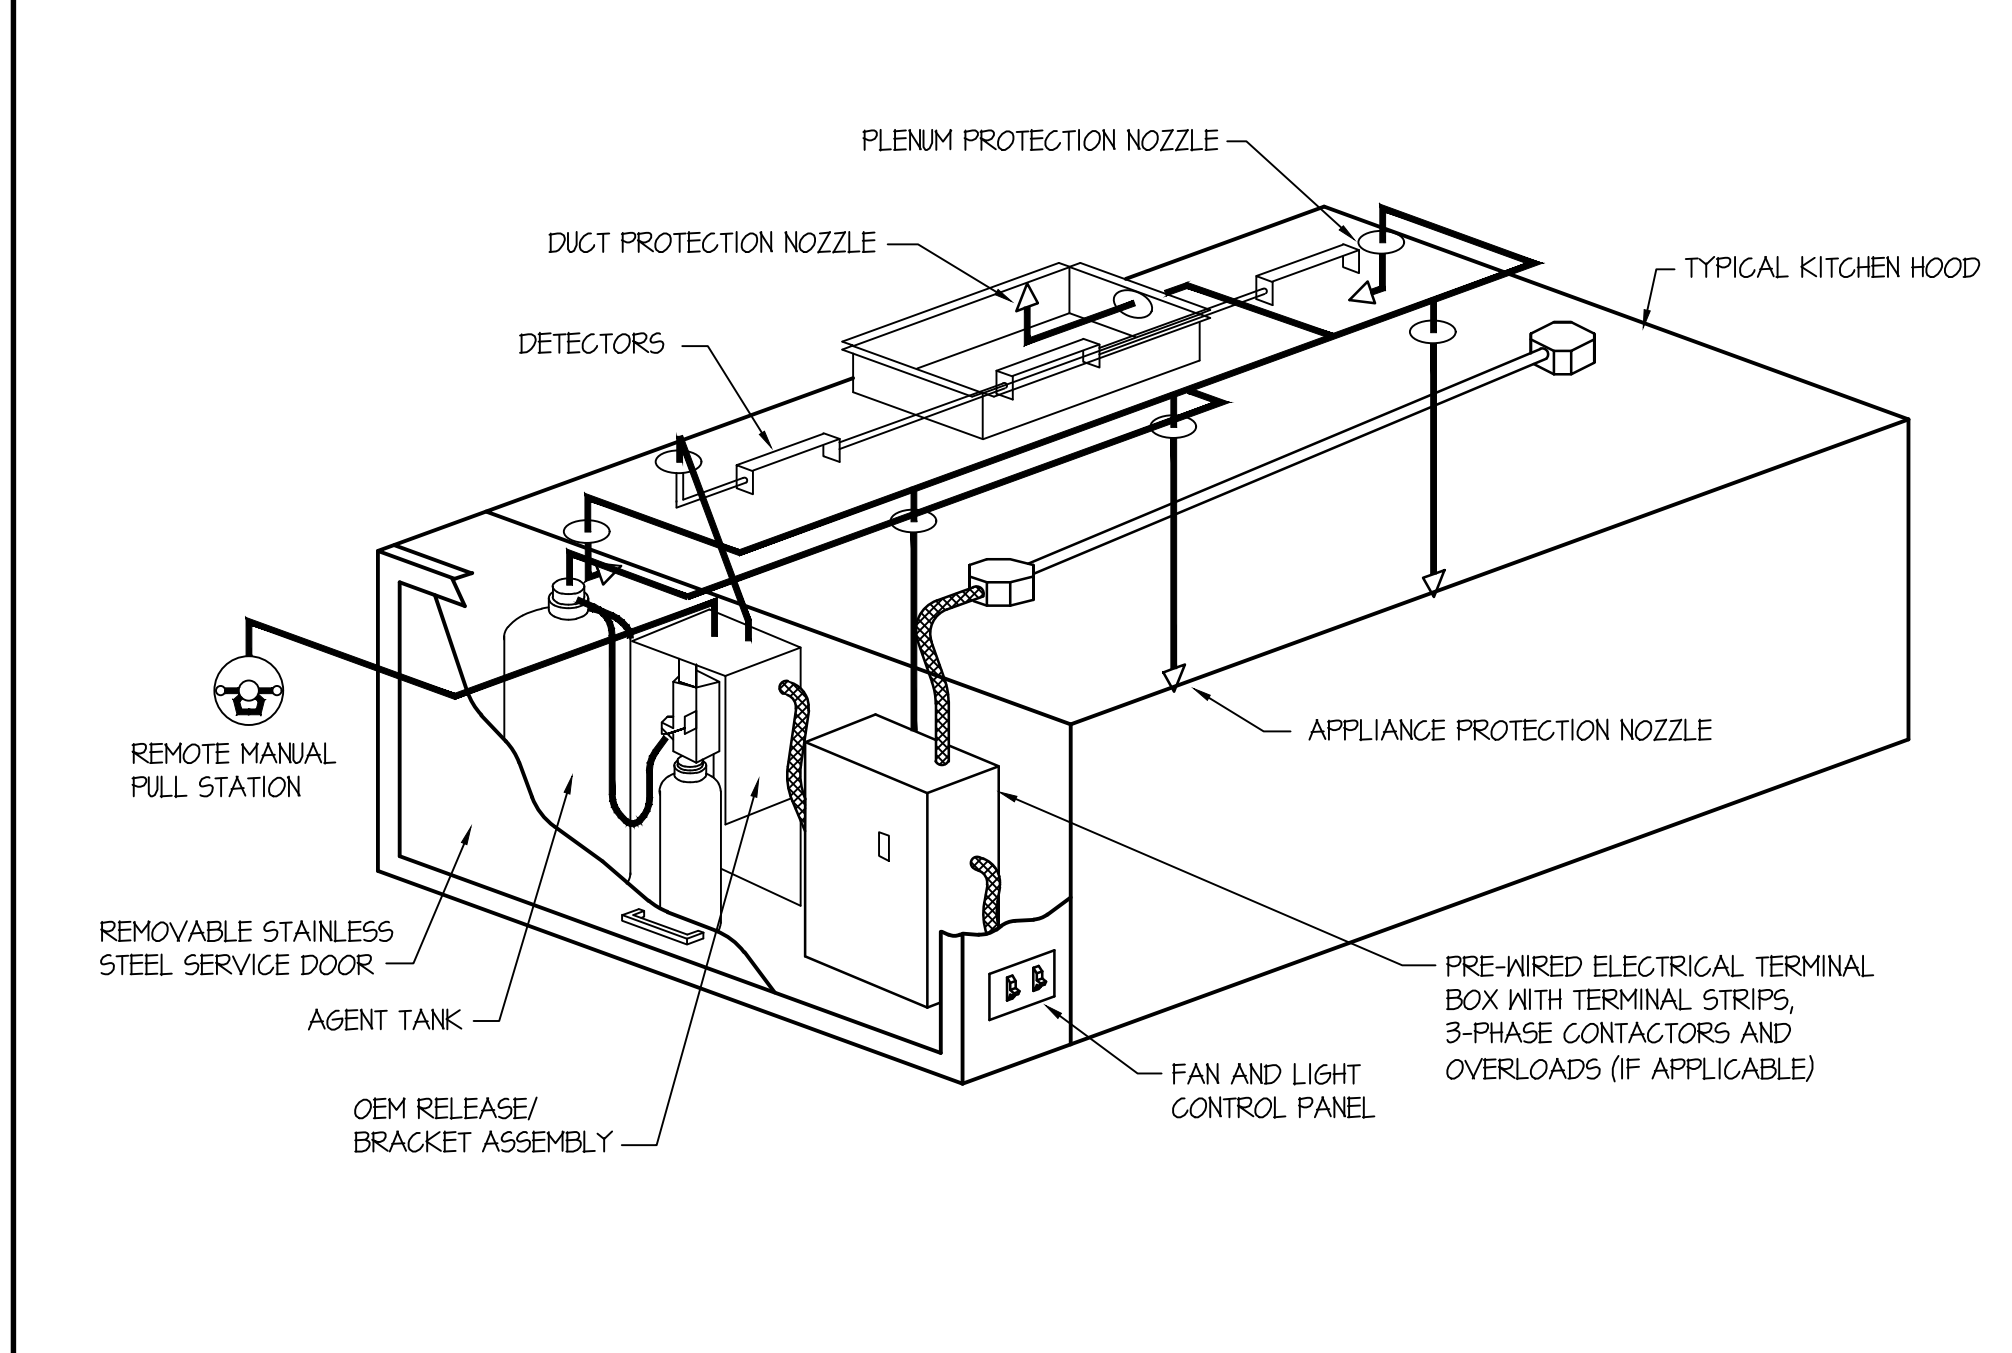


**F TYPICAL ANSUL R-102 SYSTEM LAYOUT** NO SCALE

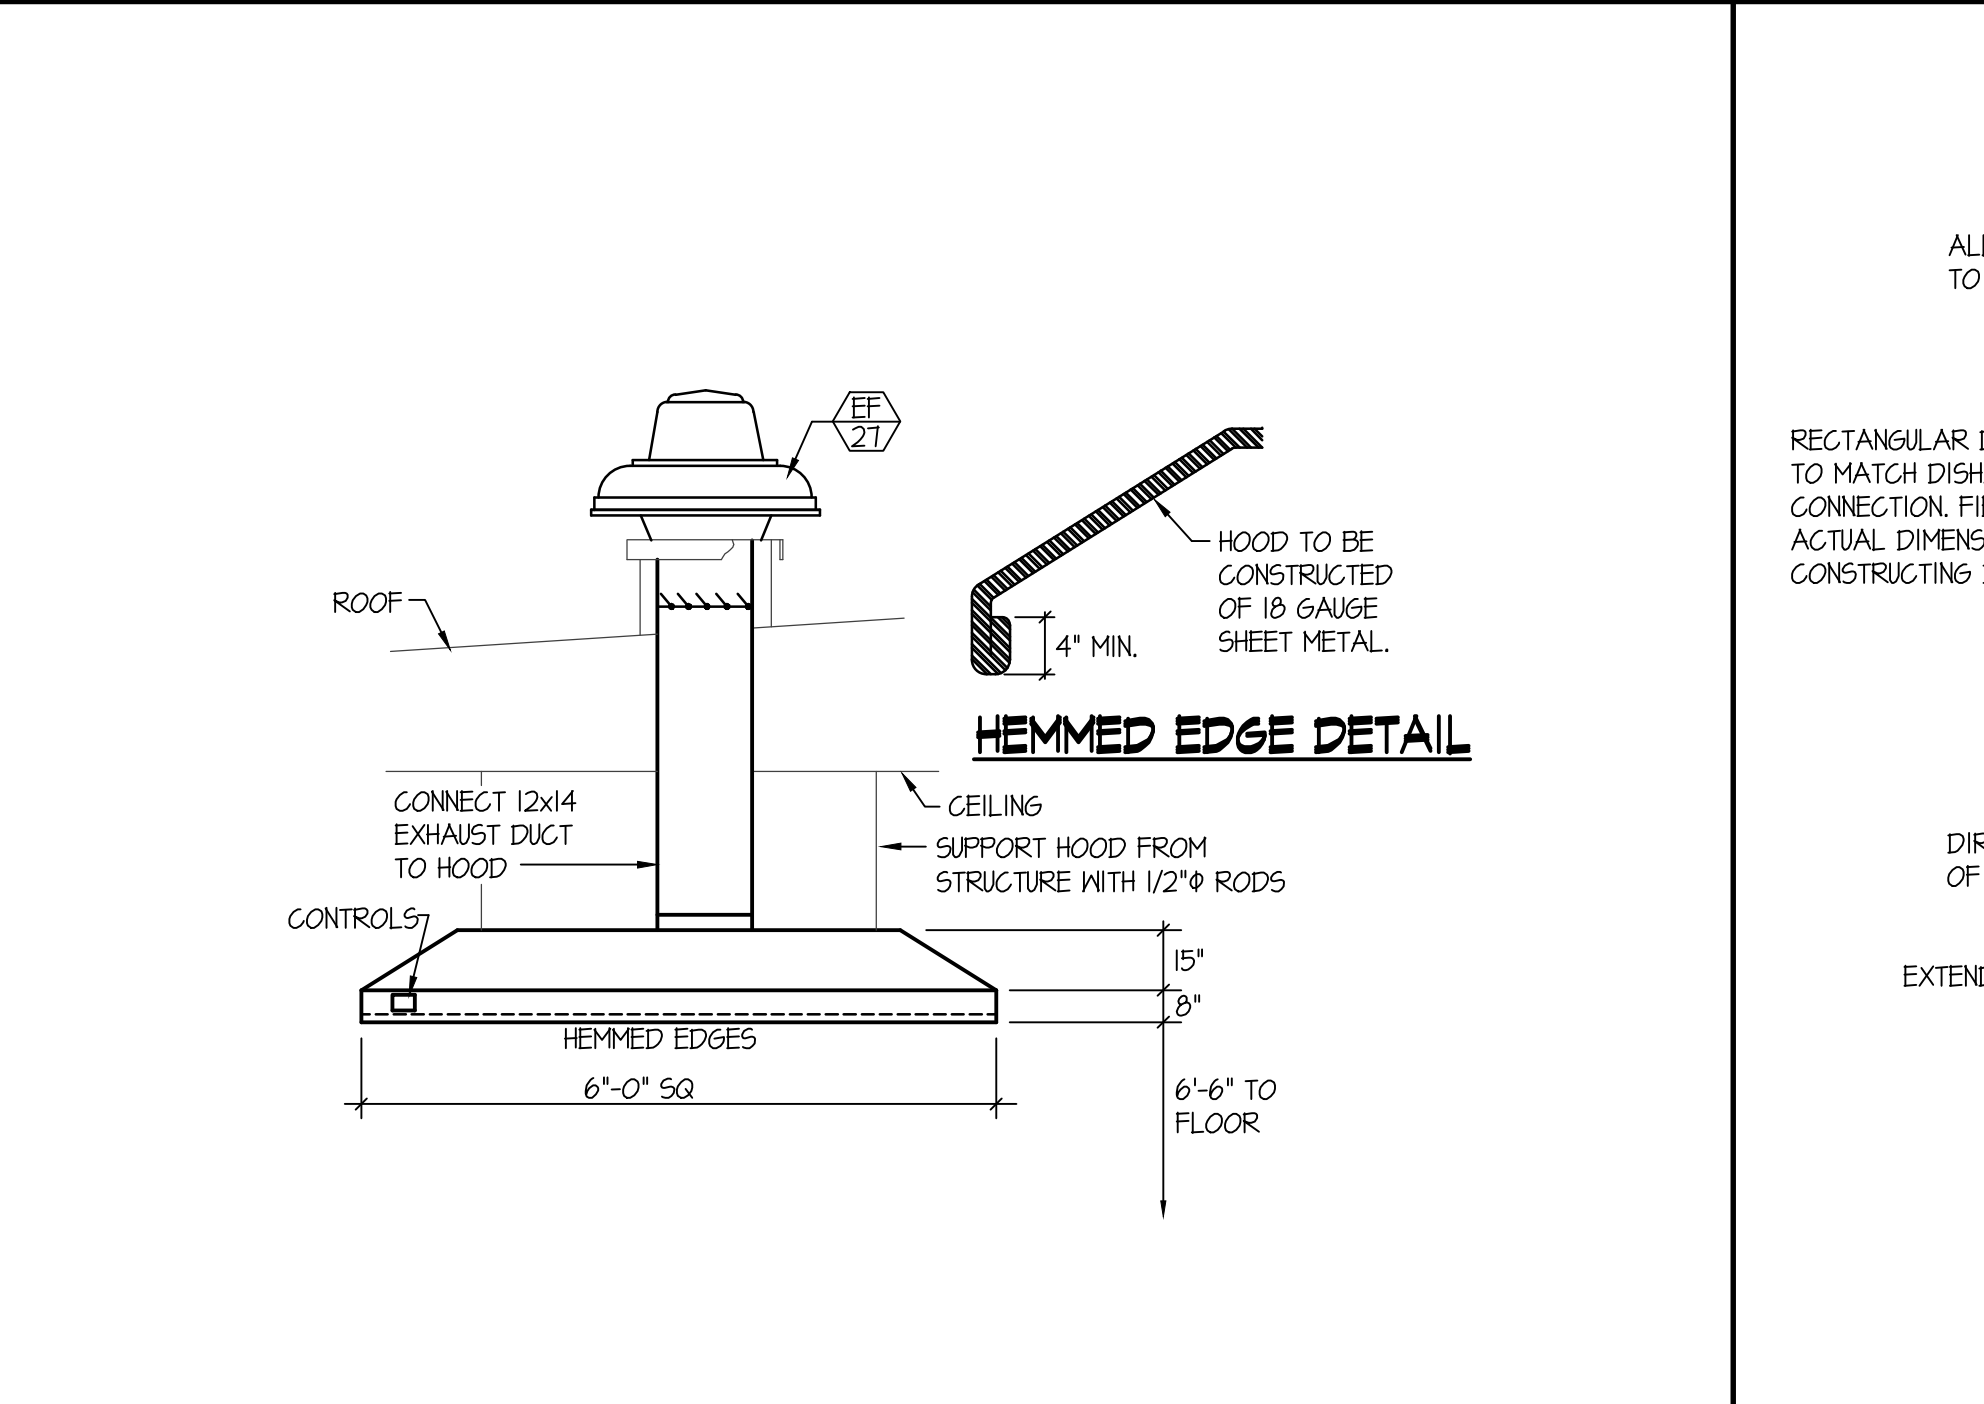

**M CANOPY HOOD DETAIL** NO SCALE

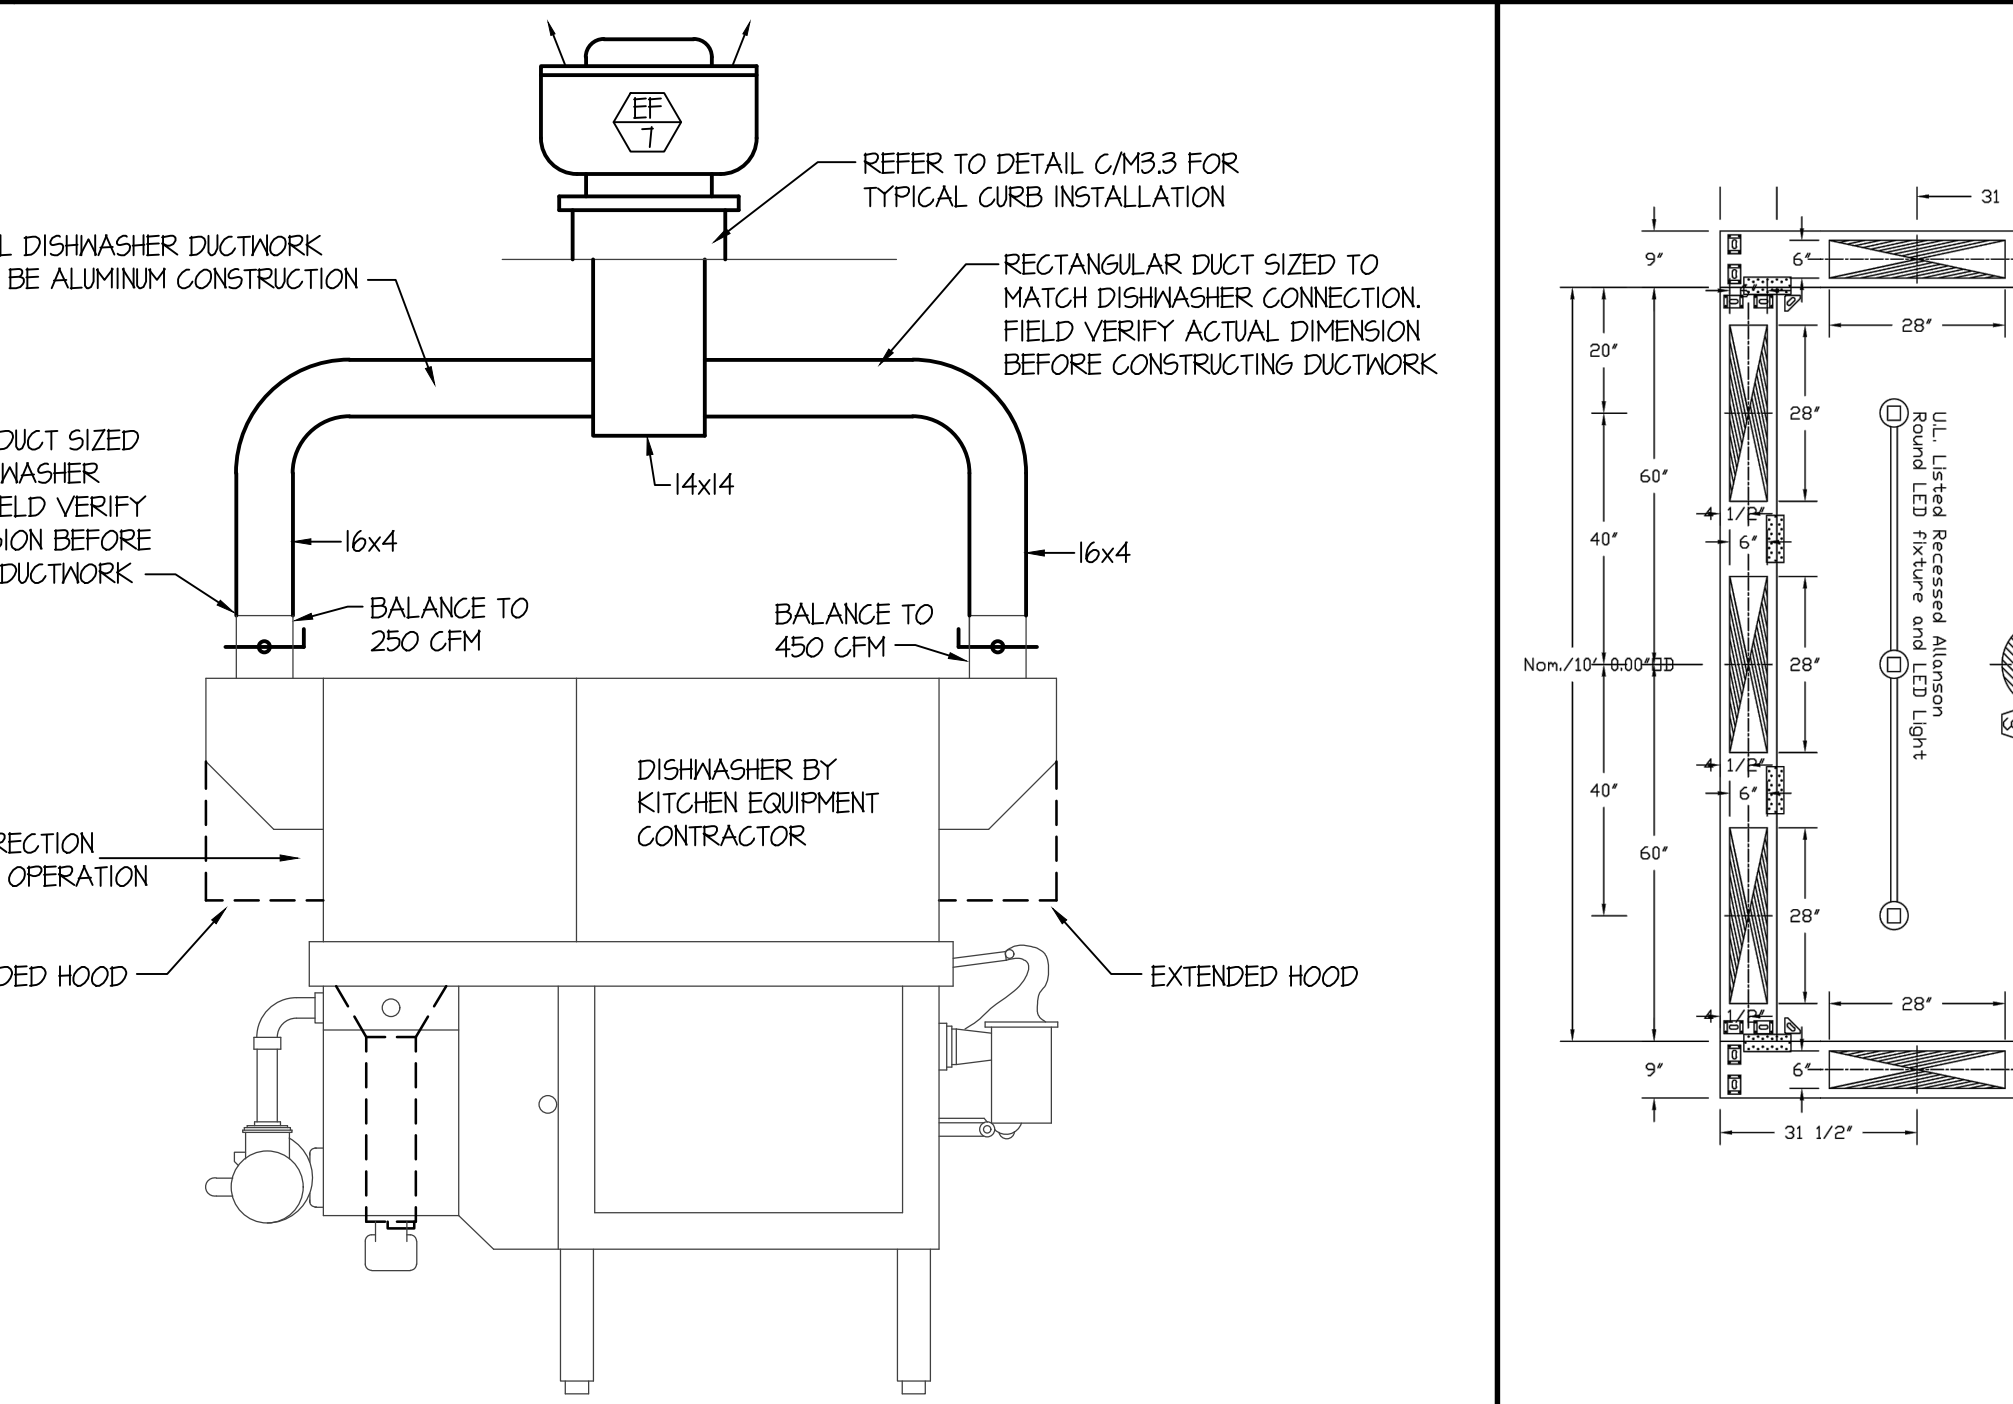

**N DISHWASHER HOOD DETAIL** NO SCALE

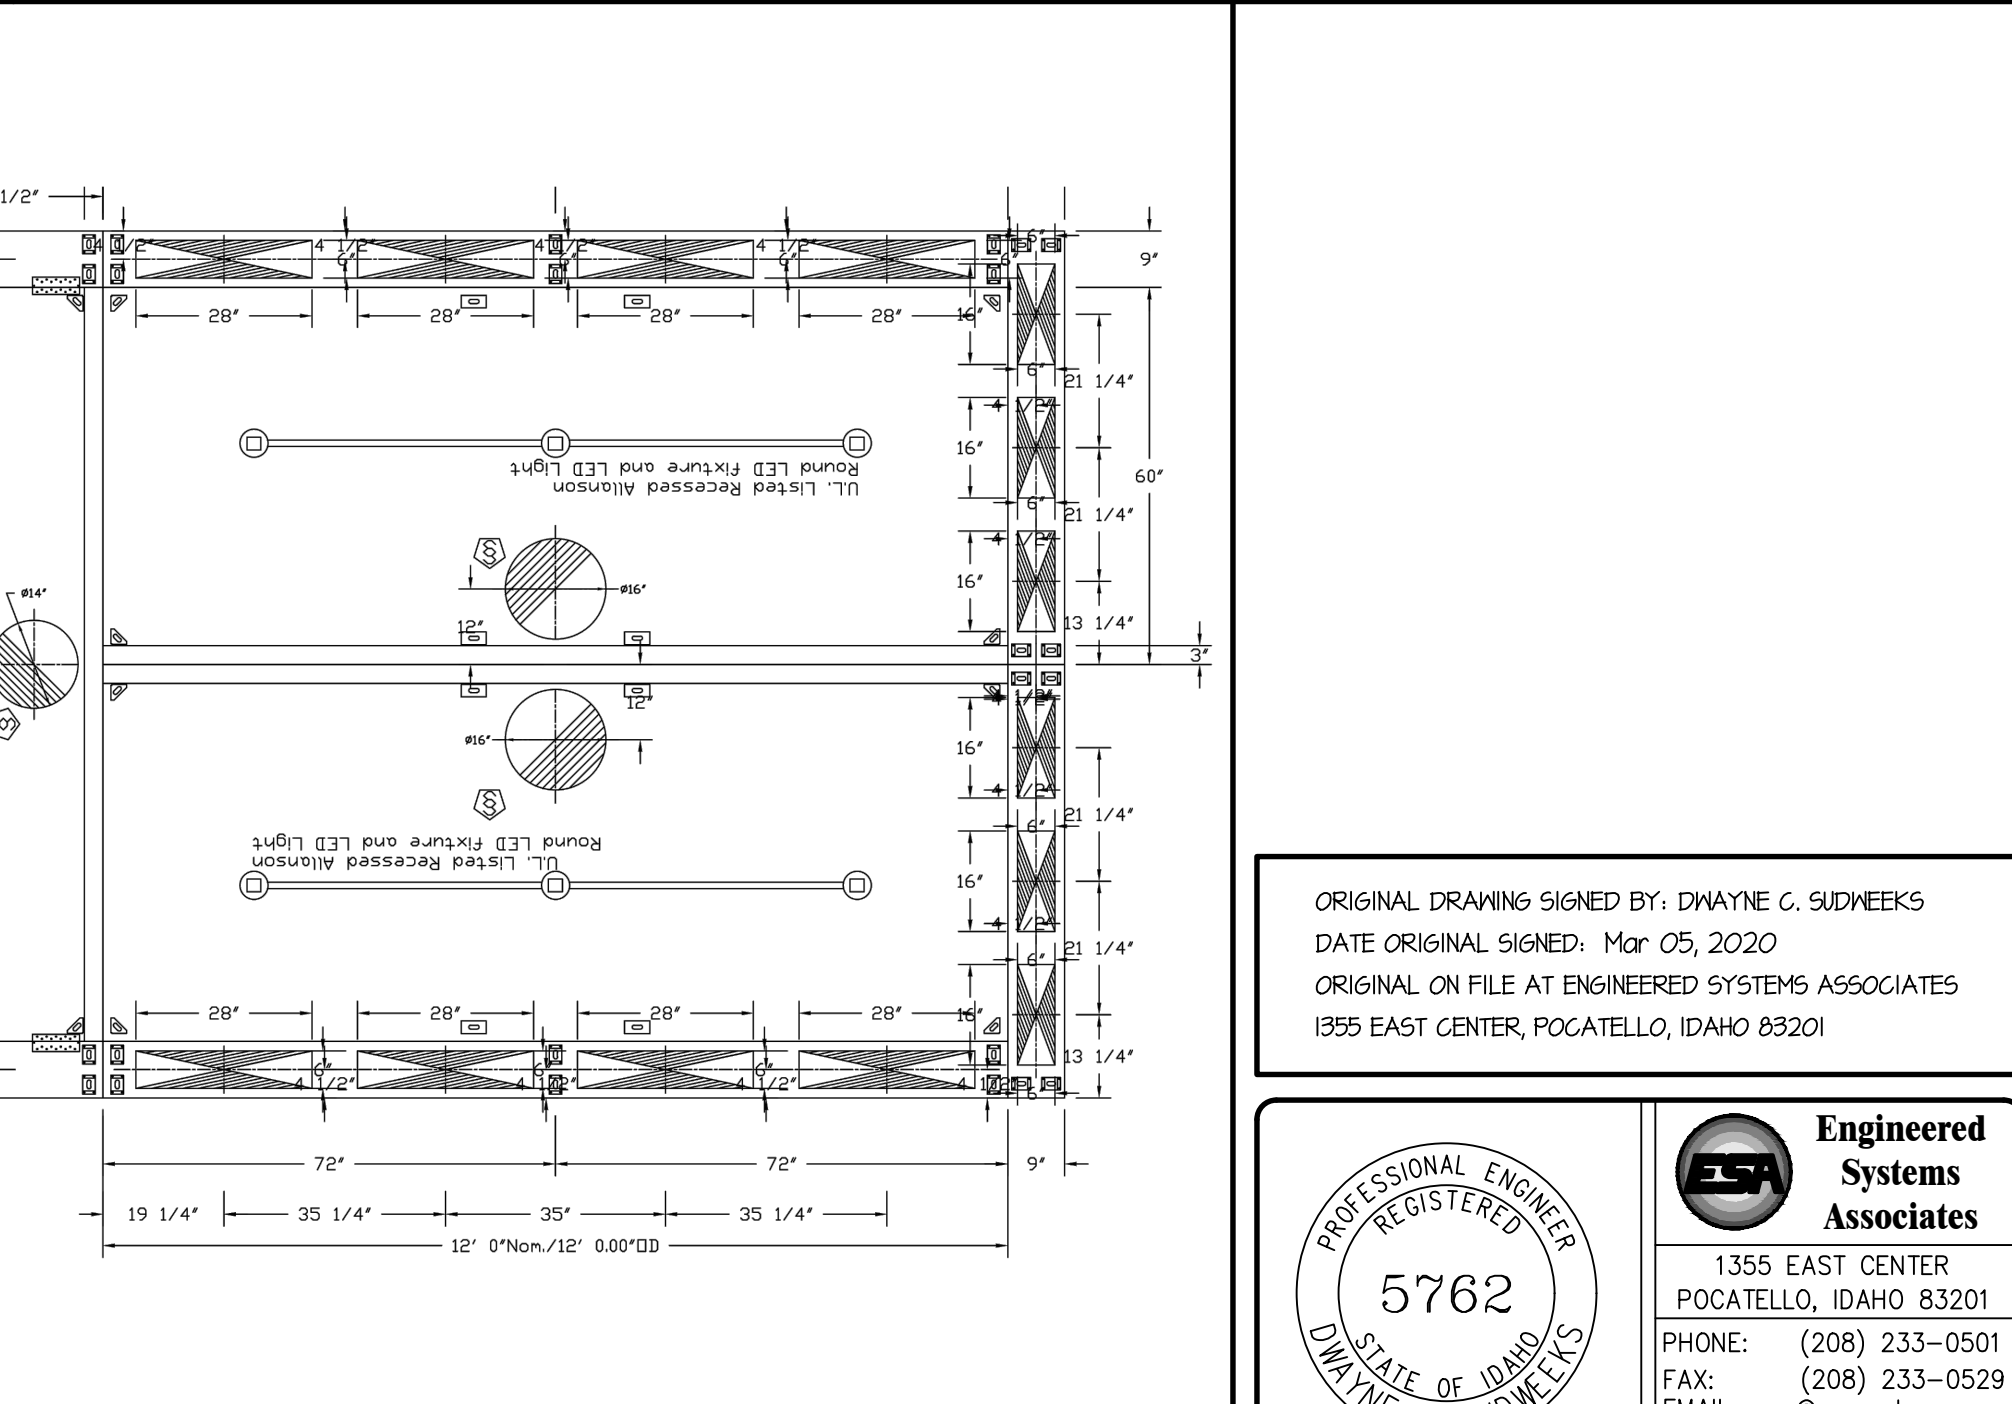

**O KITCHEN HOOD DUCT CONNECTION DETAIL** NO SCALE

ORIGINAL DRAWING SIGNED BY: DWAYNE C. SUDNEEKS  
 DATE ORIGINAL SIGNED: Mar 05, 2020  
 ORIGINAL ON FILE AT ENGINEERED SYSTEMS ASSOCIATES  
 1355 EAST CENTER, POCATELLO, IDAHO 83201

PROFESSIONAL ENGINEER REGISTERED 5762 DWAYNE C. SUDNEEKS

Engineered Systems Associates  
 1355 EAST CENTER  
 POCATELLO, IDAHO 83201  
 PHONE: (208) 233-0501  
 FAX: (208) 233-0529  
 EMAIL: esa@engsystems.com  
 ESA JOB NUMBER: 19099

REVISION:

#	DATE	COMMENT
1		

DRAWING NO. FILE: 19099-M3.2.dwg  
**M3.2**  
 OF 17

**BID SET**  
 BRENT A. MCFARLAND AR-2561  
 STATE OF IDAHO

**IRWA ASSOCIATES**  
 1152 BOND AVENUE - SUITE A REIDBURG, IDAHO 83440  
 WWW.IRWACOM VOICE (208) 359-2309 FAX (208) 359-2271

CONSULTANTS:  
 LANDSCAPE ARCHITECT  
 REYER & ASSOCIATES  
 1805 South Woodruff  
 Idaho Falls, Idaho 83404  
 (208) 328-8504

CIVIL ENGINEERING  
 CONNECT ENGINEERING  
 1100 Hubbard Dr.  
 Idaho Falls, Idaho 83405  
 (208) 681-8590

STRUCTURAL ENGINEERING  
 FROST STRUCTURAL ENGINEERING  
 1020 Lincoln Road  
 Idaho Falls, Idaho 83401  
 (208) 227-8404  
 Fax (208) 227-8405

MECHANICAL ENGINEERING  
 ENGINEERED SYSTEMS ASSOC.  
 1355 East Center Street  
 Pocatello, Idaho 83204  
 (208) 233-0501  
 Fax (208) 233-0529

ELECTRICAL ENGINEERING  
 PANE ENGINEERING INC.  
 1823 East Center St.  
 Pocatello, Idaho 83201  
 (208) 232-4439  
 Fax (208) 232-1435

IDAHO  
 SUGAR CITY  
**SUGAR - SALEM**  
 SD #322  
 JUNIOR HIGH SCHOOL

DRAWING TITLE:  
**MECHANICAL DETAILS AND DIAGRAMS**