



F:\191004\191004-Sugar_Salem_High\191004-PO.0.dwg Apr 06, 2020 - 2:06pm

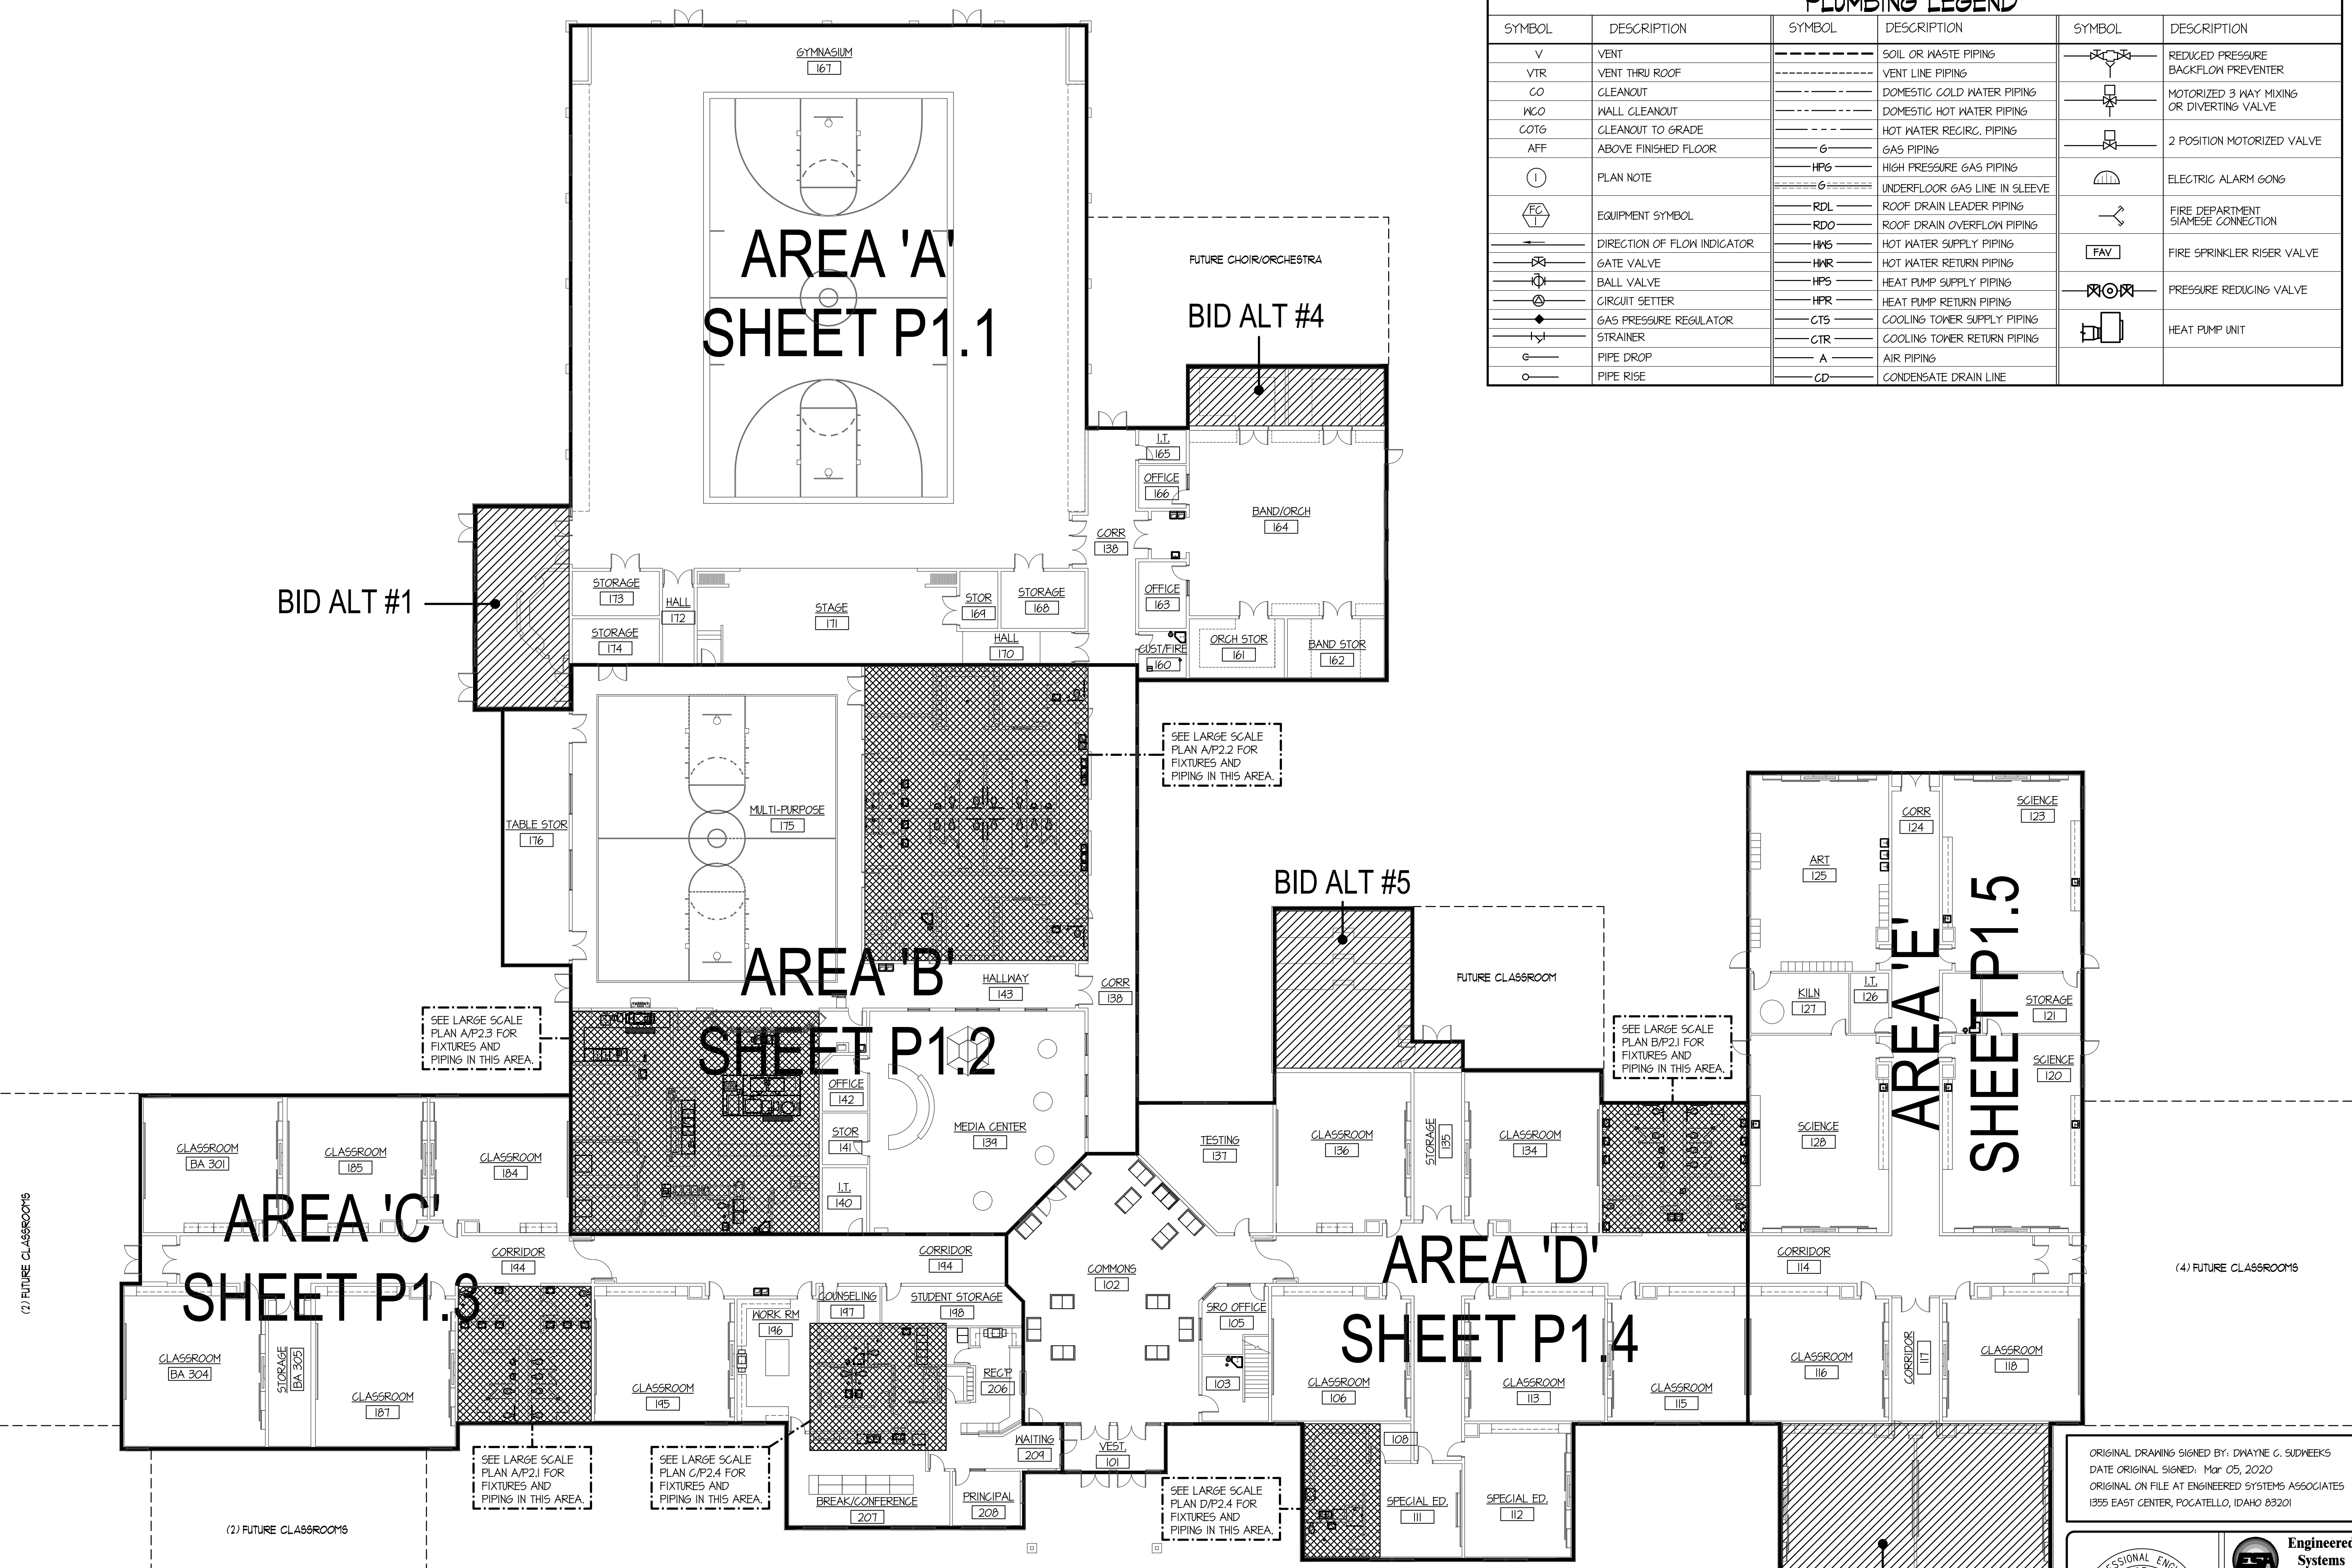

PLUMBING LEGEND					
SYMBOL	DESCRIPTION	SYMBOL	DESCRIPTION	SYMBOL	DESCRIPTION
V	VENT	---	SOIL OR WASTE PIPING	⊗	REDUCED PRESSURE BACKFLOW PREVENTER
VTR	VENT THRU ROOF	----	VENT LINE PIPING	⊗	MOTORIZED 3 WAY MIXING OR DIVERTING VALVE
CO	CLEANOUT	----	DOMESTIC COLD WATER PIPING	⊗	2 POSITION MOTORIZED VALVE
WCO	WALL CLEANOUT	----	DOMESTIC HOT WATER PIPING	⊗	ELECTRIC ALARM GONG
COTG	CLEANOUT TO GRADE	----	HOT WATER RECIRC. PIPING	⊗	FIRE DEPARTMENT SIAMESE CONNECTION
AFF	ABOVE FINISHED FLOOR	----	GAS PIPING	⊗	FIRE SPRINKLER RISER VALVE
①	PLAN NOTE	----	HPG	⊗	PRESSURE REDUCING VALVE
⊗	EQUIPMENT SYMBOL	----	UNDERFLOOR GAS LINE IN SLEEVE	⊗	HEAT PUMP UNIT
→	DIRECTION OF FLOW INDICATOR	----	RDL		
⊗	GATE VALVE	----	RDO		
⊗	BALL VALVE	----	HWS		
⊗	CIRCUIT SETTER	----	HWR		
⊗	GAS PRESSURE REGULATOR	----	HPS		
⊗	STRAINER	----	HPR		
⊗	PIPE DROP	----	CTS		
⊗	PIPE RISE	----	CTR		
		----	A		
		----	CD		

COMPOSITE PLUMBING FLOOR PLAN
SCALE: 1/16" = 1'-0"

BID SET
BRENT A. MCFARLAND AR-2561
STATE OF IDAHO

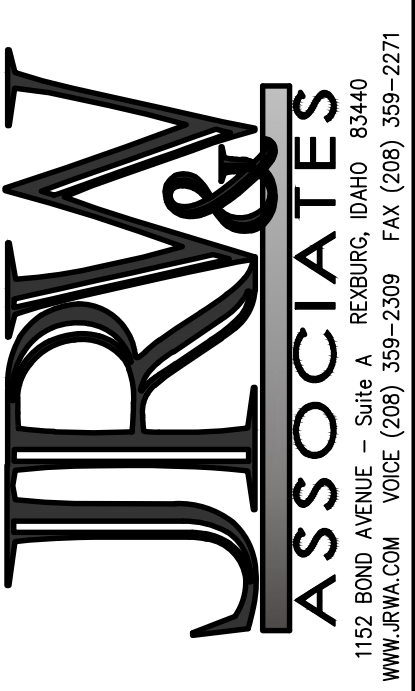

- CONSULTANTS:**
- LANDSCAPE ARCHITECT:**
REYER & ASSOCIATES
1605 South Woodruff
Idaho Falls, Idaho 83404
(208) 227-4604
Fax (208) 528-9504
 - CIVIL ENGINEERING:**
CONNECT ENGINEERING
1100 Harrison Dr.
Idaho Falls, Idaho 83405
(208) 681-8590
 - STRUCTURAL ENGINEERING:**
FROST STRUCTURAL ENGINEERING
1020 Lincoln Road
Idaho Falls, Idaho 83401
(208) 227-4604
Fax (208) 227-8405
 - MECHANICAL ENGINEERING:**
ENGINEERED SYSTEMS ASSOC.
1355 East Center Street
Pocatello, Idaho 83204
(208) 233-0501
Fax (208) 233-0529
 - ELECTRICAL ENGINEERING:**
PANE ENGINEERING INC.
1823 East Center St.
Pocatello, Idaho 83201
(208) 232-4439
Fax (208) 232-1435

SUGAR - SALEM
SD #322
JUNIOR HIGH SCHOOL
SUGAR CITY IDAHO
PROJECT:
DRAWING TITLE:
COMPOSITE PLUMBING FLOOR PLAN

REVISION:		
#	DATE	COMMENT
1		
DRAWN BY:	M. JENSEN	JOB NO: 764
CHECKED BY:	D. SUDNEEKS	DATE: APR '20
PLOT DATE: Apr 06, 2020		
DRAWING NO. FILE: 19099-PO.0.dwg		
P.0.0		
OF 16		

ORIGINAL DRAWING SIGNED BY: DWAYNE C. SUDNEEKS
DATE ORIGINAL SIGNED: Mar 05, 2020
ORIGINAL ON FILE AT ENGINEERED SYSTEMS ASSOCIATES
1355 EAST CENTER, POCATELLO, IDAHO 83201

Engineered Systems Associates
1355 EAST CENTER
POCATELLO, IDAHO 83201
PHONE: (208) 233-0501
FAX: (208) 233-0529
EMAIL: esa@engsystems.com
ESA JOB NUMBER: 19099

