
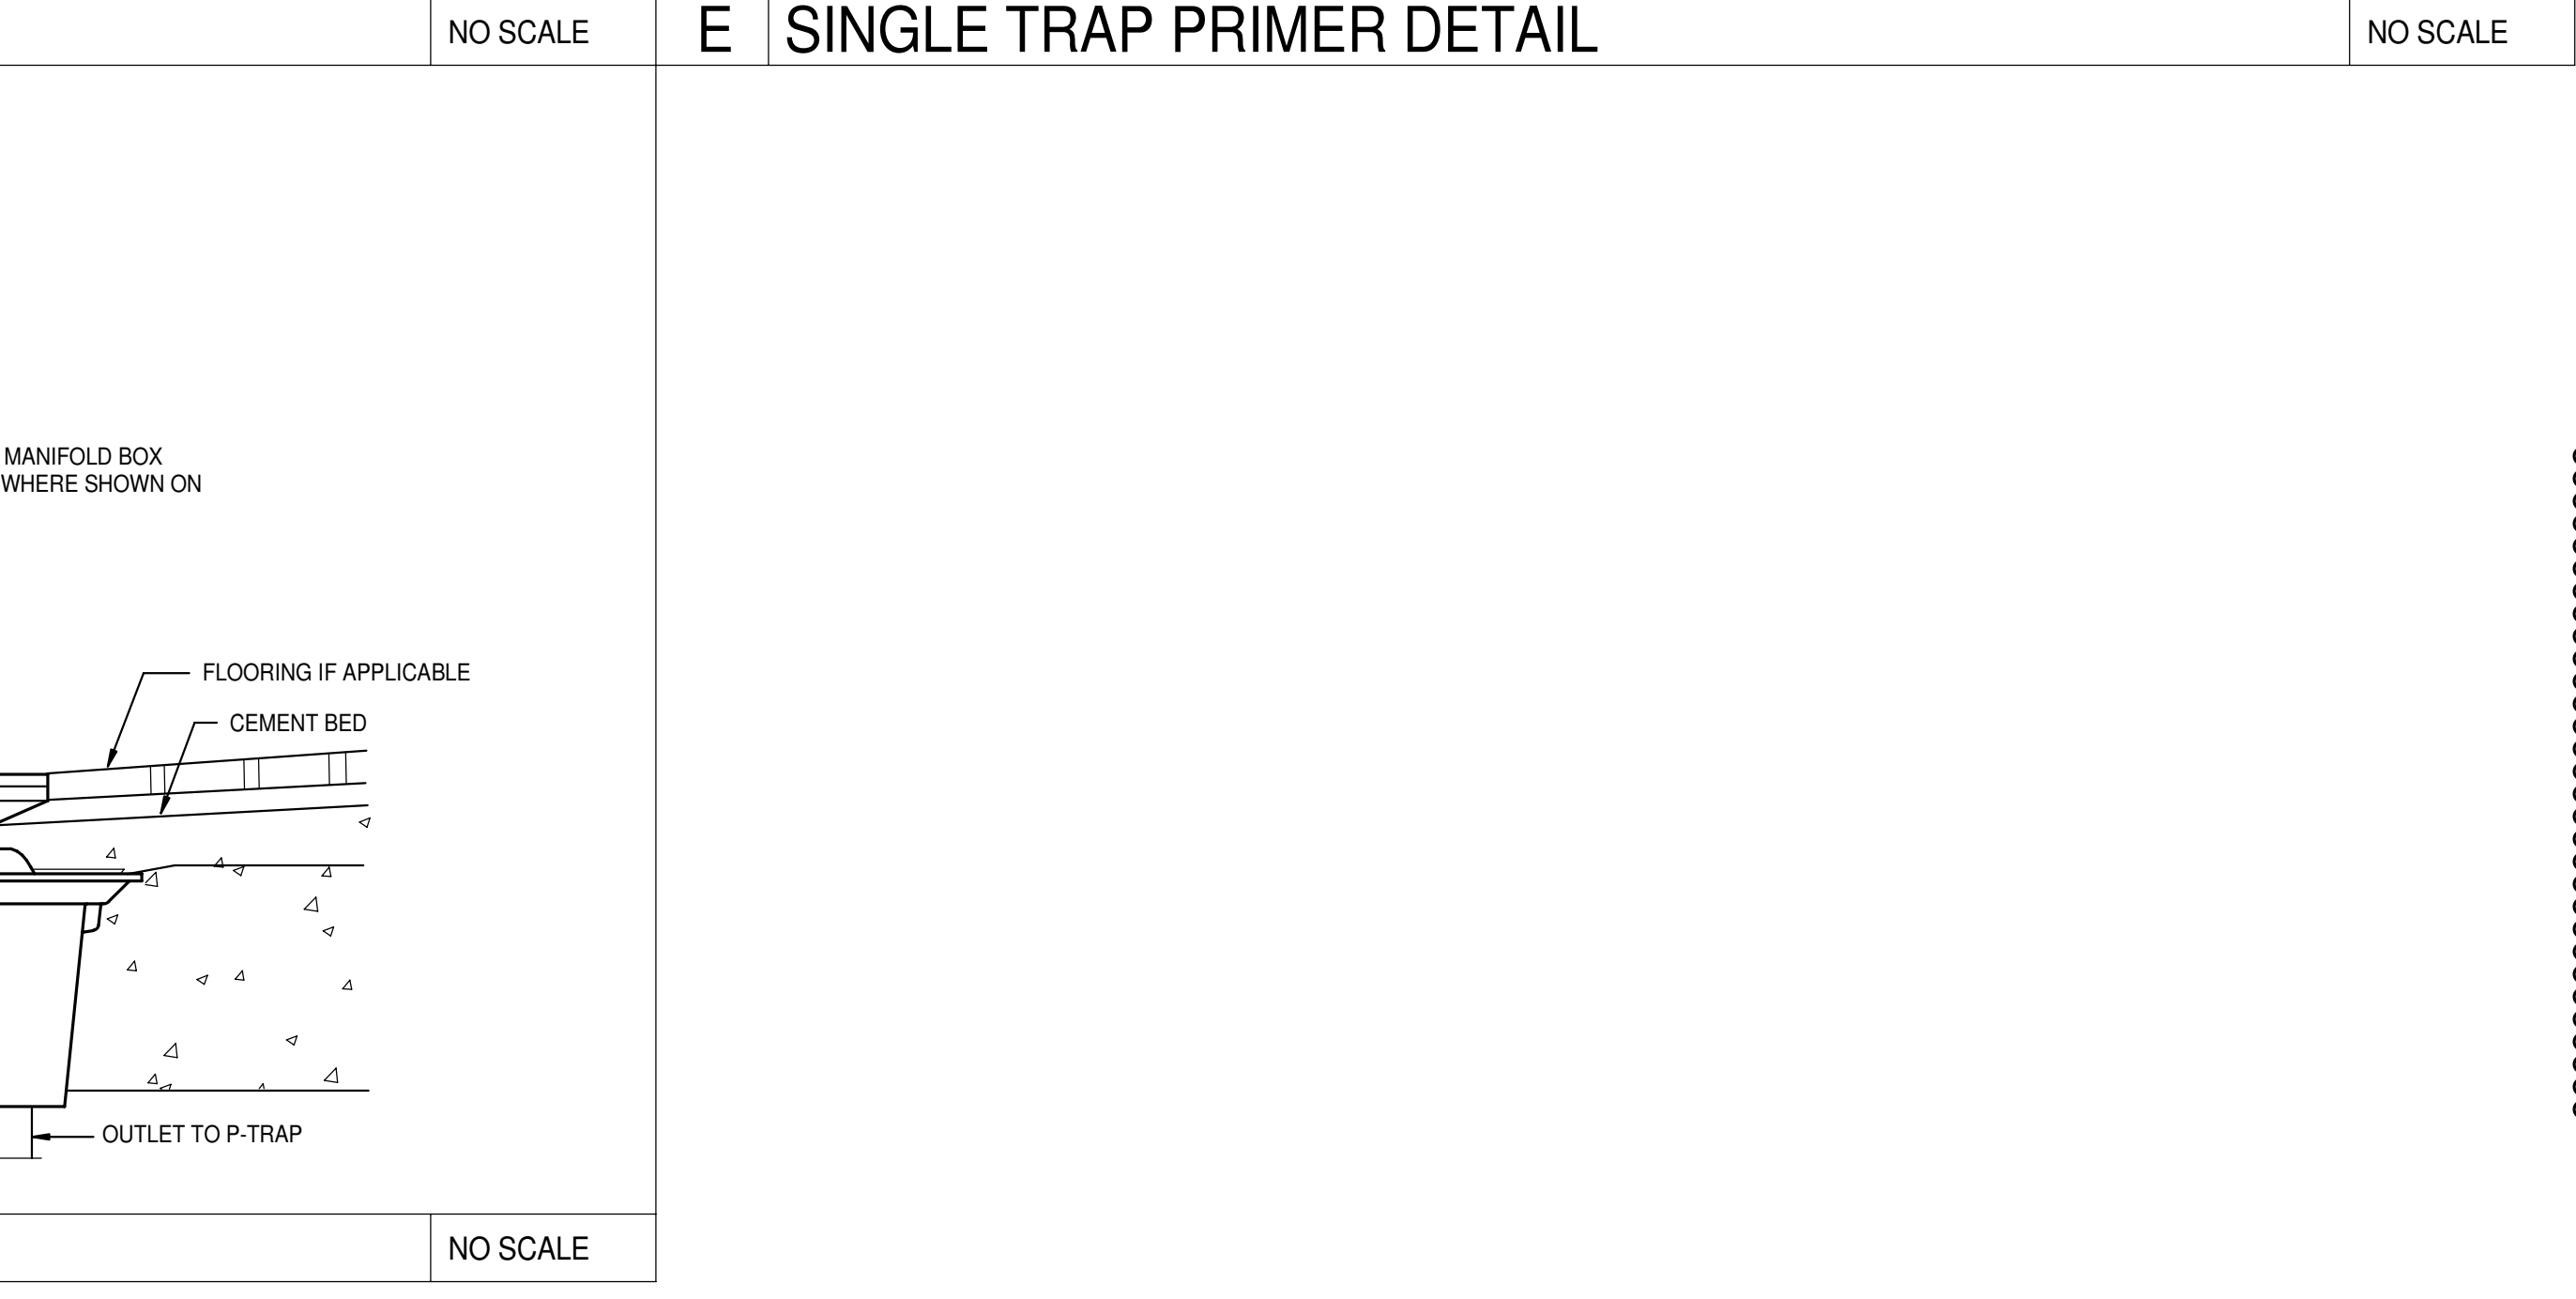
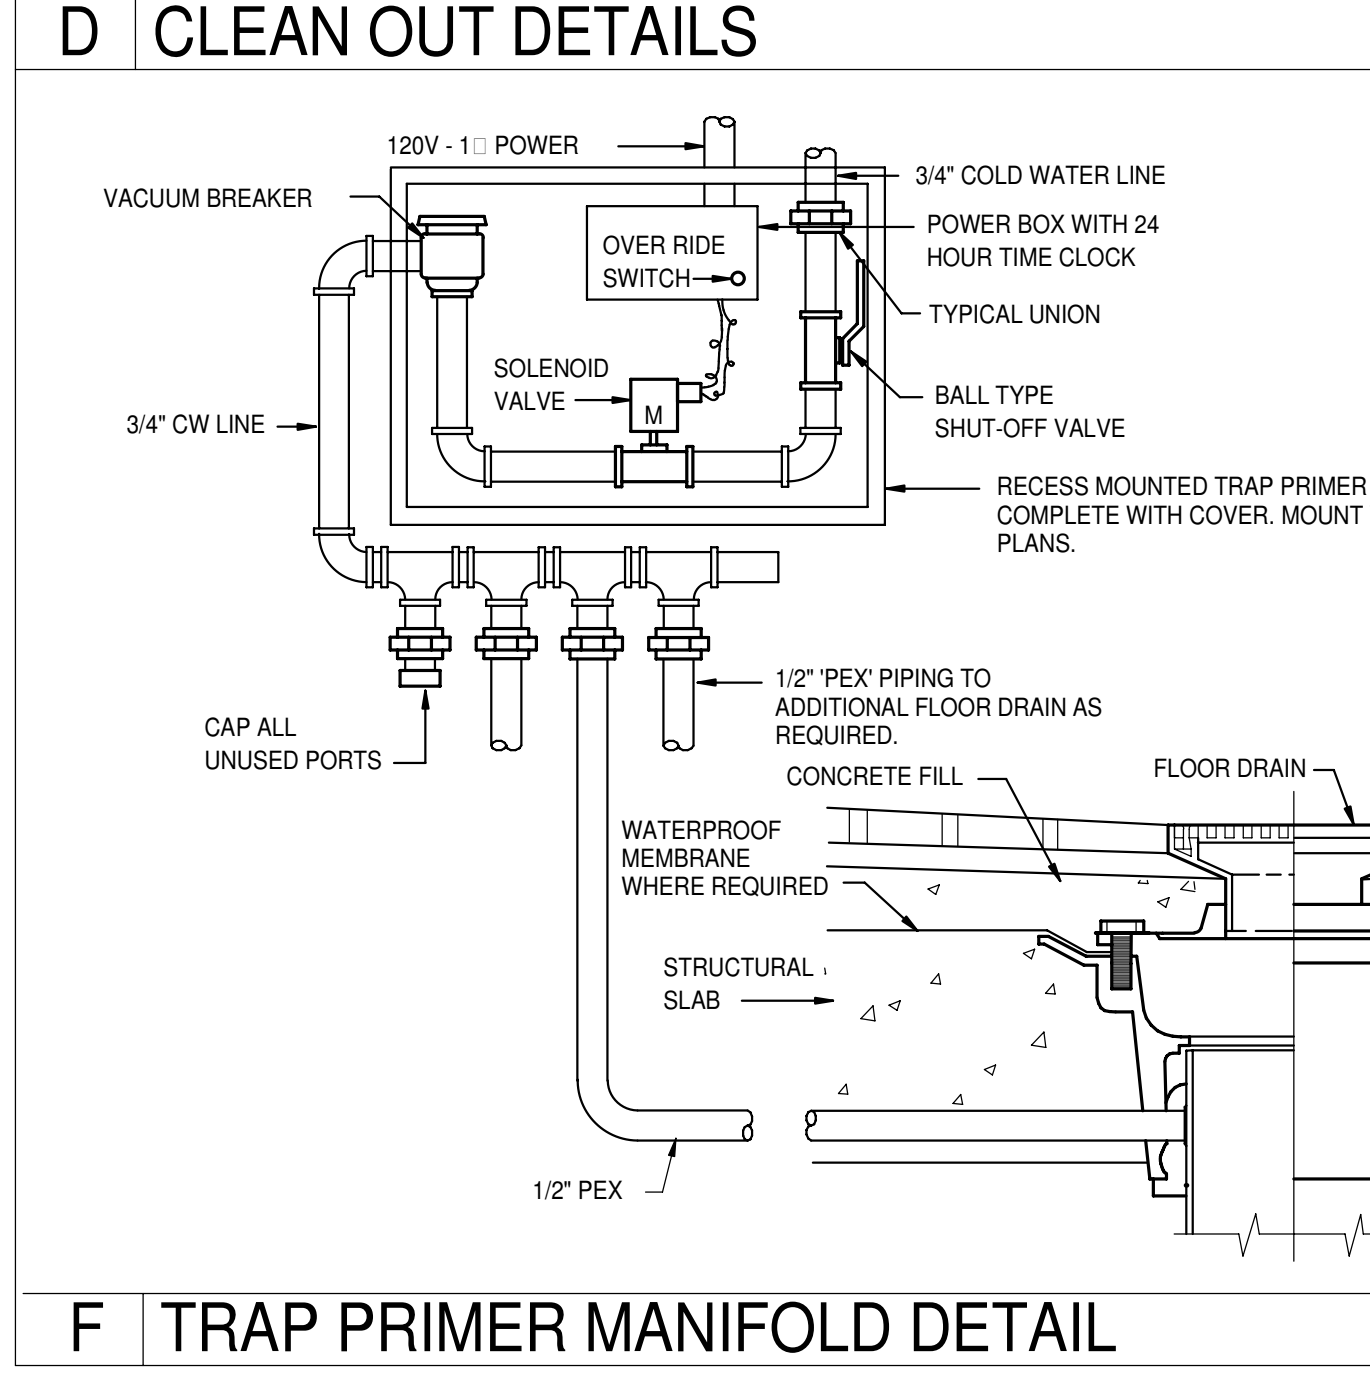
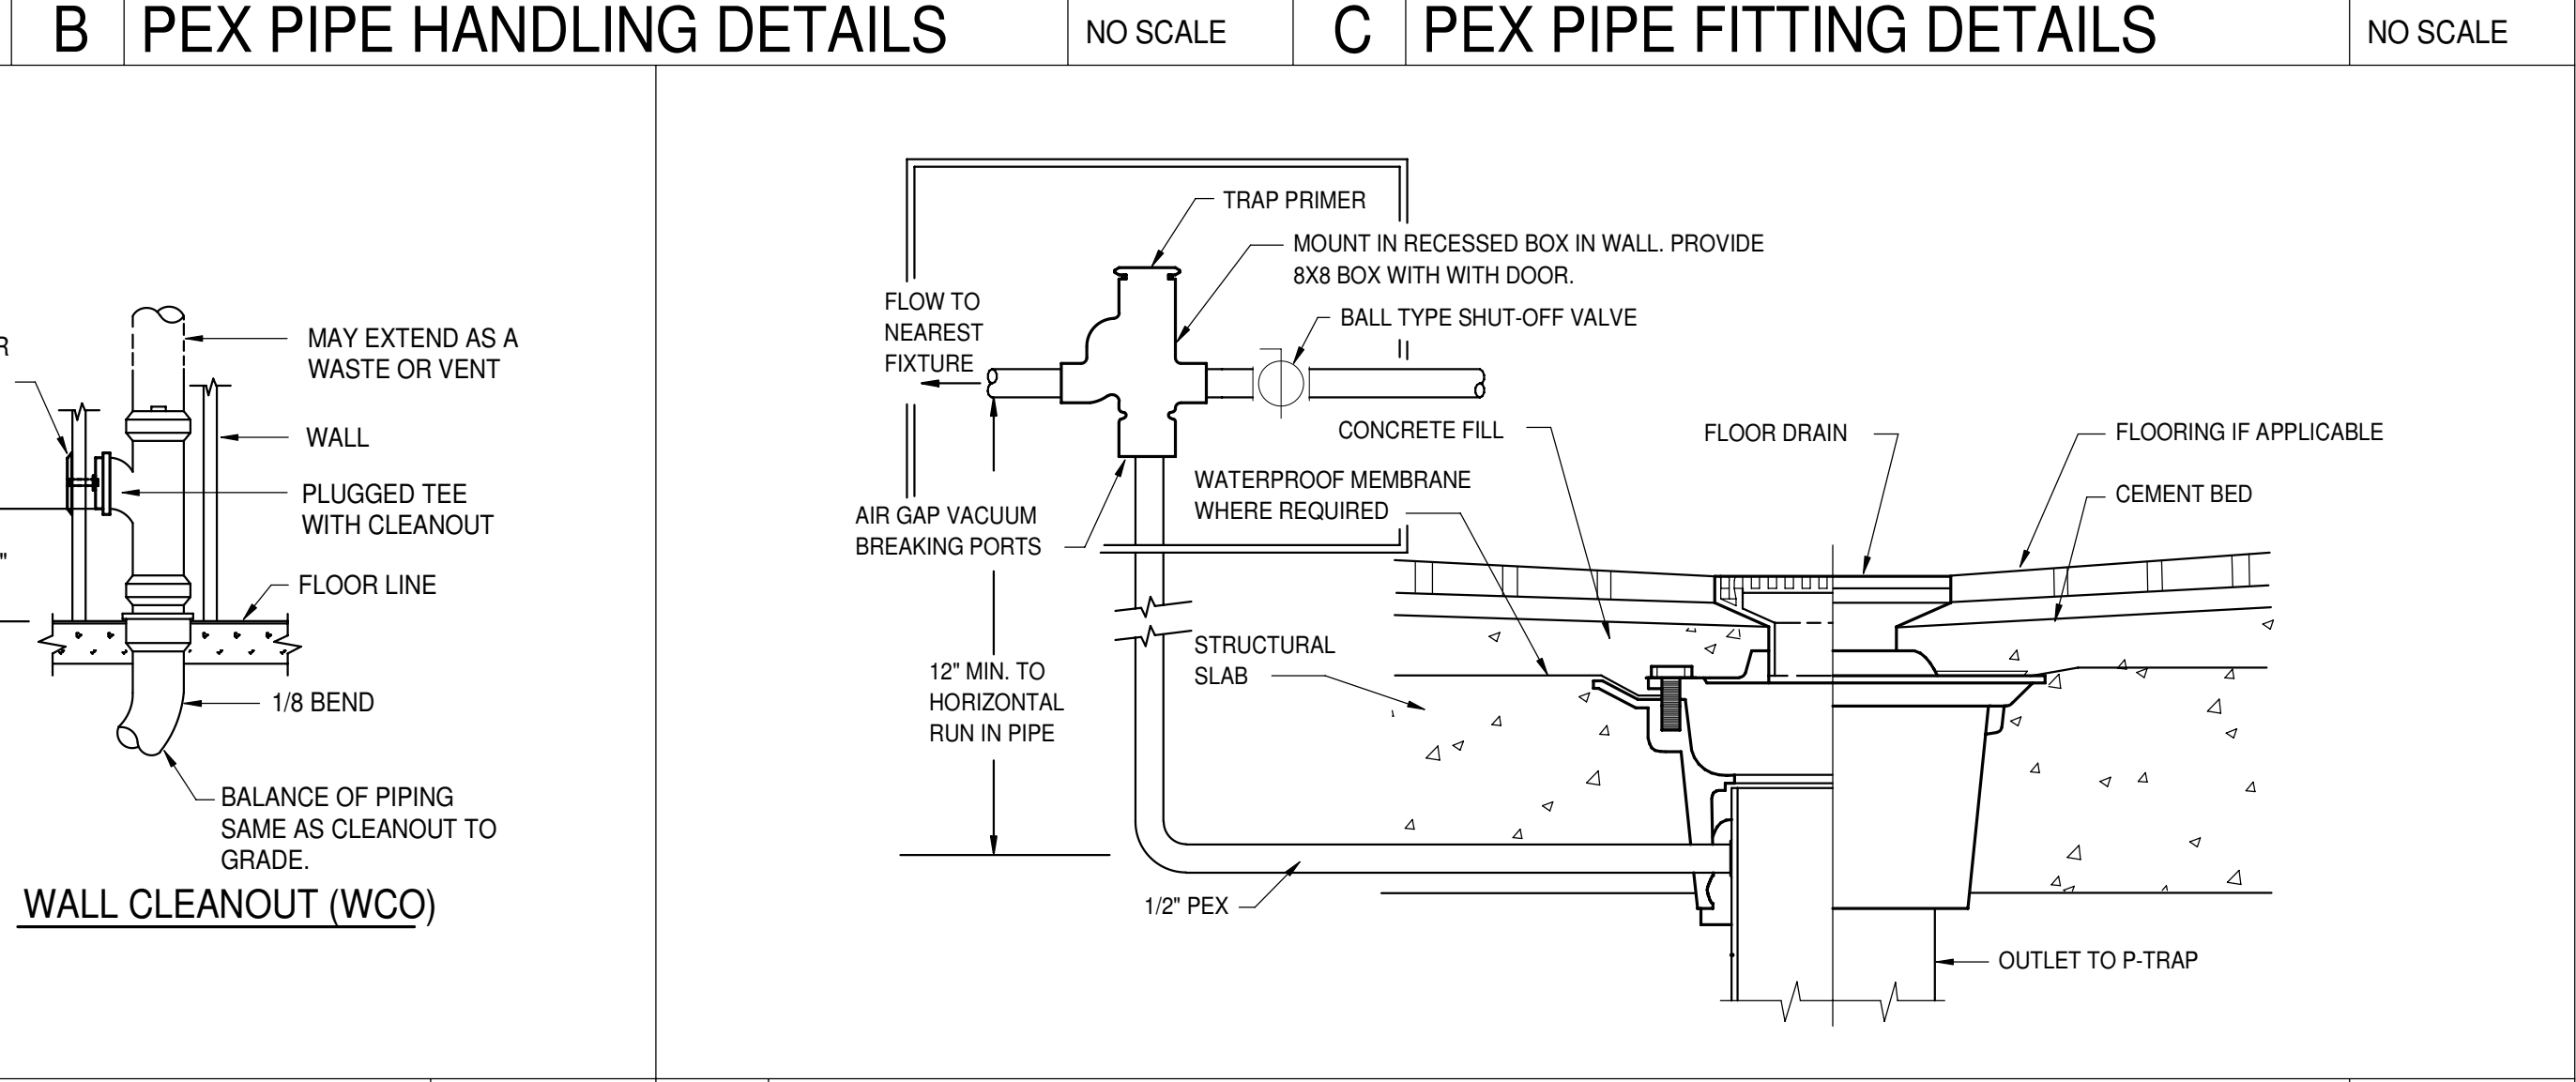


FIXTURE SCHEDULE

SYM.	DESCRIPTION	HOT	COLD	WASTE	VENT
(BF-1)	BOTTLE FILL STATION - ELKAY MODEL EZWS8MPK IN-WALL BOTTLE FILLING STATION WITH 8 GPH CAPABILITY, AND IN-WALL FRAME, 1/2" COLD WATER CONNECTION AND 1-1/2" P-TRAP. (115601)	---	1/2"	1-1/2"	1-1/2"
(FD-1)	2" FLOOR DRAIN - ZURN MODEL Z-415 WITH 5" NICKEL-BRONZE STRAINER AND 2" DEEP SEAL P-TRAP. PROVIDE WITH TRAP PRIMER CONNECTION. REFER TO DETAILS P/P301 AND T/P301 FOR TYPICAL INSTALLATION AND COLD WATER LINE CONNECTION.	---	1/2"	2"	2"
(JS-1)	FLOOR MOUNTED SERVICE SINK - KOHLER K-6710 "WHITBY" WITH K-8940 WIRE RIM GUARD, K-8928 FAUCET ASSEMBLY AND K-9147 DRAIN ASSEMBLY WITH 2" DEEP SEAL P-TRAP.	1/2"	1/2"	2"	2"
(L-1)	WALL HUNG LAVATORY - KOHLER K-2032 "GREENWICH" (SIZE 20x18) WITH K-13885 OFFSET OPEN GRID STRAINER, K-13460-VS TOUCHLESS FAUCET WITH MIXING VALVE (BATTERY), WALL CARRIER, 1/2" STOPS AND 1-1/2" P-TRAP. PROVIDE INSULATING JACKET ON WATER AND WASTE PIPING.	1/2"	1/2"	1-1/2"	1-1/2"
(L-2)	INTEGRAL LAVATORY - PROVIDE AND INSTALL KOHLER K-1715 OPEN GRID STRAINER, DECK MOUNTED K-13460-VS TOUCHLESS FAUCET WITH MIXING VALVE (BATTERY), 1/2" STOPS AND 1-1/2" P-TRAP. PROVIDE INSULATING JACKET ON WATER AND WASTE PIPING.	1/2"	1/2"	1-1/2"	1-1/2"
(S-1)	SINGLE COMPARTMENT SINK - ELKAY MODEL 1918 WITH LK1000CR LEVER HANDLER FAUCET, DUO-STRAINER, 1/2" STOPS AND 1-1/2" P-TRAP.	1/2"	1/2"	1-1/2"	1-1/2"
(S-2)	DOUBLE COMPARTMENT SINK - ELKAY MODEL 2519 WITH LK1000CR LEVER HANDLER FAUCET, (2) DUO-STRAINERS, 1/2" STOPS AND 1-1/2" P-TRAP.	1/2"	1/2"	1-1/2"	1-1/2"
(SH-1)	ADA SHOWER - MOEN MODEL T8342 SHOWER TRIM PACKAGE WITH CLASSIC BRUSHED NICKEL FINISH, PRESSURE BALANCING VALVE WITH LEVER, STATIONARY SHOWER HEAD AND HAND HELD SHOWER HEAD WITH SLIDE BAR, 60" FLEXIBLE METAL HOSE AND DIVERTER VALVE. PROVIDE INTEGRATED DRAIN AND STRAINER. SIMILAR TO 'SCHLUTER KERDI' IN BOTTOM OF SHOWER STALL WITH 2" P-TRAP.	1/2"	1/2"	2"	2"
(SH-2)	SHOWER - MOEN MODEL TL182 SHOWER TRIM PACKAGE WITH CLASSIC BRUSHED NICKEL FINISH, PRESSURE BALANCING VALVE WITH LEVER AND STATIONARY SHOWER HEAD. PROVIDE INTEGRATED DRAIN AND STRAINER. SIMILAR TO 'SCHLUTER KERDI' IN BOTTOM OF SHOWER STALL WITH 2" P-TRAP.	1/2"	1/2"	2"	2"
(TP-1)	TRAP PRIMER FOR SINGLE DRAIN - ZURN MODEL Z-1022XL IN-LINE PRIMER. MOUNT RECESSED IN WALL BELOW SINK OR LAVATORY WHERE SHOWN ON PLANS. RUN 1/2" COLD WATER LINE BELOW FLOOR TO SINGLE FLOOR DRAIN. REFER TO DETAIL T/P301 FOR TYPICAL INSTALLATION.	---	1/2"	---	---
(TP-2)	TRAP PRIMER FOR MULTIPLE DRAINS - ZURN Z-1022XL-S-CW ELECTRONIC TRAP PRIMER SYSTEM. MOUNT RECESSED IN WALL WITH COVER. RUN 1/2" COLD WATER LINE TO EACH TRAP AS SHOWN ON FLOOR PLANS. REFER TO DETAIL P/P301 FOR TYPICAL INSTALLATION.	---	3/4"	---	---
(U-1)	URINAL - KOHLER MODEL 4984-T "FRESHMAN" WITH SLOAN 8186 OPTIMA PLUS BATTERY POWERED SENSOR FLUSH VALVE AND WALL CARRIER. SEE ARCHITECTURAL DRAWINGS FOR MOUNTING HEIGHT	---	3/4"	2"	2"
(WC-1)	ADA WATER CLOSET - KOHLER K-96057 "HIGHCLIFF" WITH ELONGATED BOWL, K-4670-C OPEN FRONT SEAT, SLOAN 8111 OPTIMA PLUS BATTERY POWERED SENSOR FLUSH VALVE AND BOLT CAPS.	---	1"	4"	2"
(WC-2)	WATER CLOSET - KOHLER K-96053 "WELLCOMME" WITH ELONGATED BOWL, K-4670-C OPEN FRONT SEAT, SLOAN 8111 OPTIMA PLUS BATTERY POWERED SENSOR FLUSH VALVE AND BOLT CAPS.	---	1"	4"	2"

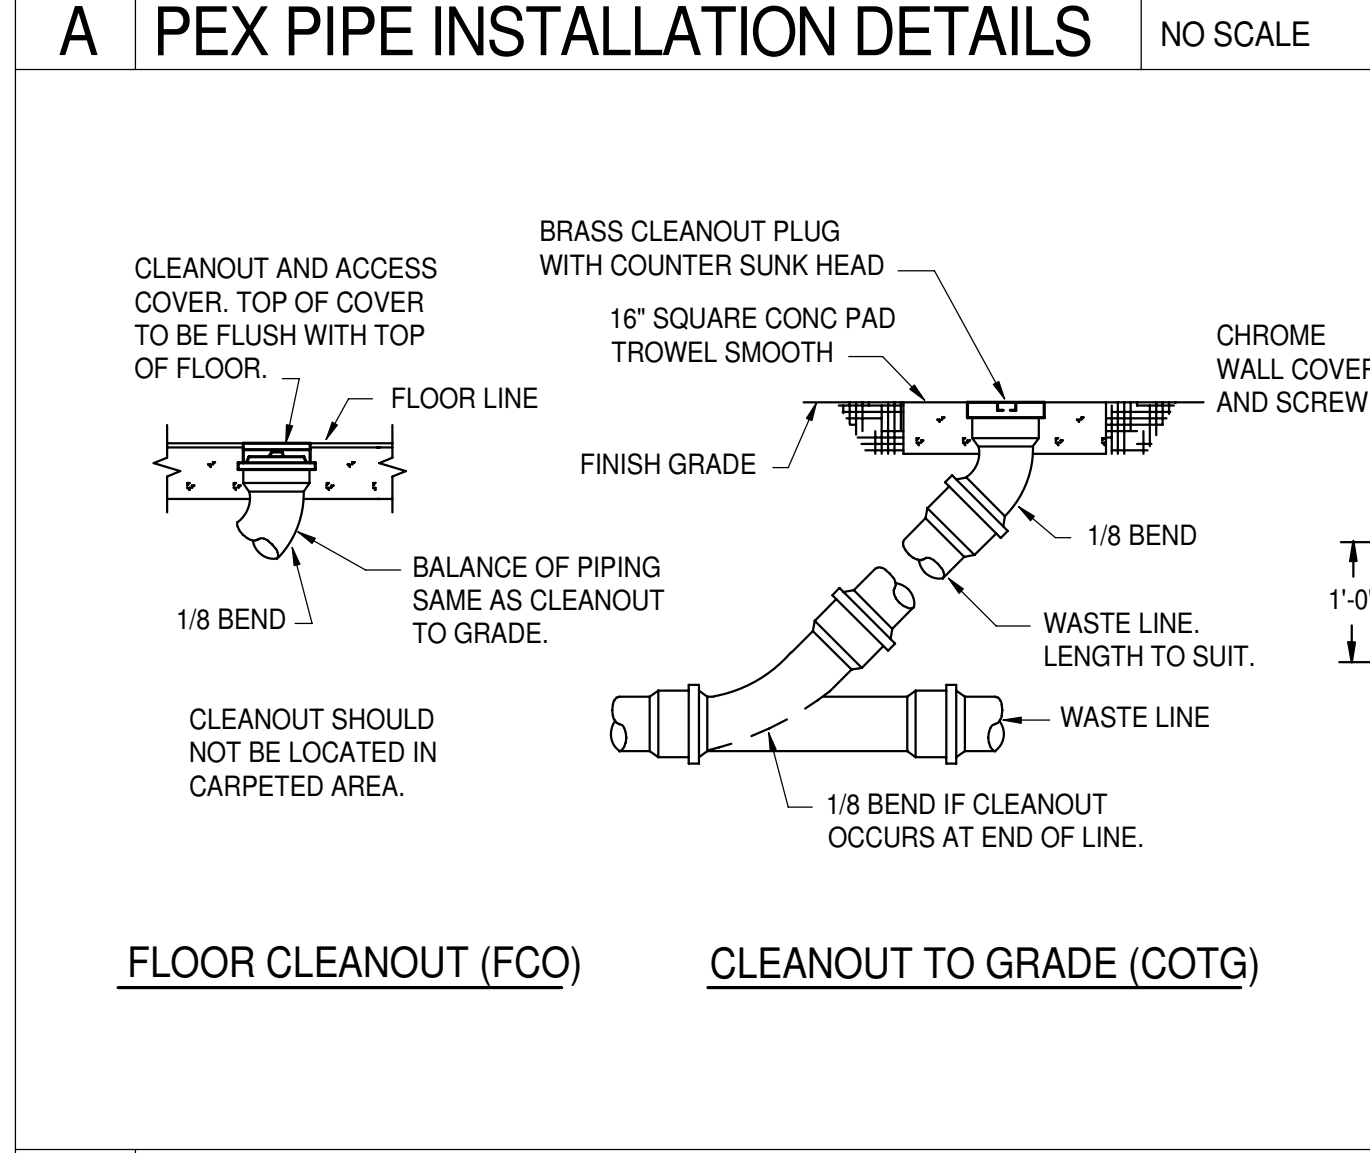

DETAILS AND SCHEDULES ARE TYPICAL FOR BOTH THE TURNER HALL PROJECT AND THE SOUTH COMPLEX PROJECT. NOT ALL DETAILS OR ALL FIXTURES MAY BE USED ON BOTH PROJECTS. REFER TO FLOOR PLANS FOR DETAIL REFERENCES AND FOR FIXTURE CALL OUTS.

AGENCY REVIEW SET

Engineered Systems Associates

1315 EAST CINDER
POCATELLO, IDAHO 83201
PHONE: (208) 233-0501
FAX: (208) 233-0529
EMAIL: esa@engsys.com
TEL #6: 21001

HUMMEL ARCHITECTS

Project:
ISU TURNER HOUSE & SOUTH COMPLEX RESTROOM REMODEL

64 Memorial Dr
Pocatello, ID 83201

DPW PROJECT NO: 21-235

Sheet:
PLUMBING FIXTURE SCHEDULE AND DETAILS

Revisions:

1	Agency Review	12/3/21
---	---------------	---------

REVIEWED FOR CODE COMPLIANCE

SEPARATE BUILDING PERMIT REQUIRED FOR CONSTRUCTION

Project No: 2045
Drawn By: M JENSEN
Checked By: D SUDWEEKS
Date: 9/15/21

Sheet No: **P3.01**