



\\PAYNEFILESERVER\Main File Storage\2020\2020 LDS Stake Center HVAC Soda Springs - 223810 Working Drawings\22381.dwg Mar 31, 2022 - 10:29am

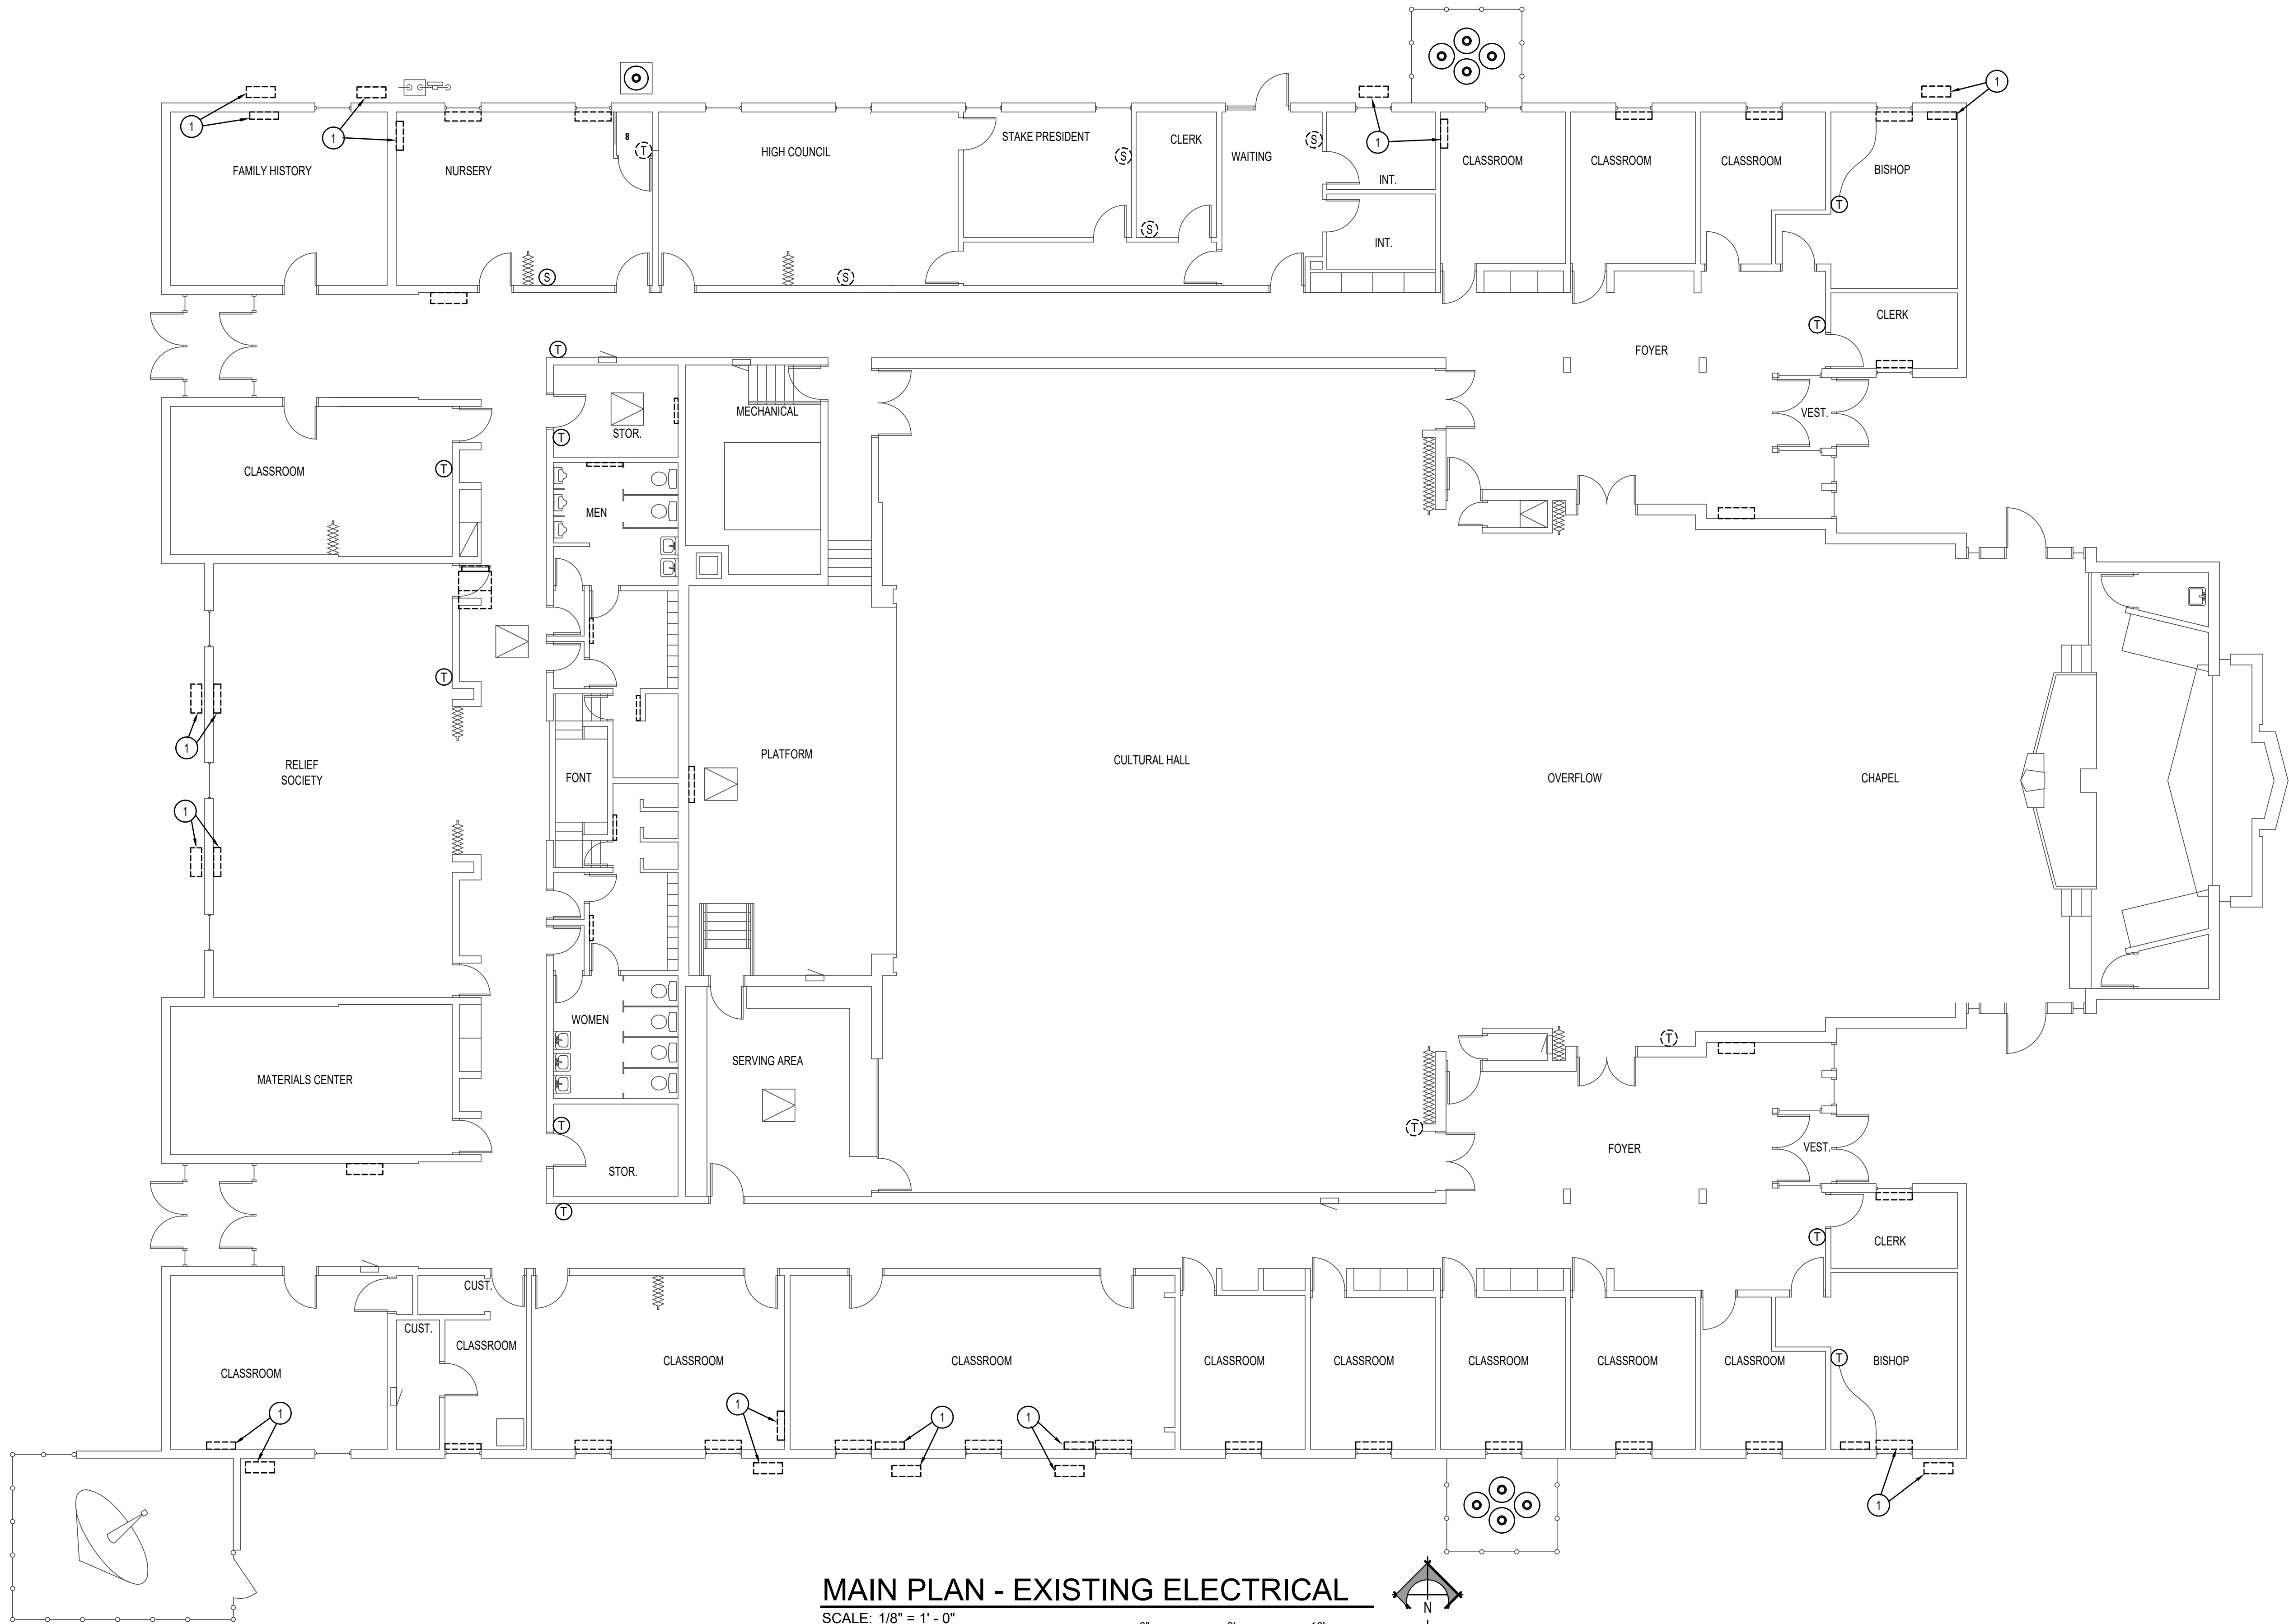

MAIN PLAN - EXISTING ELECTRICAL

SCALE: 1/8" = 1' - 0"

0" 8" 16"

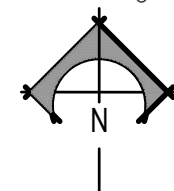

KEY NOTES

- ① DISCONNECT EXISTING SPLIT SYSTEM FOR REMOVAL. REMOVE ALL ASSOCIATED CONDUIT AND WIRE BACK TO SOURCE AND LABEL SPARE.



Engineered Systems Associates
Mechanical Engineers

Dwayne Sudweeks P.E., Dave Hansen P.E., Tanner Davis P.E.
1355 East Center - Pocatello, Idaho 83201
Phone: (208) 233-0501 Fax: (208) 233-0529 email: esa@ergsystems.com

PROPERTY # 501-3917


HVAC RENOVATIONS FOR:

LDS SODA SPRINGS 2, 6 & STAKE

290 S. 3RD W., SODA SPRINGS, IDAHO 83276

PROJECT

SHEET TITLE:
EXISTING ELECTRICAL PLAN

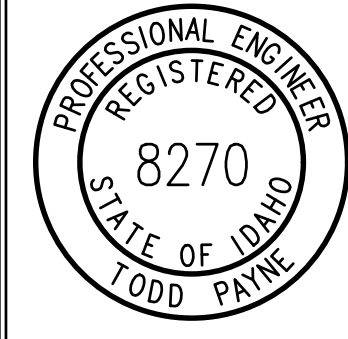

ORIGINAL SIGNED BY:
TODD E. PAYNE
DATED ORIGINAL SIGNED:
3-28-2022
ON FILE AT:
PAYNE ENGINEERING INC.

P.E. JOB #2010

IPAYNE
Engineering Inc.
Consulting Engineers

1823 E. Center
Pocatello, Idaho 83201
tel (208) 232-4439
www.payneengineeringinc.com

DRWN. BY:	CKD. BY:
MMP	TBP
JOB NO.	DATE:
21041	FEB. 2020

SHEET:
E-1.0
OF: