
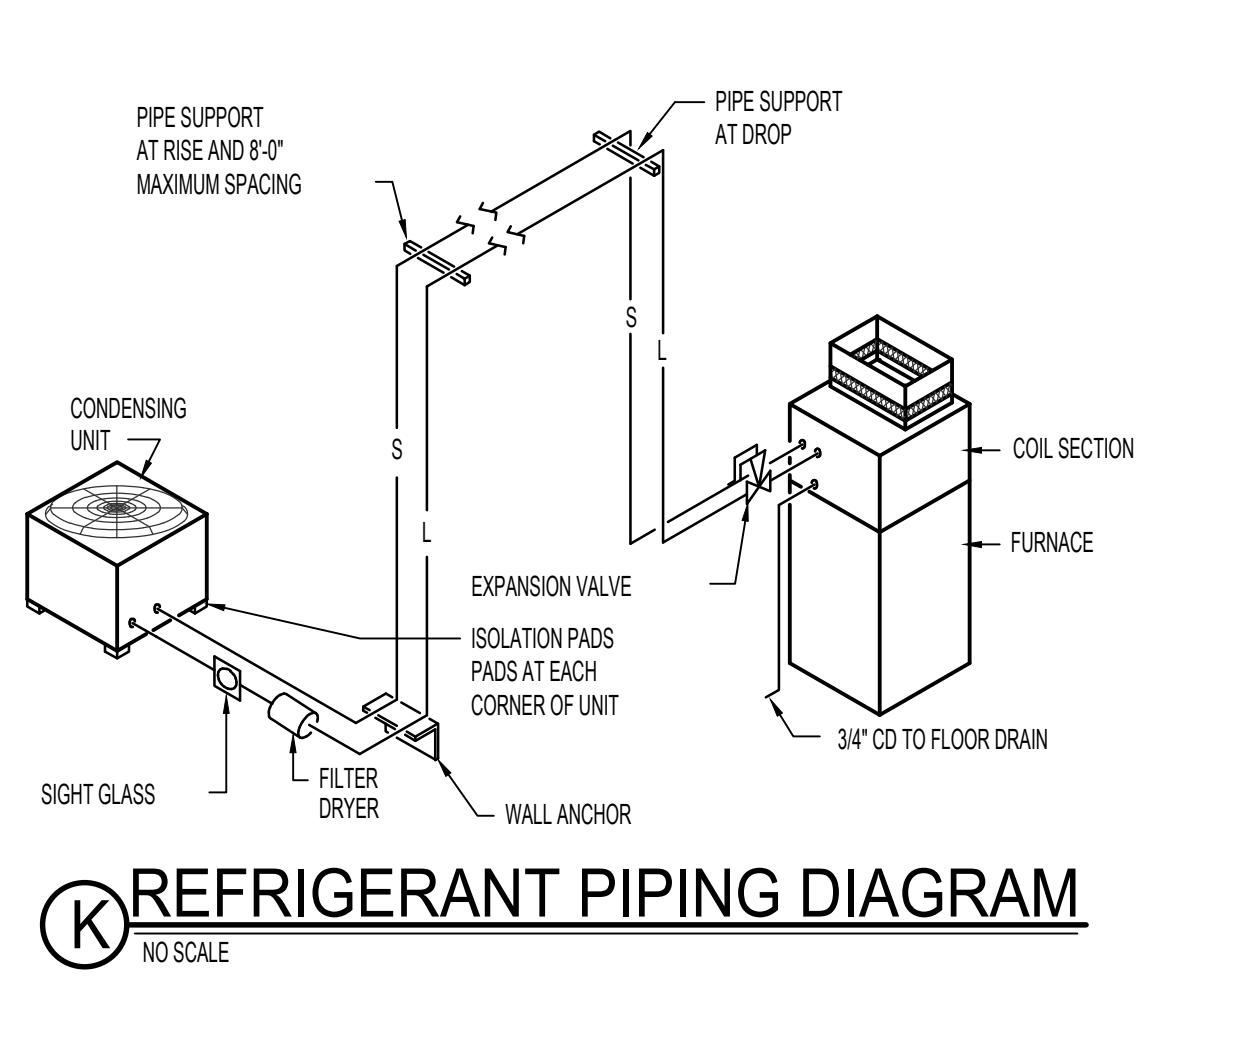
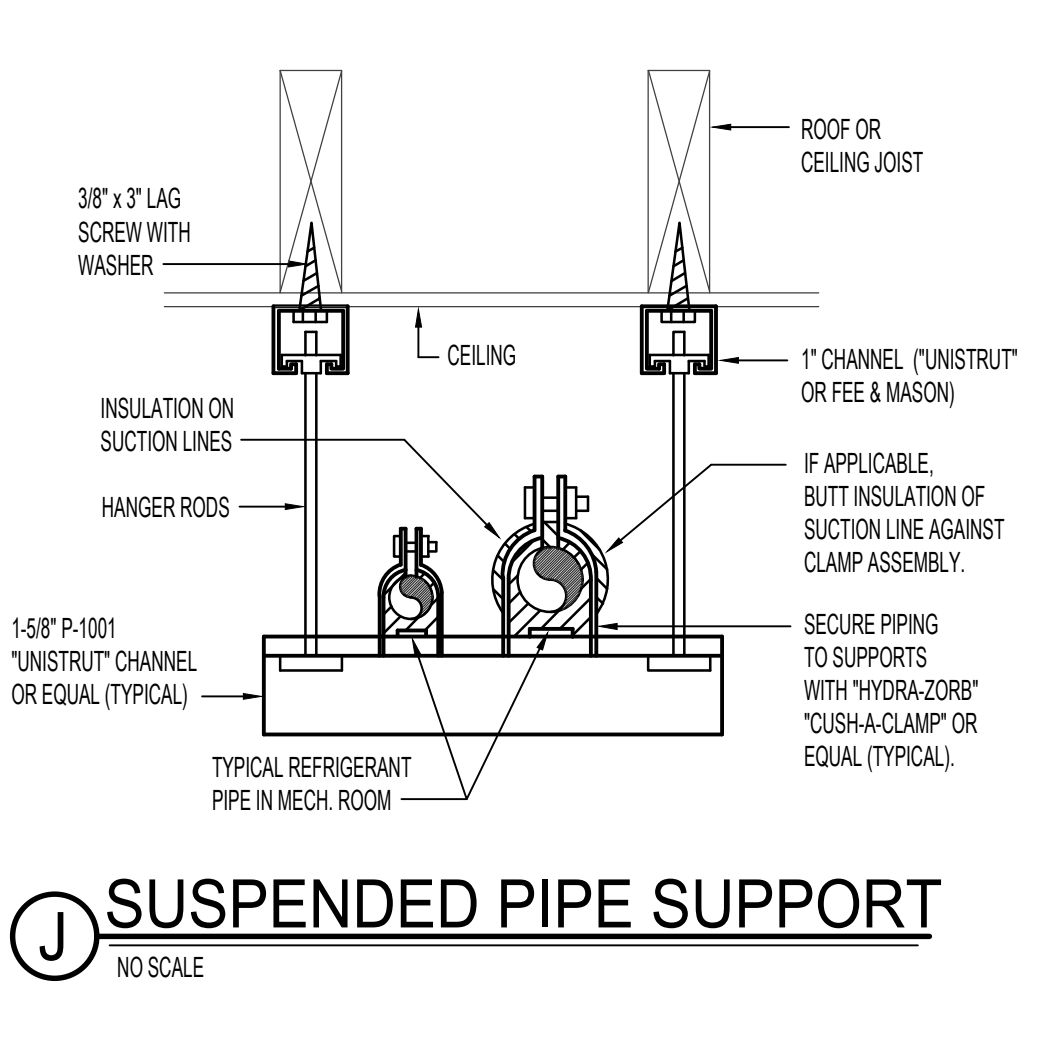
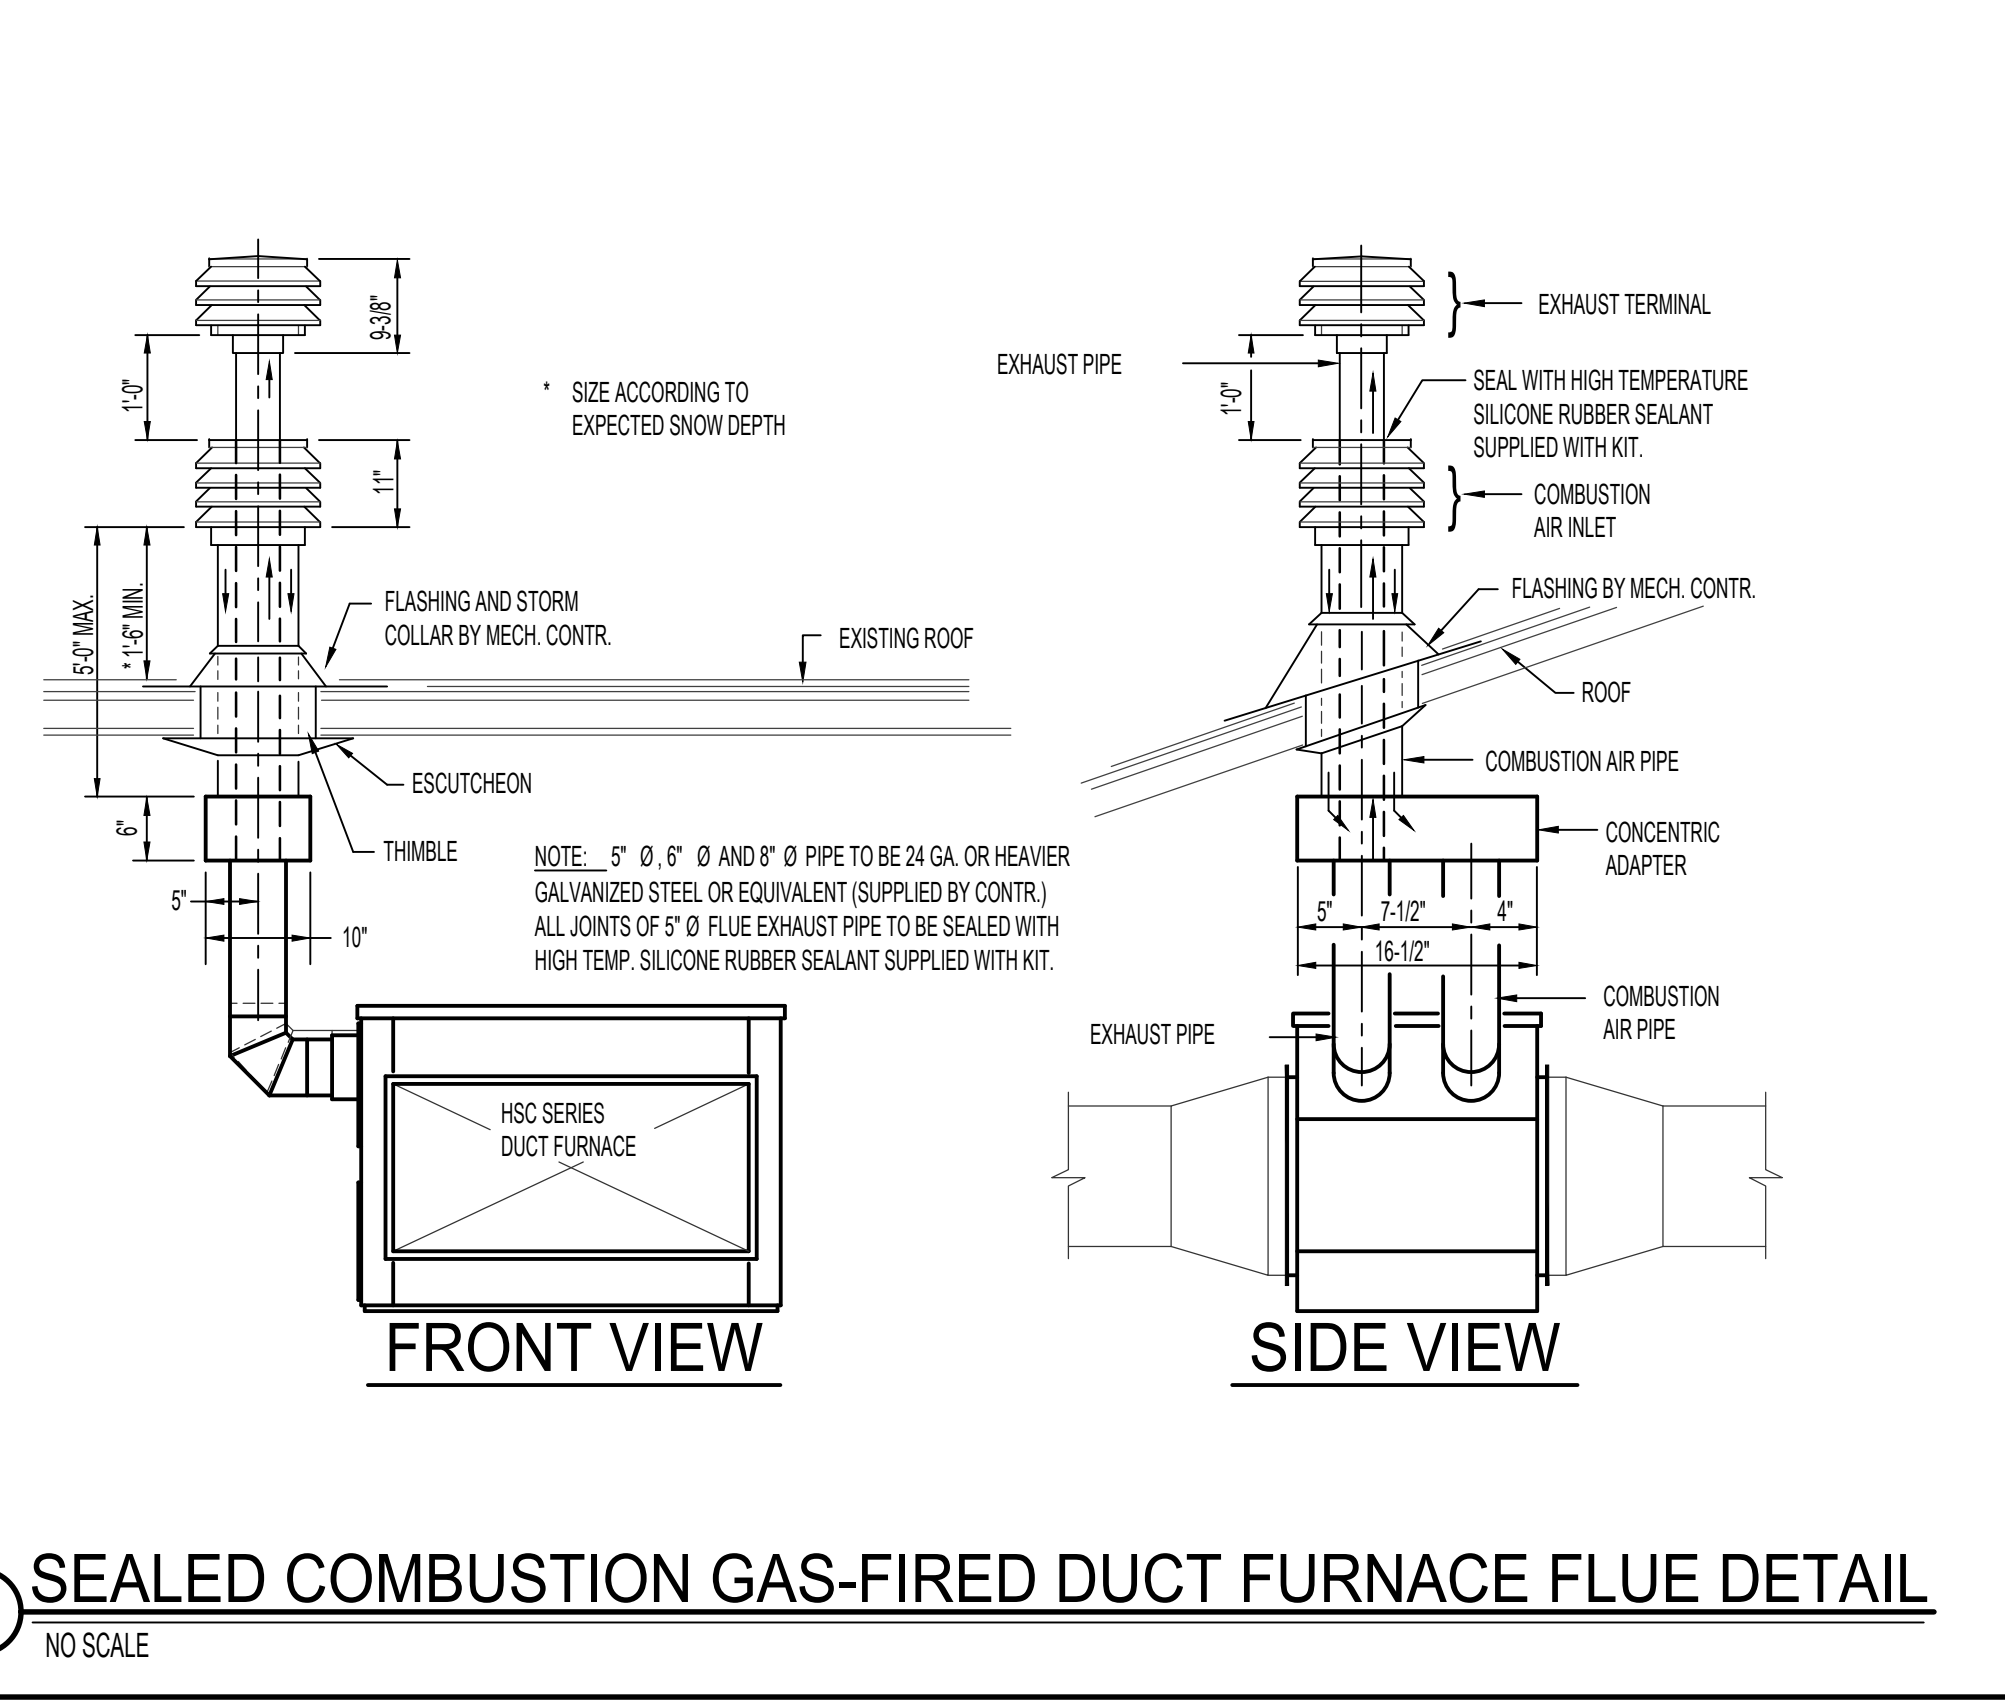
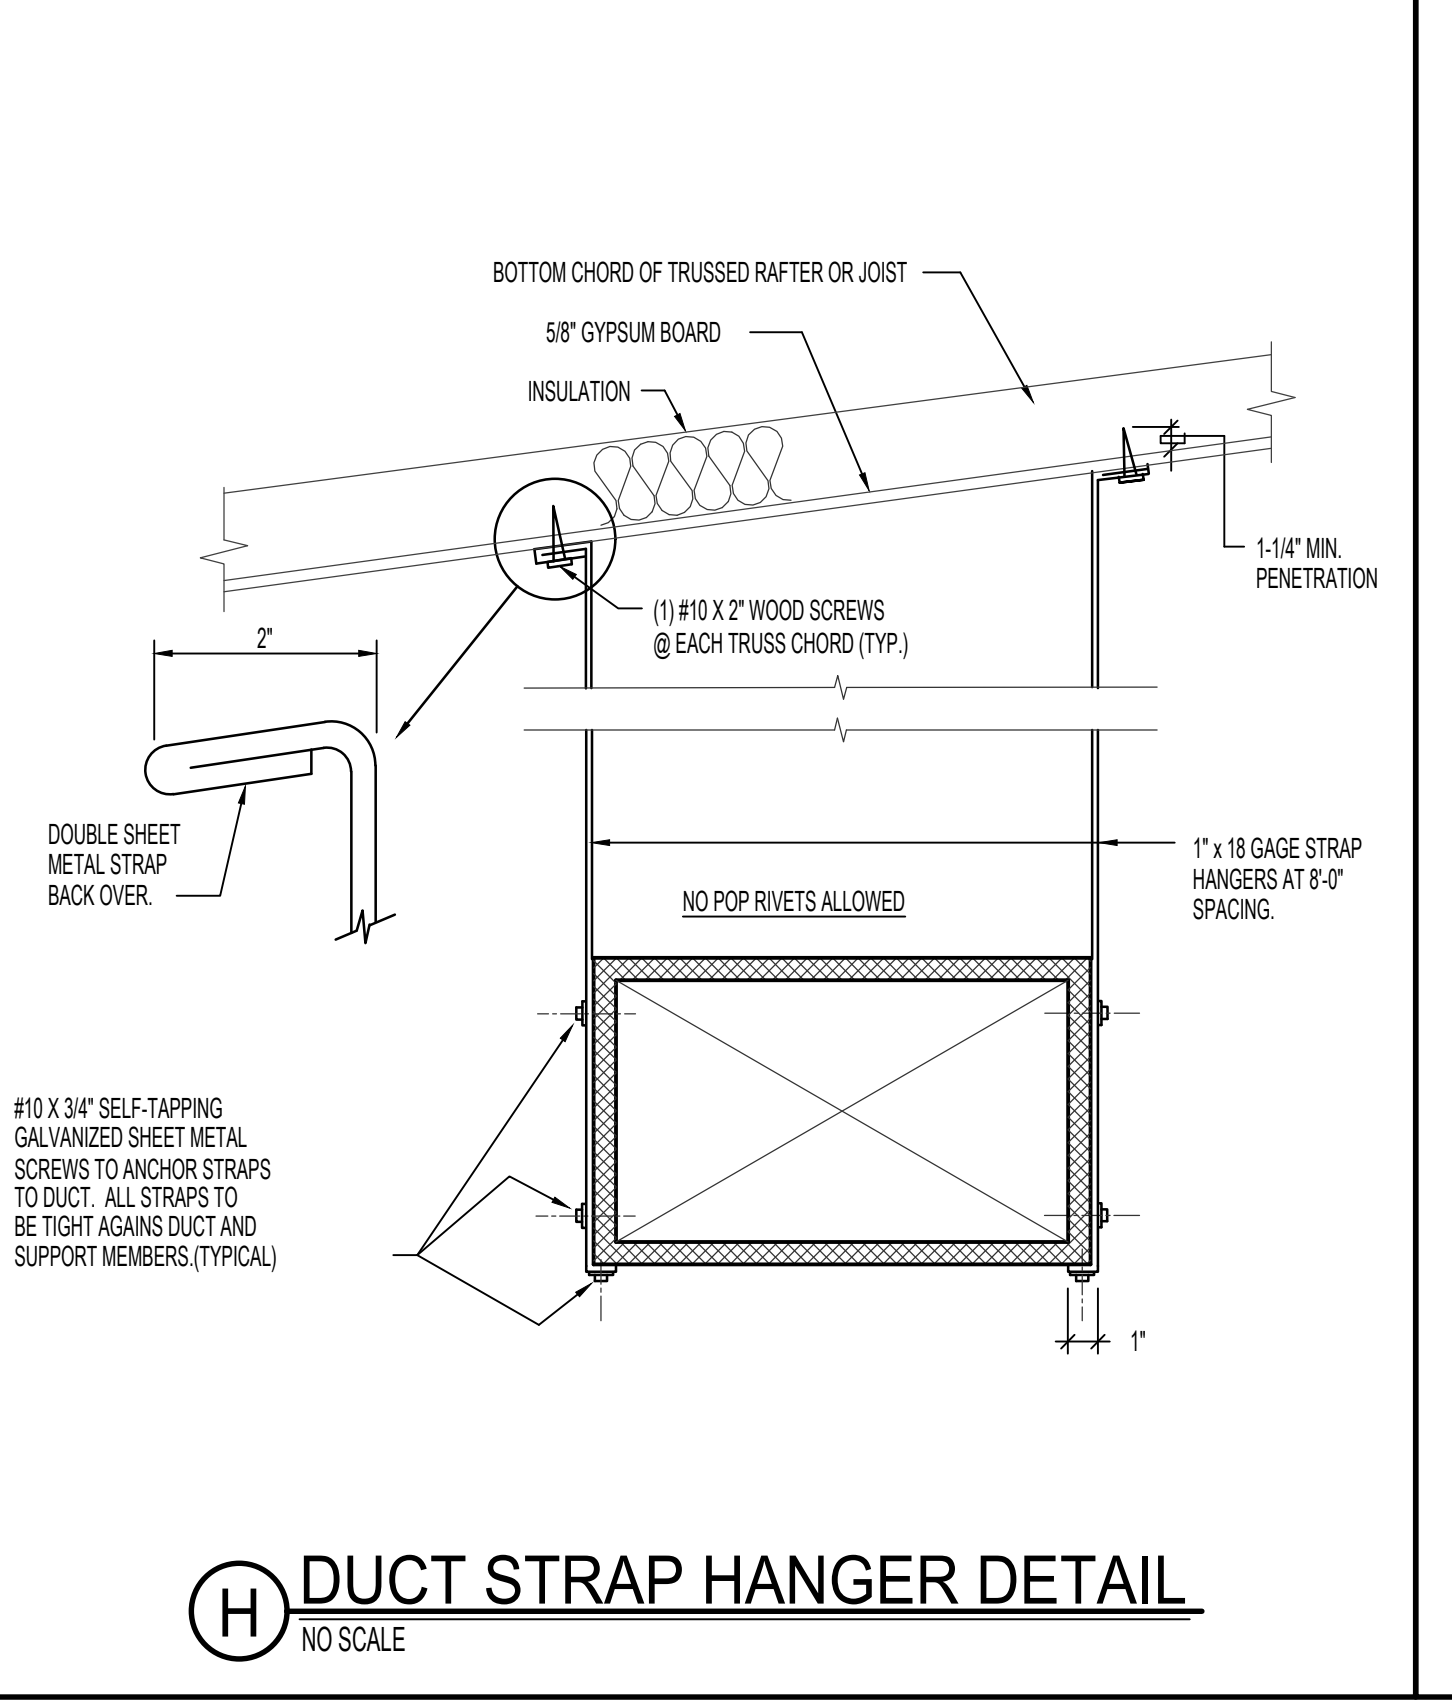
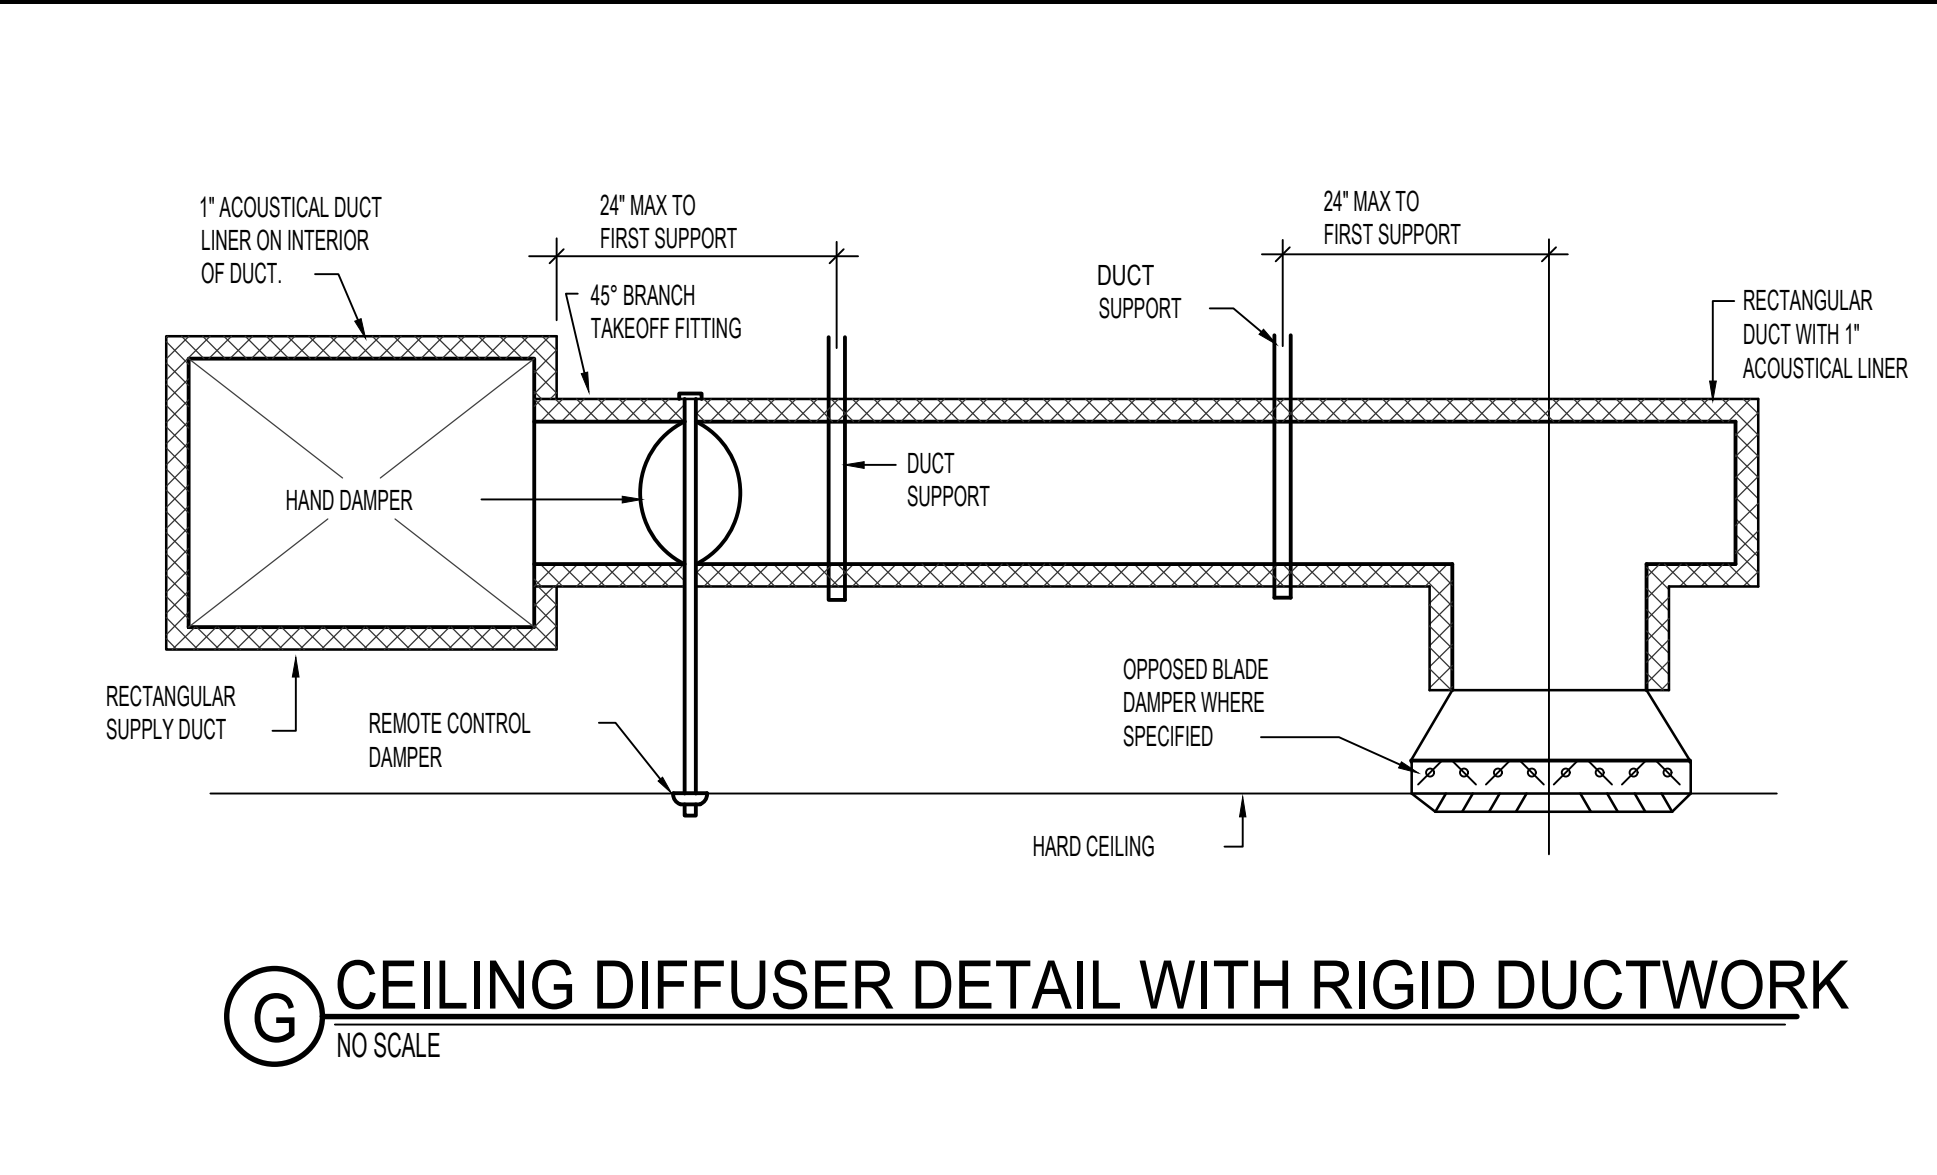
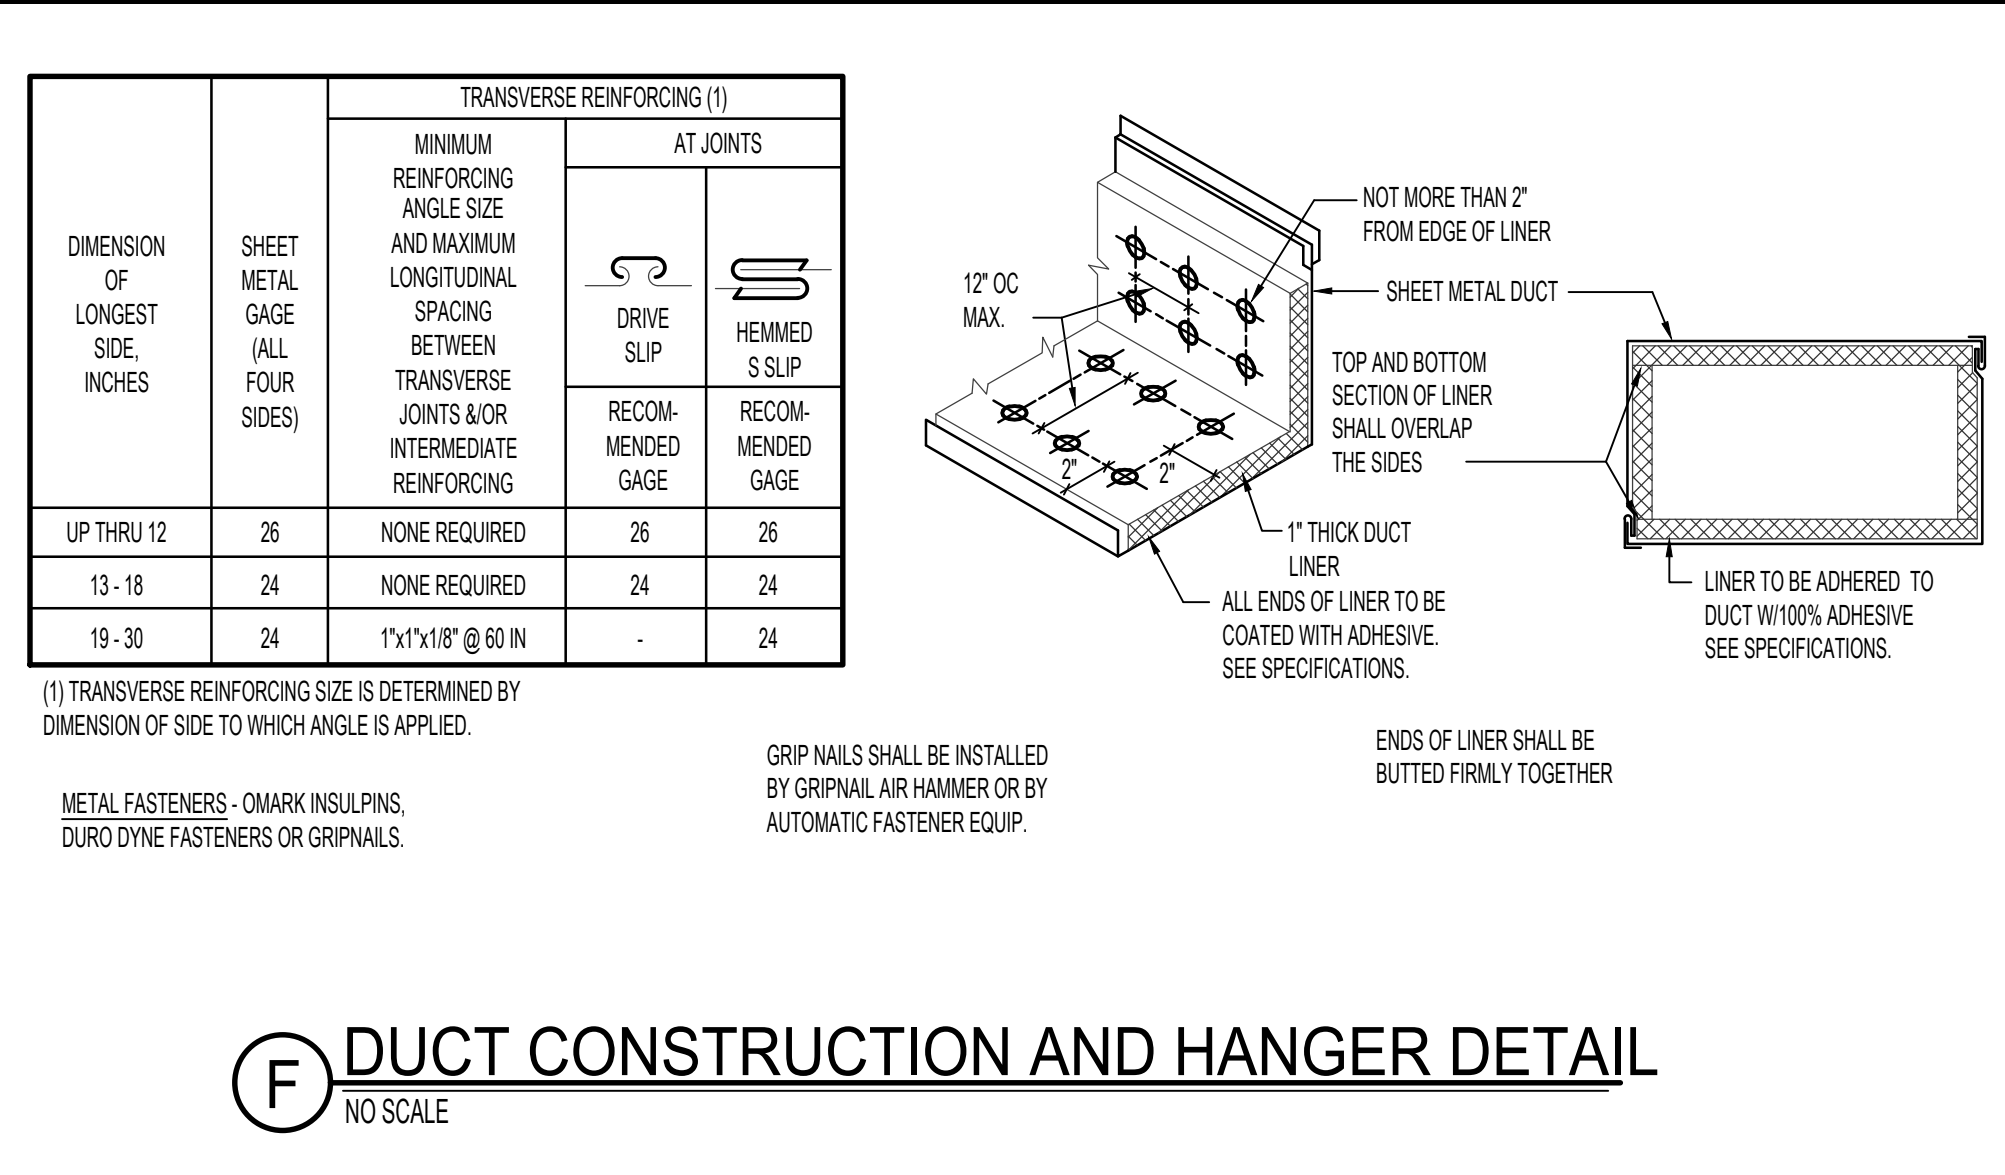
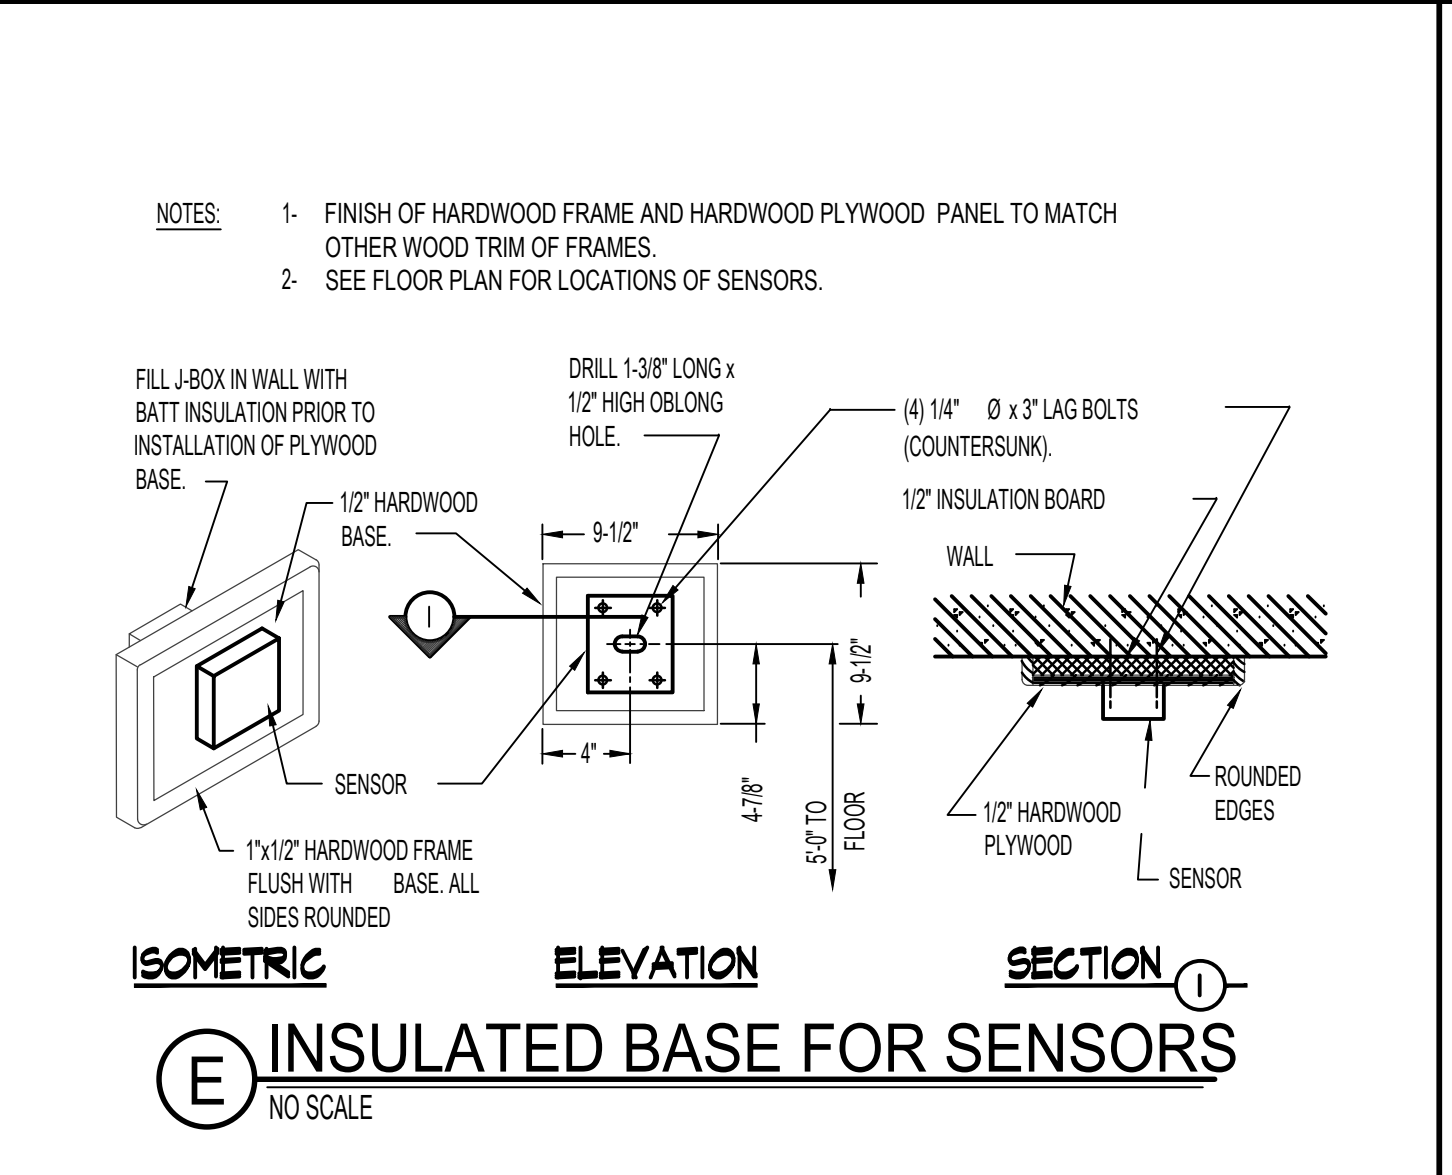
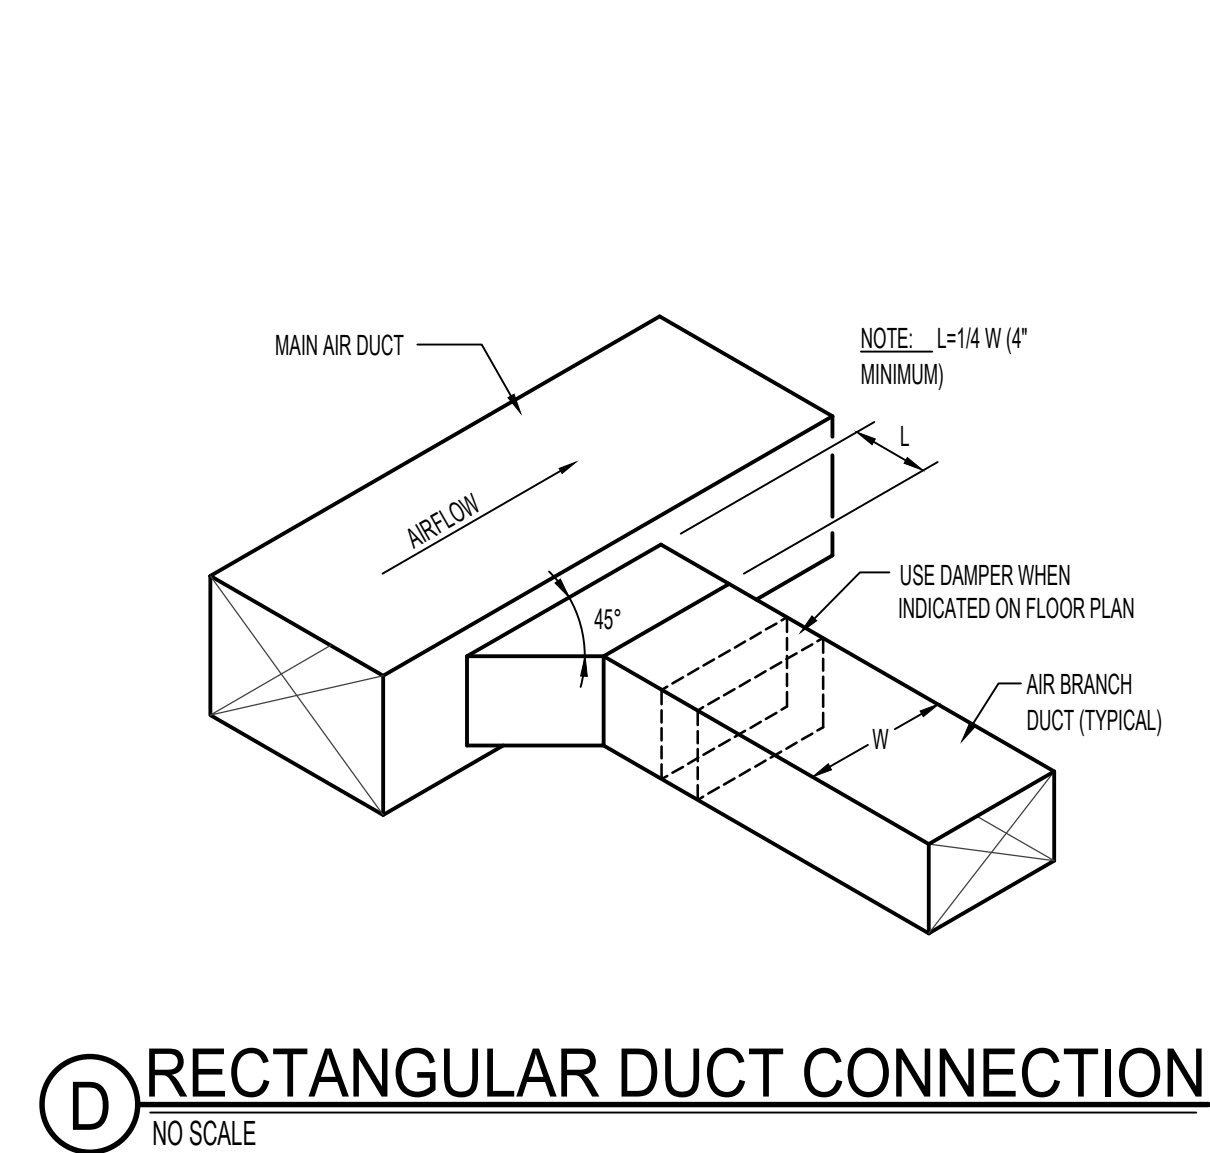
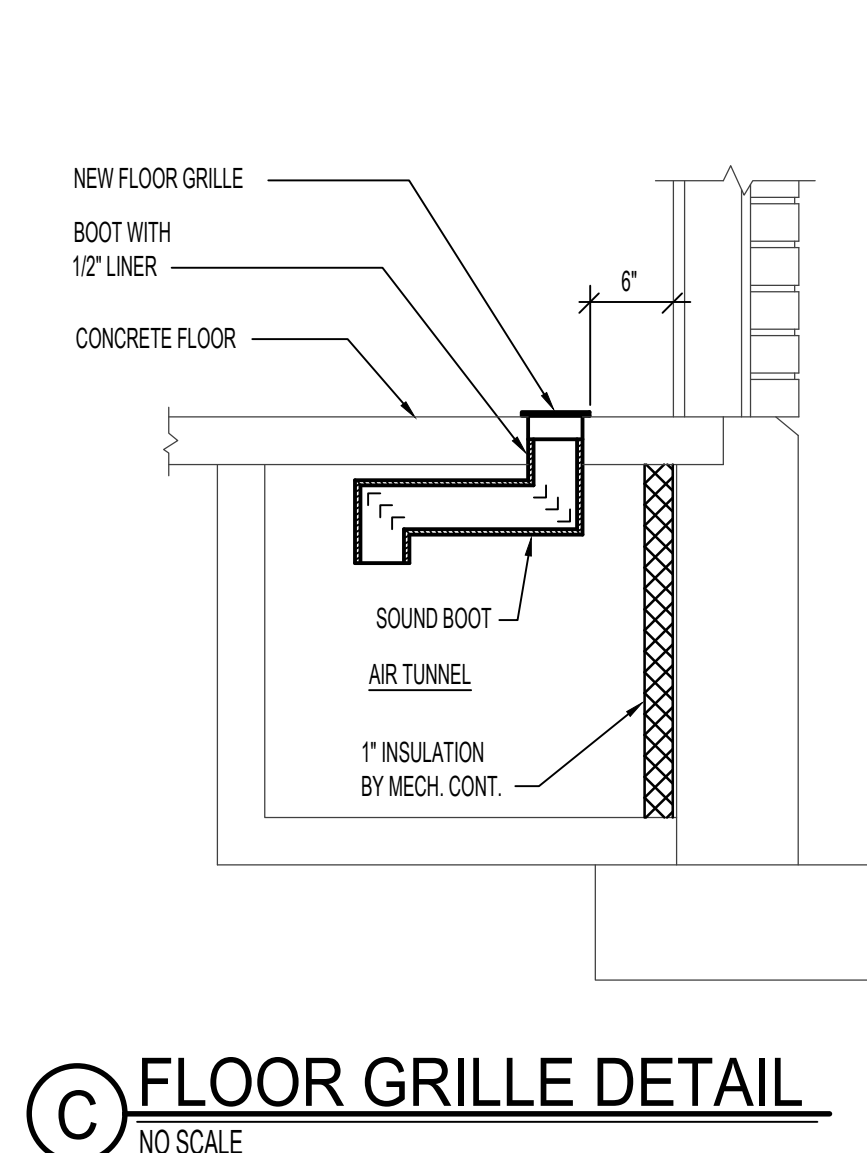
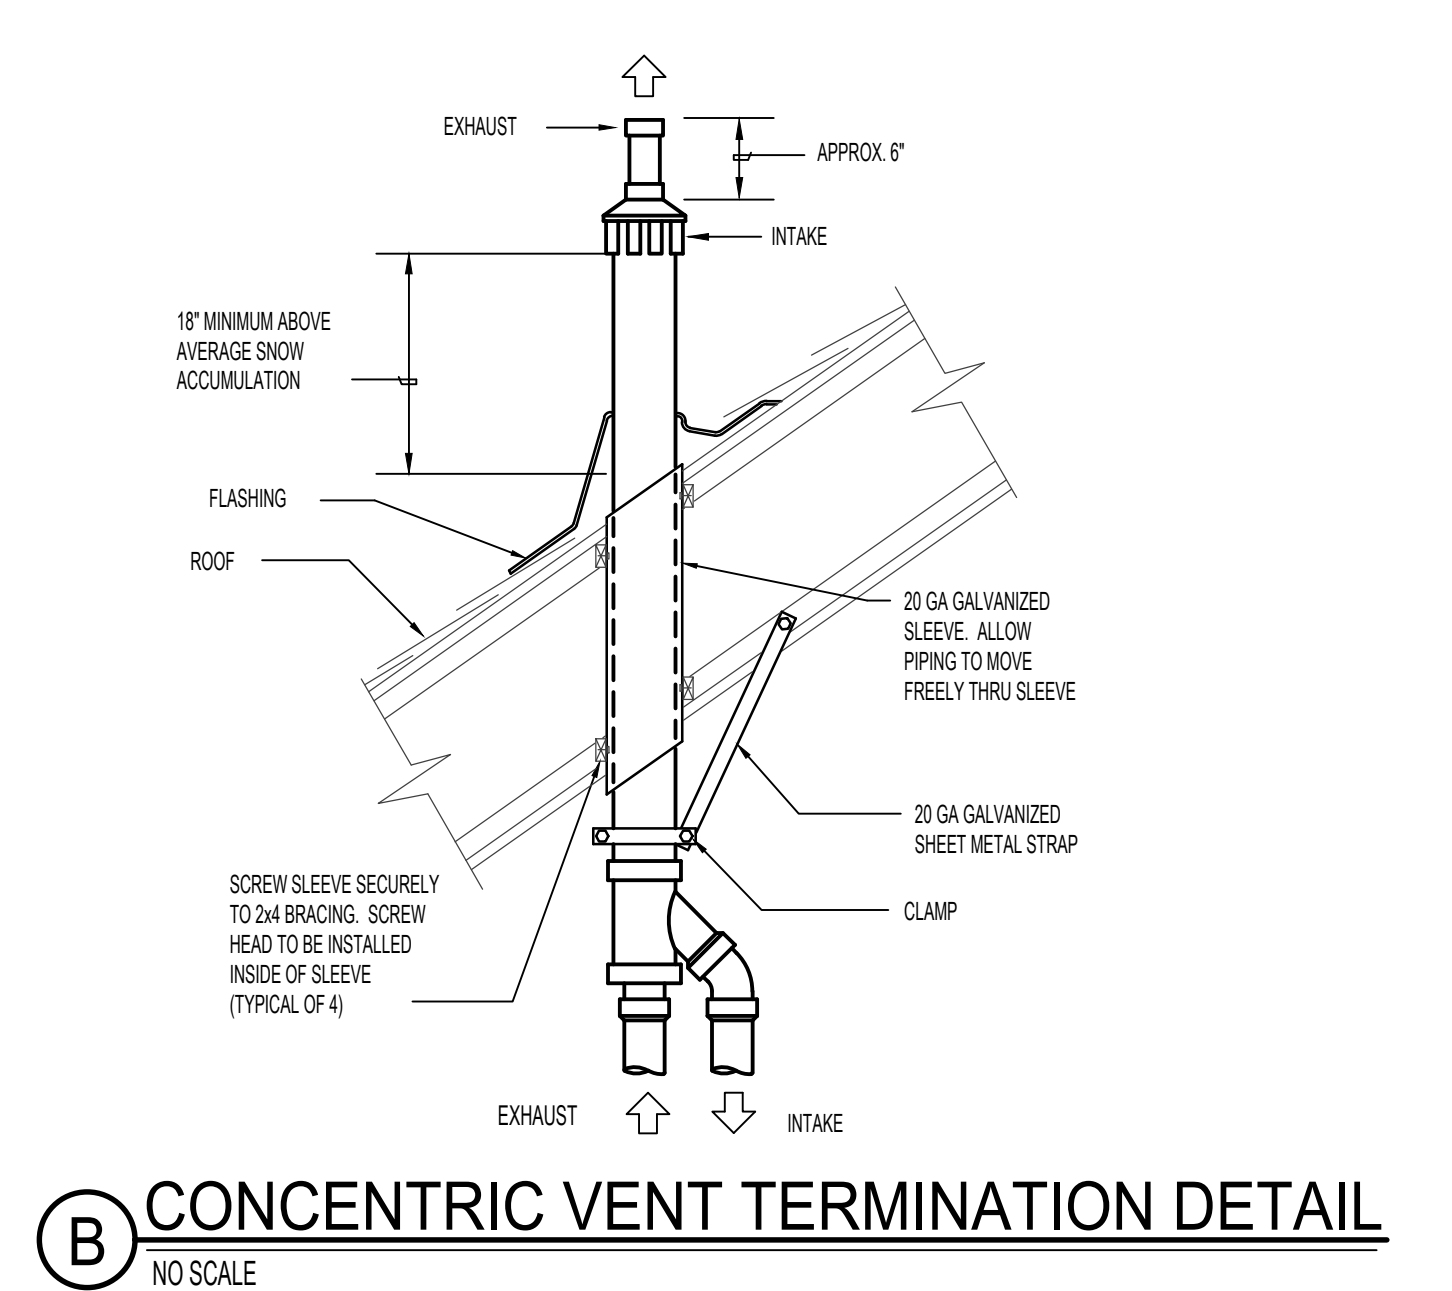


\\esa.local\F-Drive\2121041 LDS Soda Springs.dwg Feb 28, 2023 - 8:03am

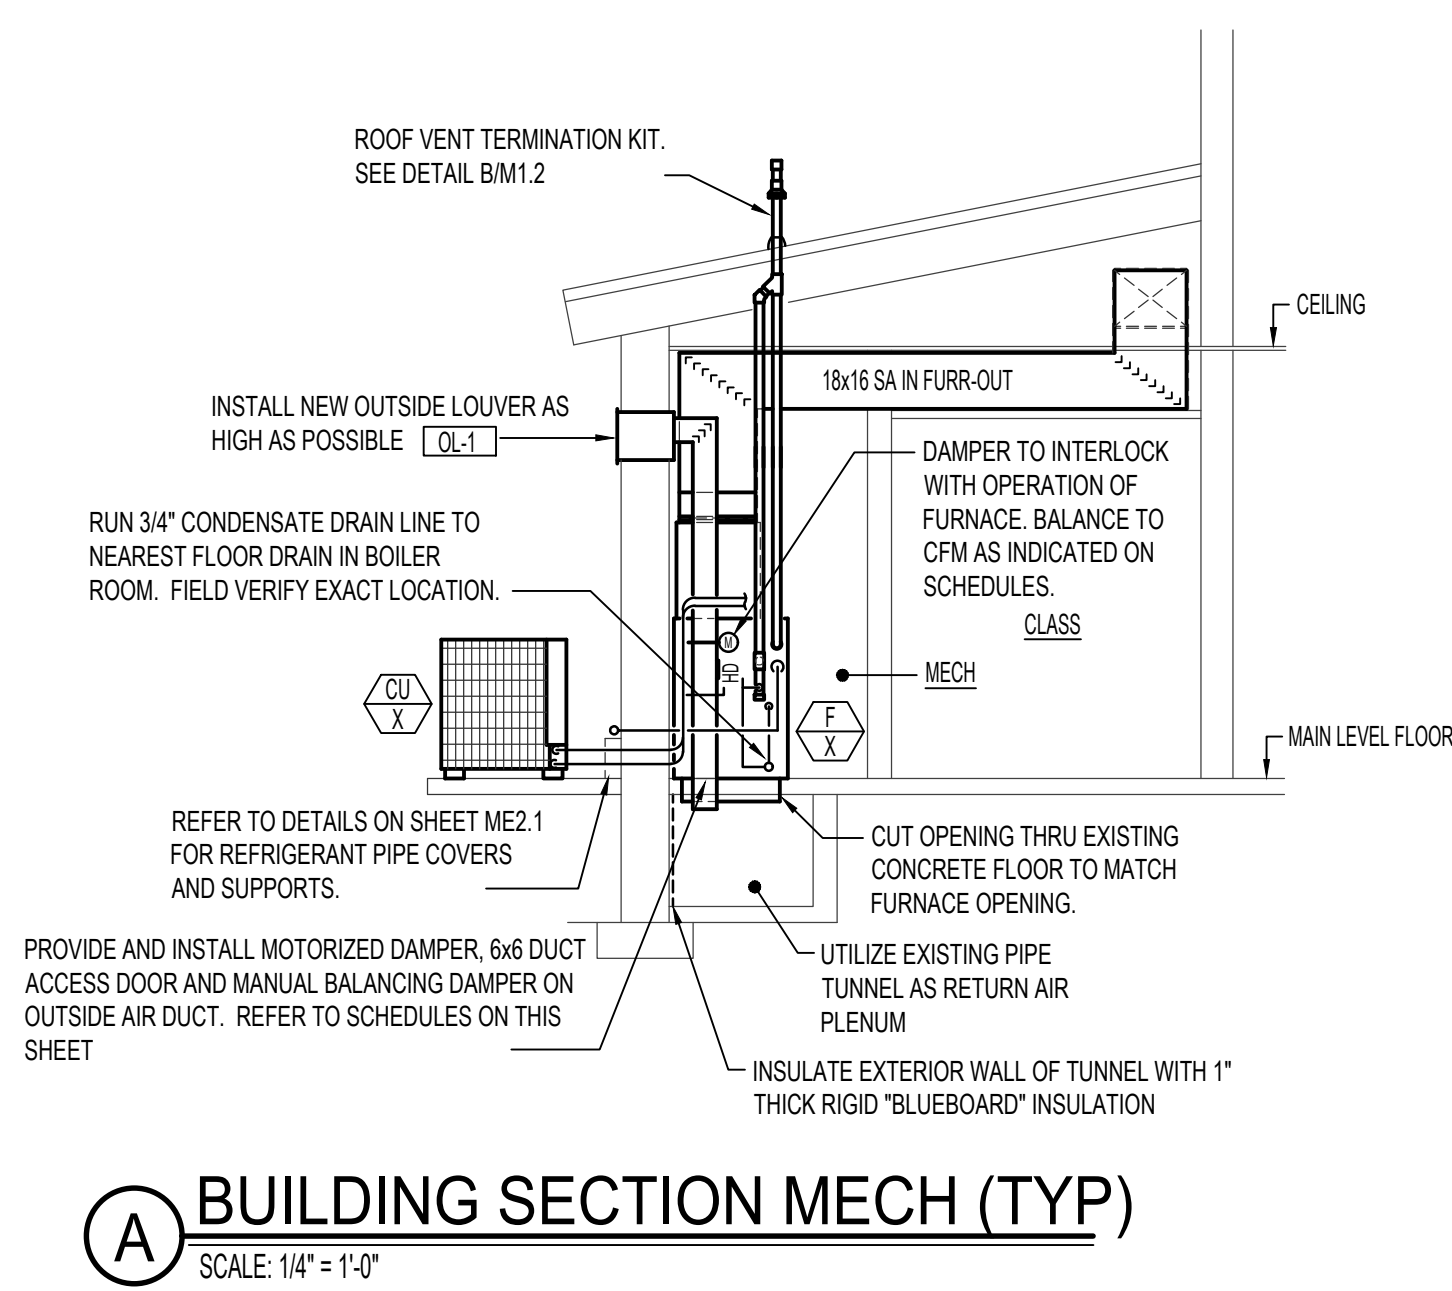

**Engineered Systems Associates**  
**Mechanical Engineers**  
Dwayne Sudweeks P.E., Dave Hansen P.E., Tanner Davis P.E.  
1355 East Center - Pocatello, Idaho 83201  
Phone: (208) 233-0501 email: esa@engsystems.com

PROJECT: HVAC RENOVATIONS FOR:  
**LDS SODA SPRINGS 2, 6 & STAKE**  
290 S. 3RD W., SODA SPRINGS, IDAHO 83276

PROPERTY # 501-3917

SHEET TITLE: MECHANICAL DETAILS

DRWN. BY: TD  
CKD. BY: DCS  
JOB NO: 21041  
DATE: 3/28/2022

SHEET: **M2.1**  
OF: 7