



PLAN NOTES:

- 1 SEE CIVIL SITE PLAN FOR CONTINUATION OF 4" SEWER MAIN.
- 2 SEE CIVIL SITE PLAN FOR CONTINUATION OF 2" DOMESTIC CW MAIN.
- 3 RISE 2" DOMESTIC CW MAIN UP THRU SLAB TO WATER PRESSURE REDUCING VALVE ASSEMBLY. SEE DETAIL ON SHEET P201.
- 4 DROP 3/4" CW AND 1/2" HW DOWN IN WALL TO BELOW COUNTERTOP LEVEL. RUN PIPING UNDER COUNTER TO SERVE FIXTURES AS REQUIRED.
- 5 INSTALL 1/2" BACKFLOW PREVENTOR ON CW LINE SERVING PLUMBING FIXTURE. RUN 3/4" DRAIN FROM BACKFLOW PREVENTOR TO FLOOR SINK MOUNTED UNDER COUNTER AND TERMINATE WITH 90 DEGREE DOWN TURNED ELBOW. SEE DETAIL ON SHEET P201.
- 6 INSTALL HOSE BIBB UNDER LAVATORY. SEE DETAIL ON SHEET P201.
- 7 PROVIDE SCHRADER VALVE AT WATER PRESSURE REDUCING VALVE STATION FOR WINTER SYSTEM DRAIN DOWN.
- 8 INSTALL STOP AND WASTE VALVE IN 2" DOMESTIC CW LINE. SEE DETAIL ON SHEET P201.

SPECIAL NOTE:
 PLUMBING CONTRACTOR TO RUN ALL WATER PIPING IN JOIST SPACE BETWEEN LEVELS IN WARM SPACE. DO NOT RUN WATER PIPING IN COLD ATTIC SPACE.

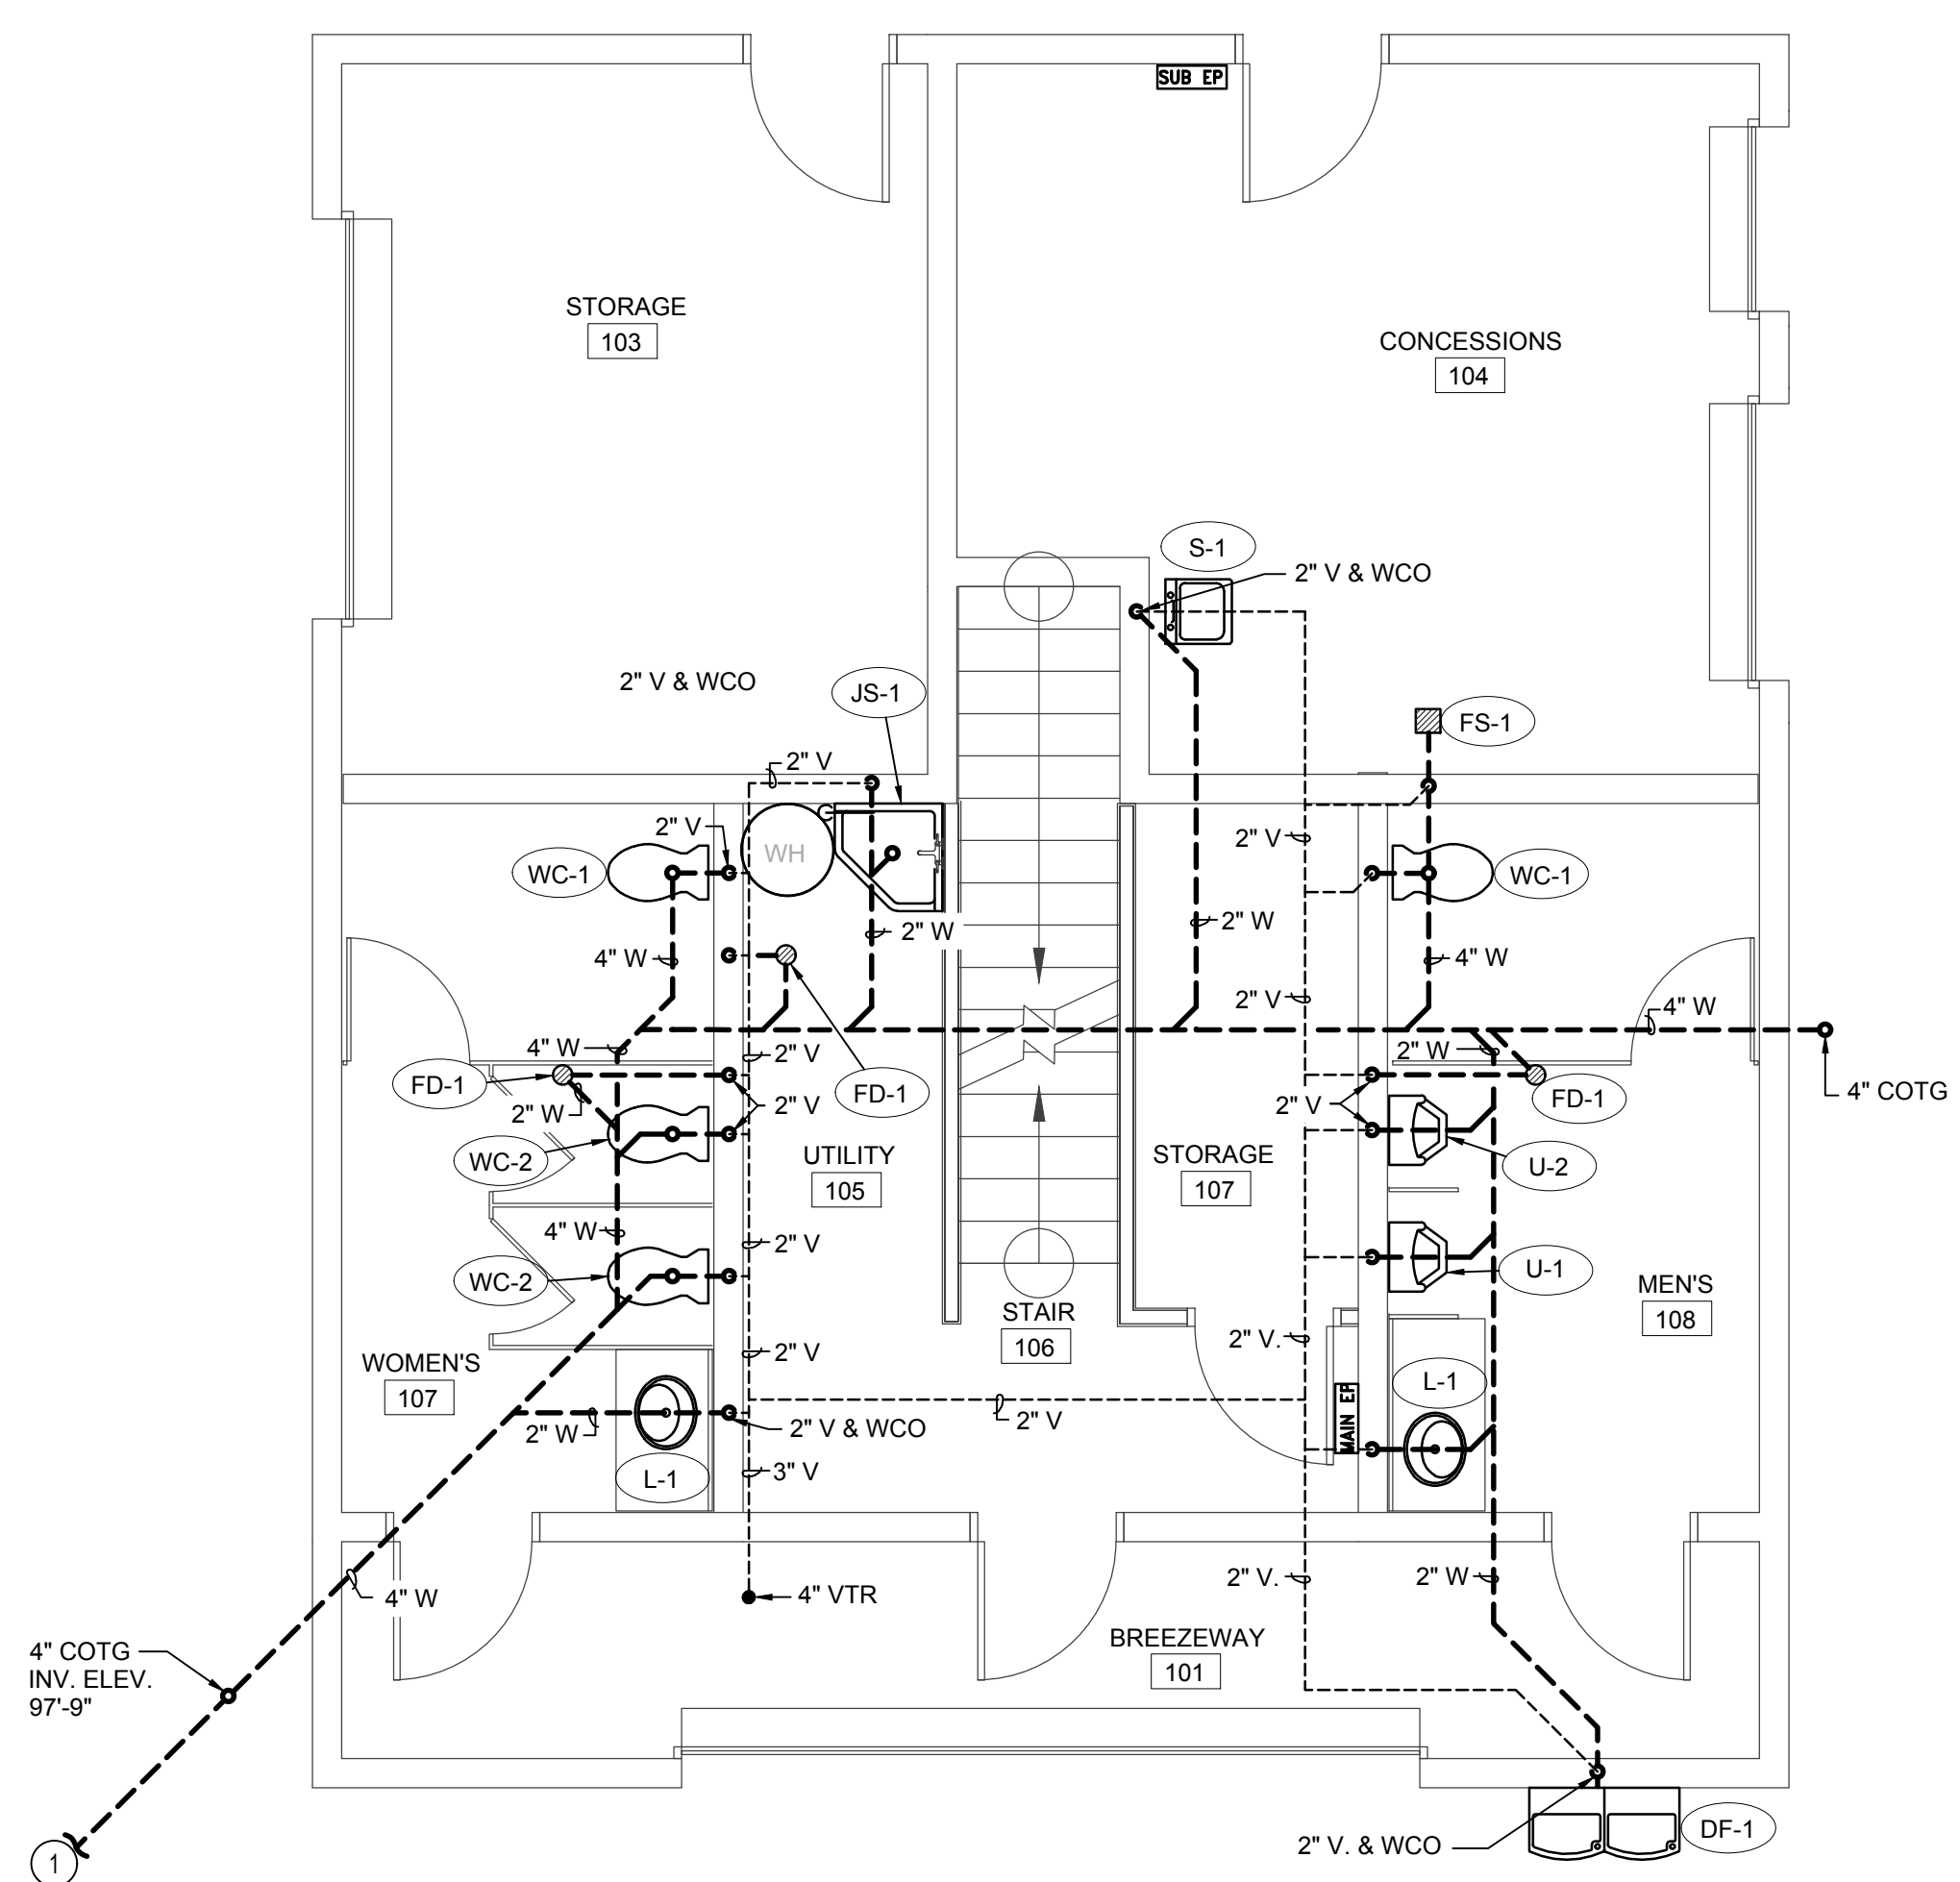



WASTE & VENT PLUMBING PLAN
 SCALE: 1/4" = 1'-0"

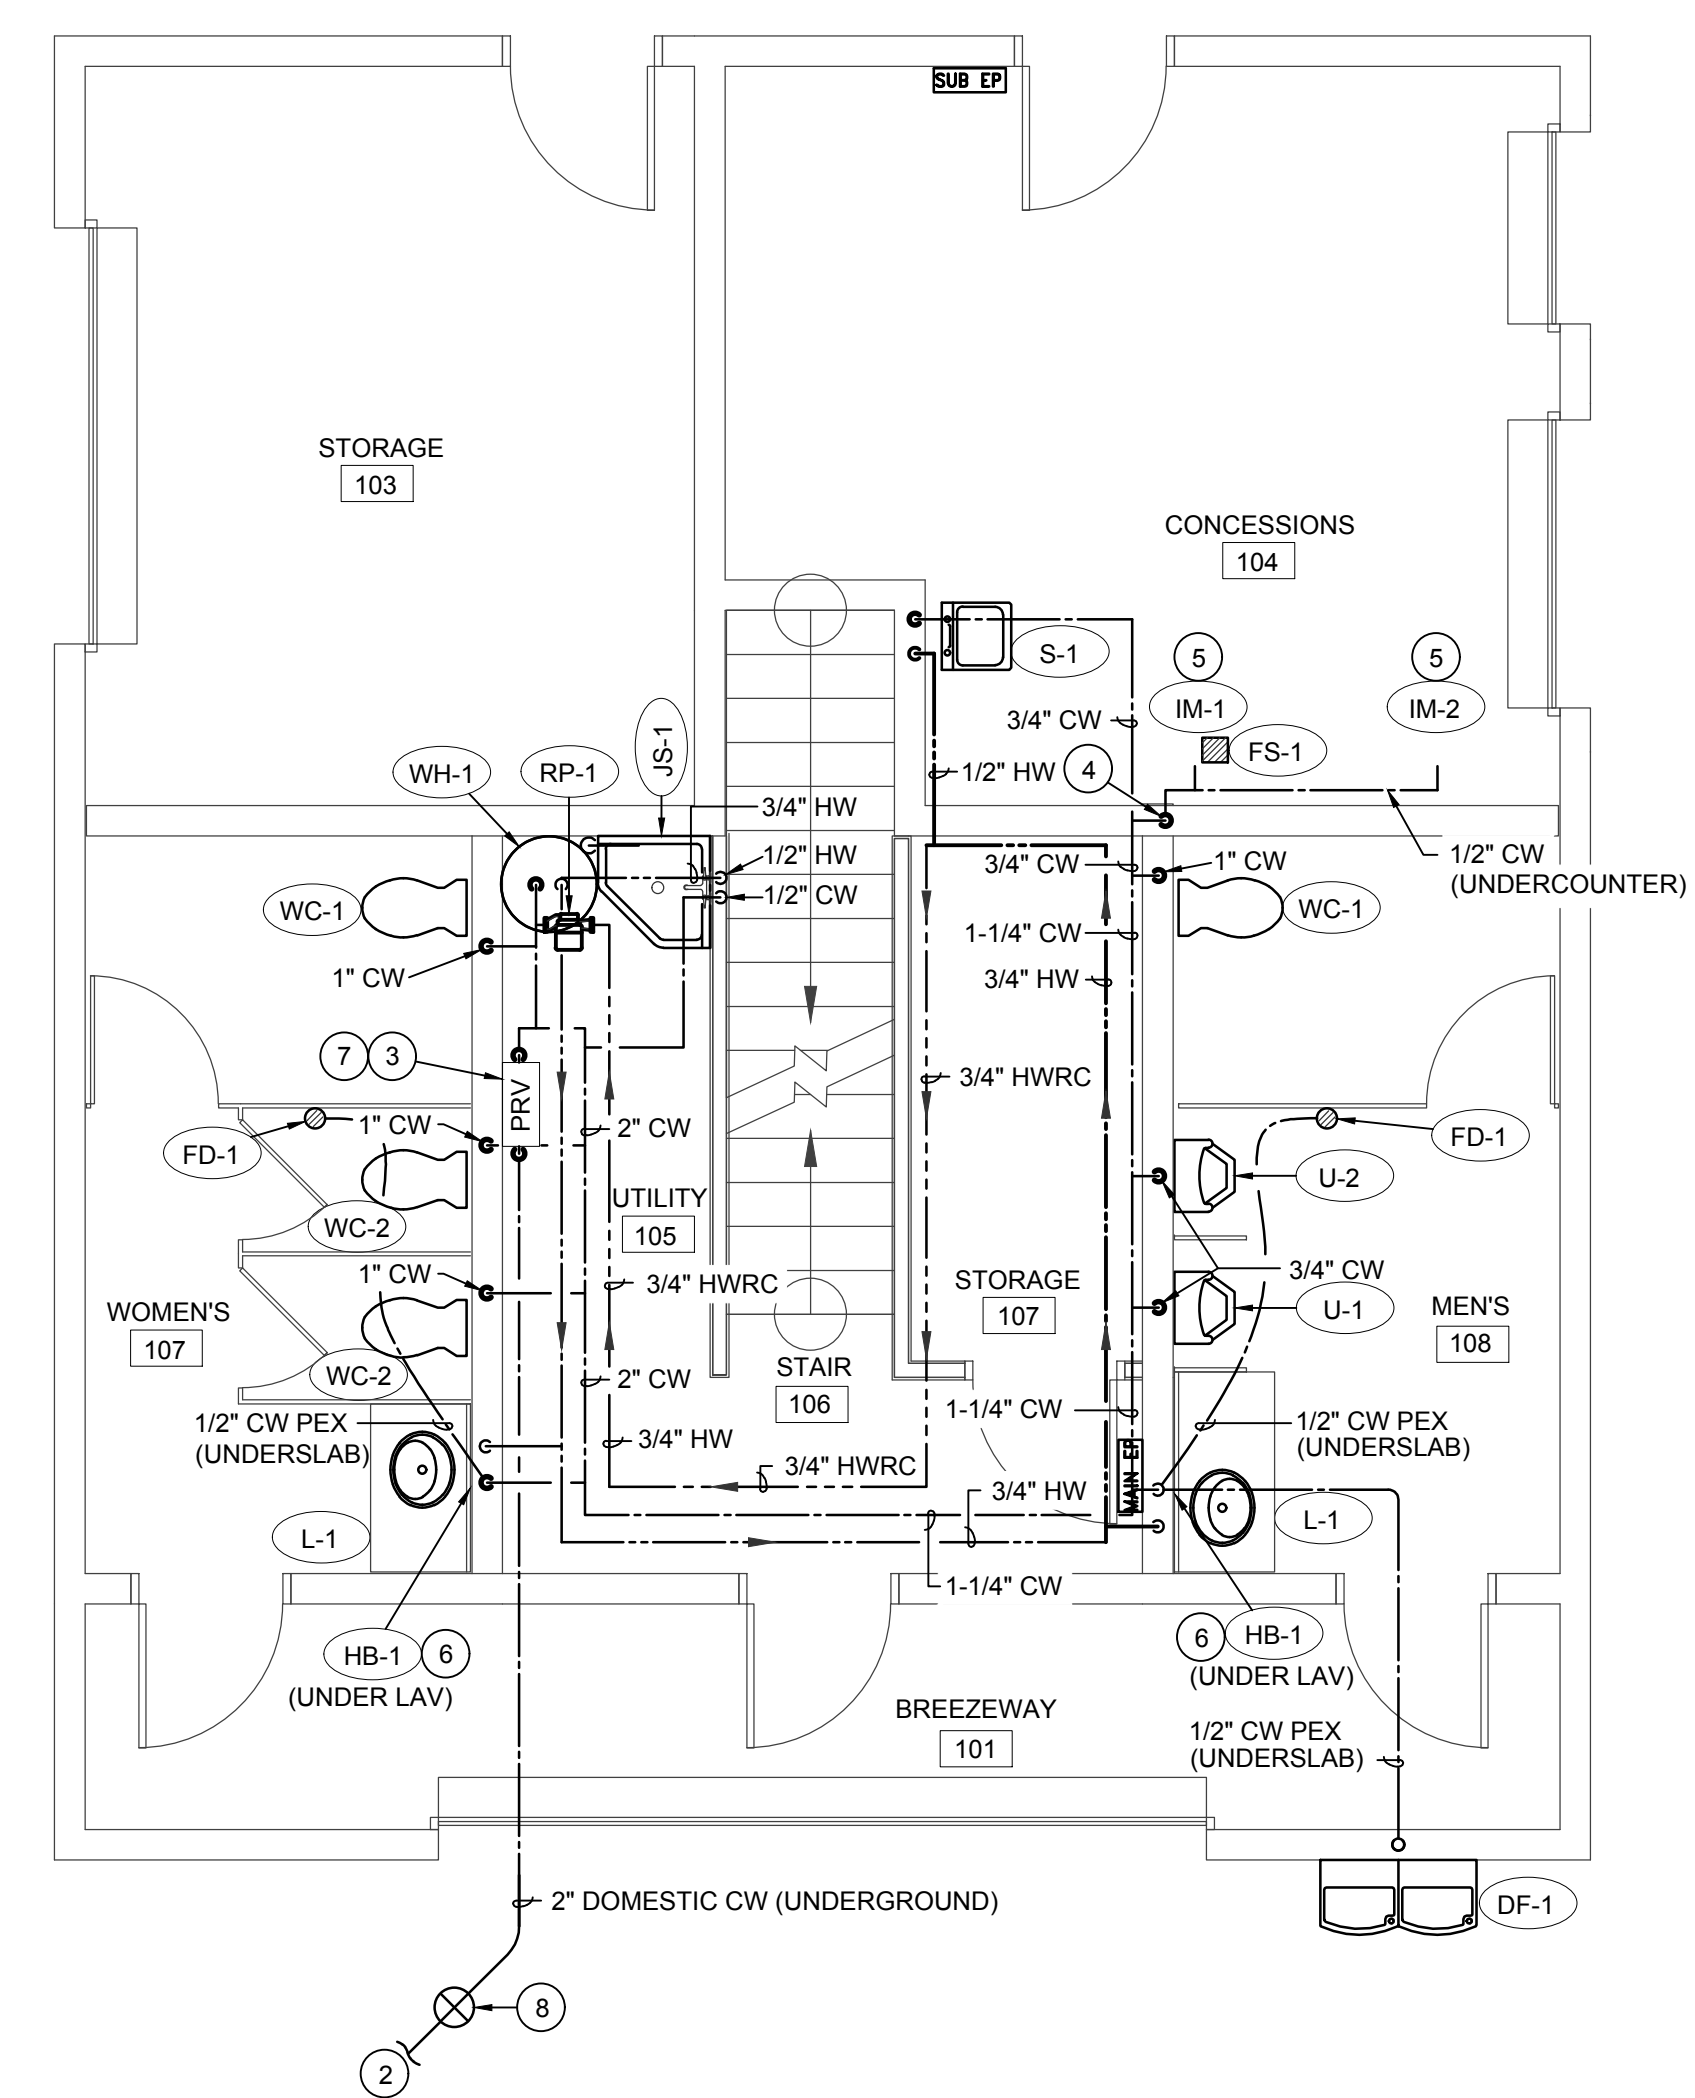

WATER PLUMBING PLAN
 SCALE: 1/4" = 1'-0"

PLUMBING LEGEND

SYMBOL	DESCRIPTION
V	VENT
VTR	VENT THRU ROOF
CO	CLEANOUT
WCO	WALL CLEANOUT
COTG	CLEANOUT TO GRADE
—	PIPE DROP
—	PIPE RISE
⊘	BALL TYPE ISOLATION VALVE
—	SOIL OR WASTE PIPING
—	VENT LINE PIPING
—	HARD COLD WATER PIPING
—	DOMESTIC HOT WATER PIPING
—	DOMESTIC HW RECIRC. PIPING
—140°F	DOMESTIC 140°F HW PIPING
—CD	CONDENSATE DRAIN LINE

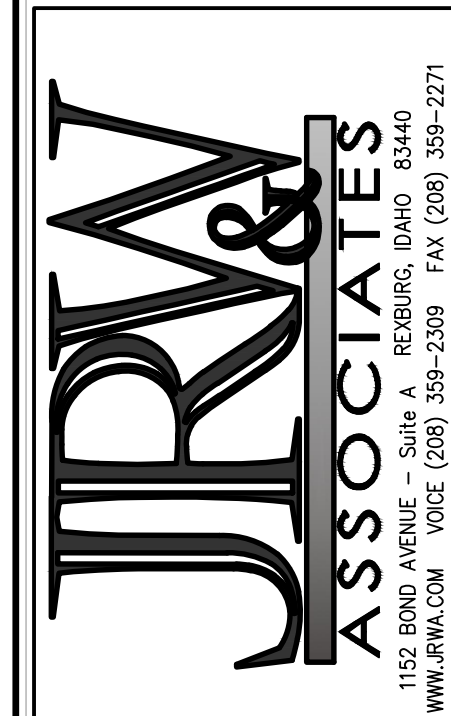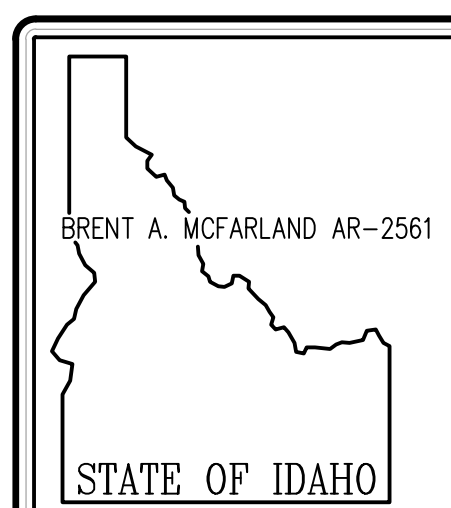

CONSULTANTS:
 MECHANICAL ENGINEERING
 ENGINEERED SYSTEMS ASSOC.
 1355 East Center
 Pocatello, Idaho 83201
 (208) 233-0501
 Fax (801) 233-0529
 ELECTRICAL ENGINEERING
 PAYNE ENGINEERING INC.
 1823 E. Center St.
 Pocatello, Idaho 83201
 (208) 232-4439
 Fax (208) 232-1435

MADISON BASEBALL BOOTH
 PROJECT:
PLUMBING FLOOR PLANS
 DRAWING TITLE:

REVISION:

#	DATE	COMMENT

DRAWN BY: TP JOB NO: -
 CHECKED BY: DCS DATE: 09/16/2022
 PLOT DATE: 09-16-22

Engineered Systems Associates
 1355 EAST CENTER
 POCATELLO, IDAHO 83201
 PHONE: (208) 233-0501
 EMAIL: eso@engsystems.com
 ESA JOB NUMBER: 221.37

PROFESSIONAL ENGINEER
 LICENSED
 STATE OF IDAHO
 TANNER C. DAVIS
 Sep 16, 2022

DRAWING NO.
 FILE: 22137 Madison Baseball Booth P101.dwg
P101
 OF 4