

KEYED NOTES:

- # SYMBOL USED FOR NOTE CALLOUT.
- 1. ELECTRICAL CONTRACTOR TO DISCONNECT ELECTRICAL CONNECTION FROM NOTED HVAC EQUIPMENT. ELECTRICAL CONTRACTOR TO REUSE OR REMOVE ALL ELECTRICAL EQUIPMENT, CONDUIT, AND CONDUCTORS BACK TO THE PANEL. VERIFY CIRCUIT PRIOR TO REMOVAL.
- 2. ELECTRICAL CONTRACTOR TO DISCONNECT ELECTRICAL CONNECTION FROM NOTED HVAC EQUIPMENT AND REMOVE ALL ELECTRICAL EQUIPMENT, CONDUIT, AND CONDUCTORS BACK TO THE PANEL. VERIFY CIRCUIT PRIOR TO REMOVAL. NOTED HVAC EQUIPMENT REMOVED BY MECHANICAL CONTRACTOR.
- 3. REMOVE CONDUIT, LINE VOLTAGE, AND CONTROL CONDUCTORS TO FAN COIL UNIT OR THERMOSTAT. COORDINATE WITH GENERAL CONTRACTOR TO FILL AND PATCH ANY HOLES INTO THE BUILDING.
- 4. THERMOSTAT JUNCTION BOX TO BE REMOVED BY ELECTRICAL CONTRACTOR. GENERAL CONTRACTOR TO PATCH AND PAINT HOLE TO MATCH EXISTING WALL.
- 5. EXISTING CONTROLS CONDUIT OR THERMOSTAT JUNCTION BOX TO REMAIN. PRESERVE AND PROTECT DURING CONSTRUCTION.
- 6. REMOVE CONDUIT, LINE VOLTAGE, AND CONTROL CONDUCTORS FROM HVAC EQUIPMENT.
- 7. UNKNOWN CIRCUIT CONNECTED TO HVAC EQUIPMENT - VERIFY PRIOR TO ANY WORK.
- 8. BASE BID
- 9. ALTERNATE #1
- 10. ALTERNATE #2
- 11. ALTERNATE #3

Architect / Engineer:
P.C. Architects Inc.
 Dennis B. Patten, AIA
 P.O. Box 217
 St. George, UT 84771
 (435) 673-6579

Expiration date of license: 04/30/22
 This work was prepared by me or under my supervision. Construction of this project will be under my observation.
 (Observation is defined by Hawaii Administrative Rules §15-115 for Professional Landscape Architects)



Project Name:
KALIHI RE-ROOF AND HVAC REFURBISHMENT
 HONOLULU, HAWAII WEST STAKE
 1120 Kahlili St. (1723 Beckley St.) Honolulu, HI 96819
 TMK: 1-3-005-17

Owner:
THE CHURCH OF JESUS CHRIST OF LATTER-DAY SAINTS

BID SET	Date (m.d.y)	Description
1	09-01-2021	EXISTING

Project Number:
PCA-2013
 Plan Series:
EXISTING
 Property Number:
500-0031-919010101

Sheet Title:
MECHANICAL POWER DEMOLITION PLAN
 Sheet:
E100

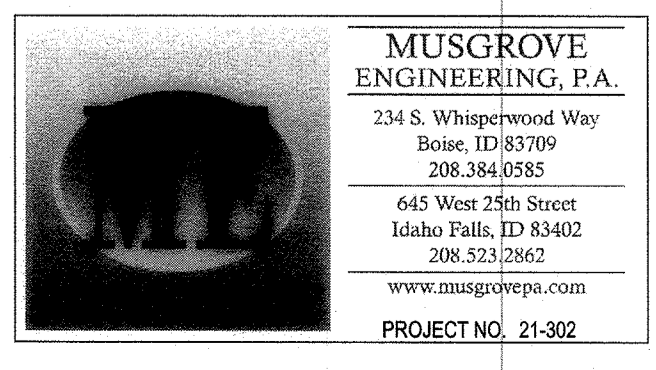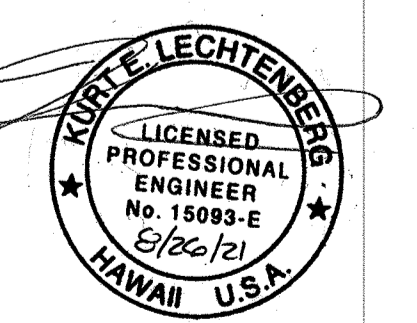

MAIN FLOOR MECHANICAL POWER PLAN
 SCALE: 1/8" = 1'-0"
 North