



F:\18043 STRATA AP1518043 TOWNHOMES\TOWNHOMES M102.dwg Jan 29, 2014 - 8:50am

SPECIAL NOTE:
SEE LARGE SCALE PLANS ON SHEETS M200 FOR TYPICAL DUCTWORK AND MECHANICAL EQUIPMENT LAY-OUT FOR INDIVIDUAL TOWN HOME TYPES.

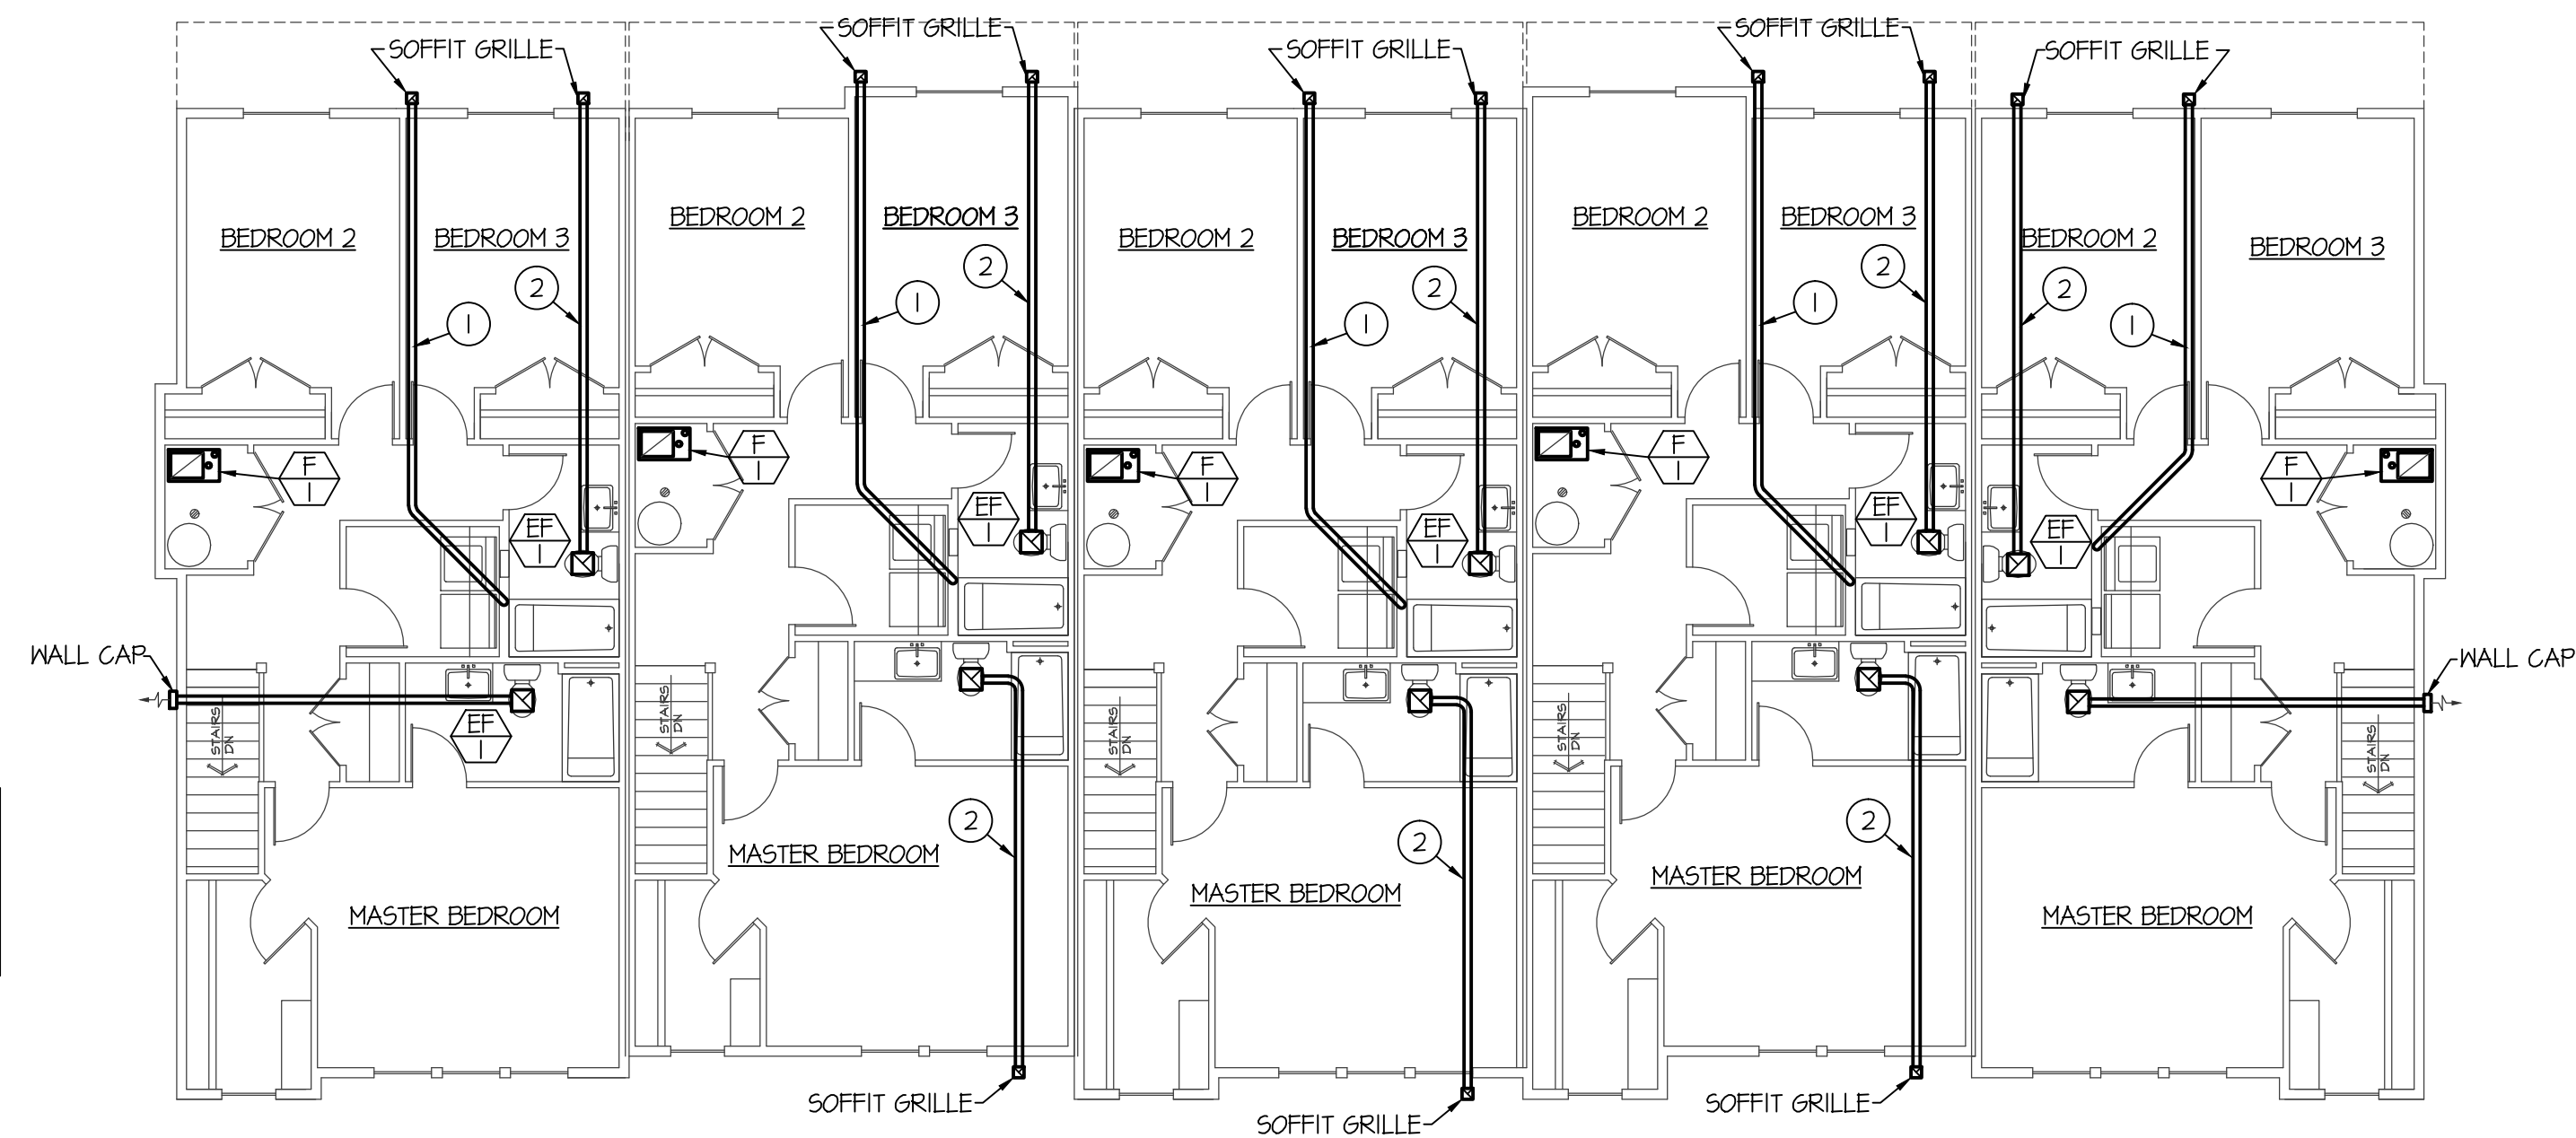

BUILDING "A" UPPER LEVEL MECHANICAL PLAN
SCALE: 1/8" = 1'-0"

SPECIAL NOTE:
SEE LARGE SCALE PLANS ON SHEETS M200 FOR TYPICAL DUCTWORK AND MECHANICAL EQUIPMENT LAY-OUT FOR INDIVIDUAL TOWN HOME TYPES.

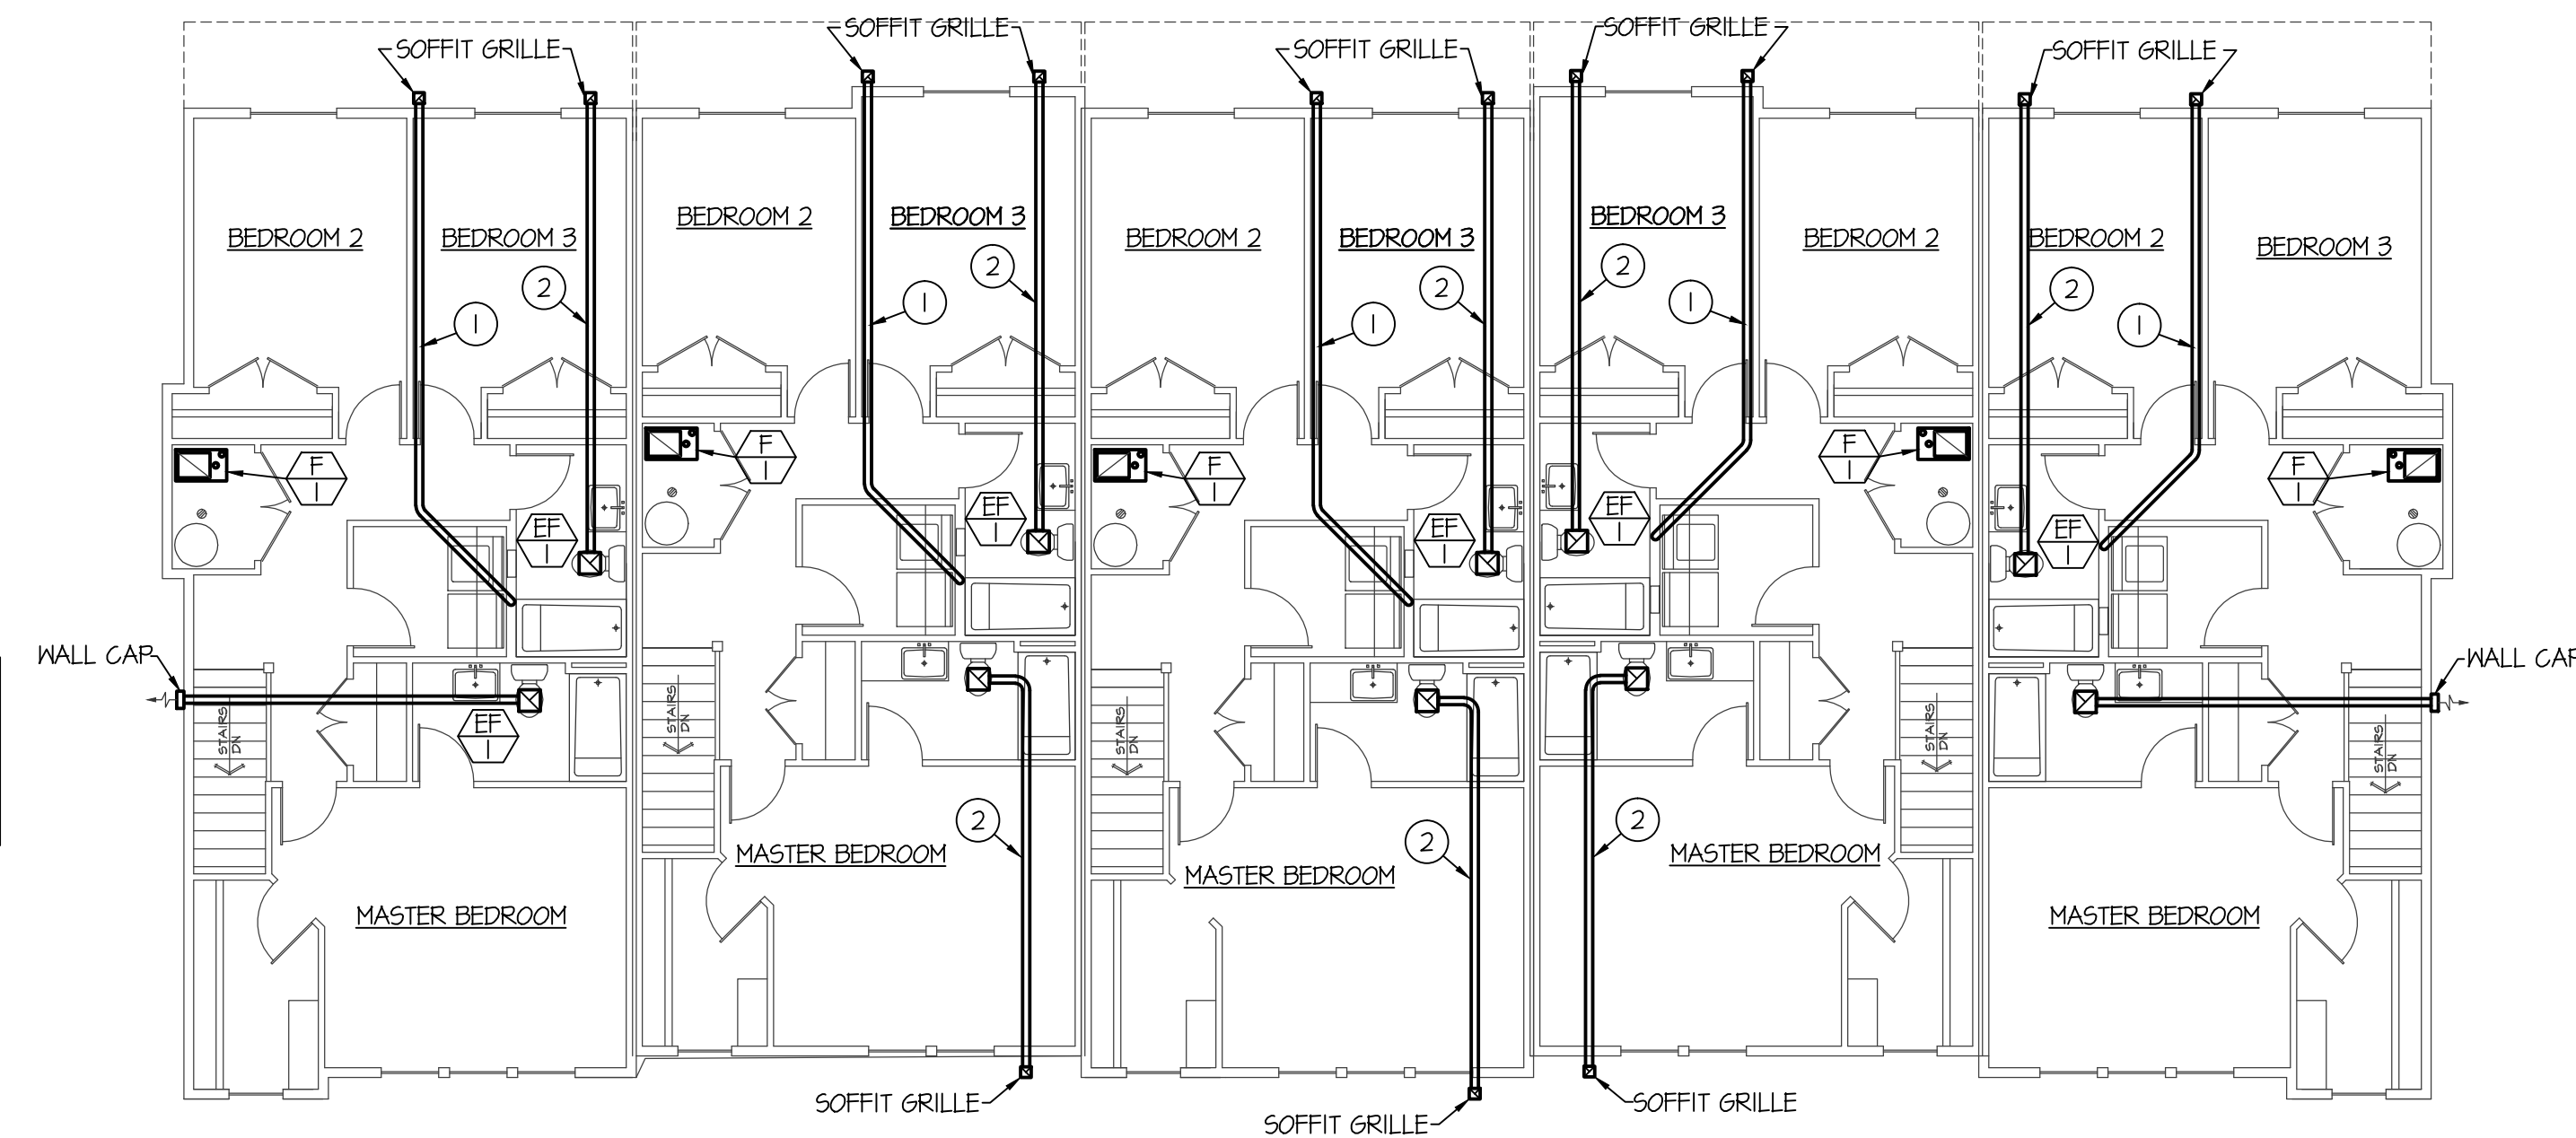

BUILDING "B" UPPER LEVEL MECHANICAL PLAN
SCALE: 1/8" = 1'-0"

PLAN NOTES:


- ① RUN 4" DRYER VENT TO SOFFIT GRILLE AS SHOWN. SEE ALSO LARGE SCALE MECH. PLANS ON SHEET M200
- ② RUN 4" EXHAUST DUCT TO SOFFIT GRILLE AS SHOWN.



Enginered Systems Associates
Mechanical Engineers
Dwayne Sudweeks
1355 East Center - Pocatello, Idaho 83201
Phone: (208) 233-0501 Fax: (208) 233-0529 email: eso@engsystems.com

STRATA TOWNHOMES
LOGAN, UTAH
UPPER LEVEL MECHANICAL PLANS

PROJECT:
SHEET TITLE:

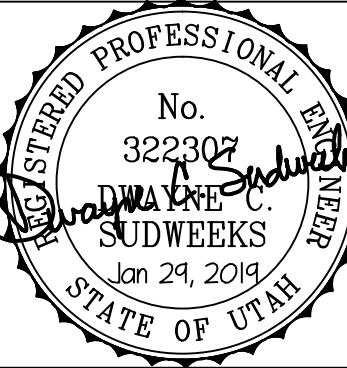

DRWN. BY: SR	CHK. BY: DCS
JOB NO. 18043	DATE: DEC. 2018

SHEET:
M102
OF: THREE