



F:\18043 STRATA APF1518043 TOWNHOMES\TOWNHOMES P102.dwg Jan 24, 2014 - 8:57am

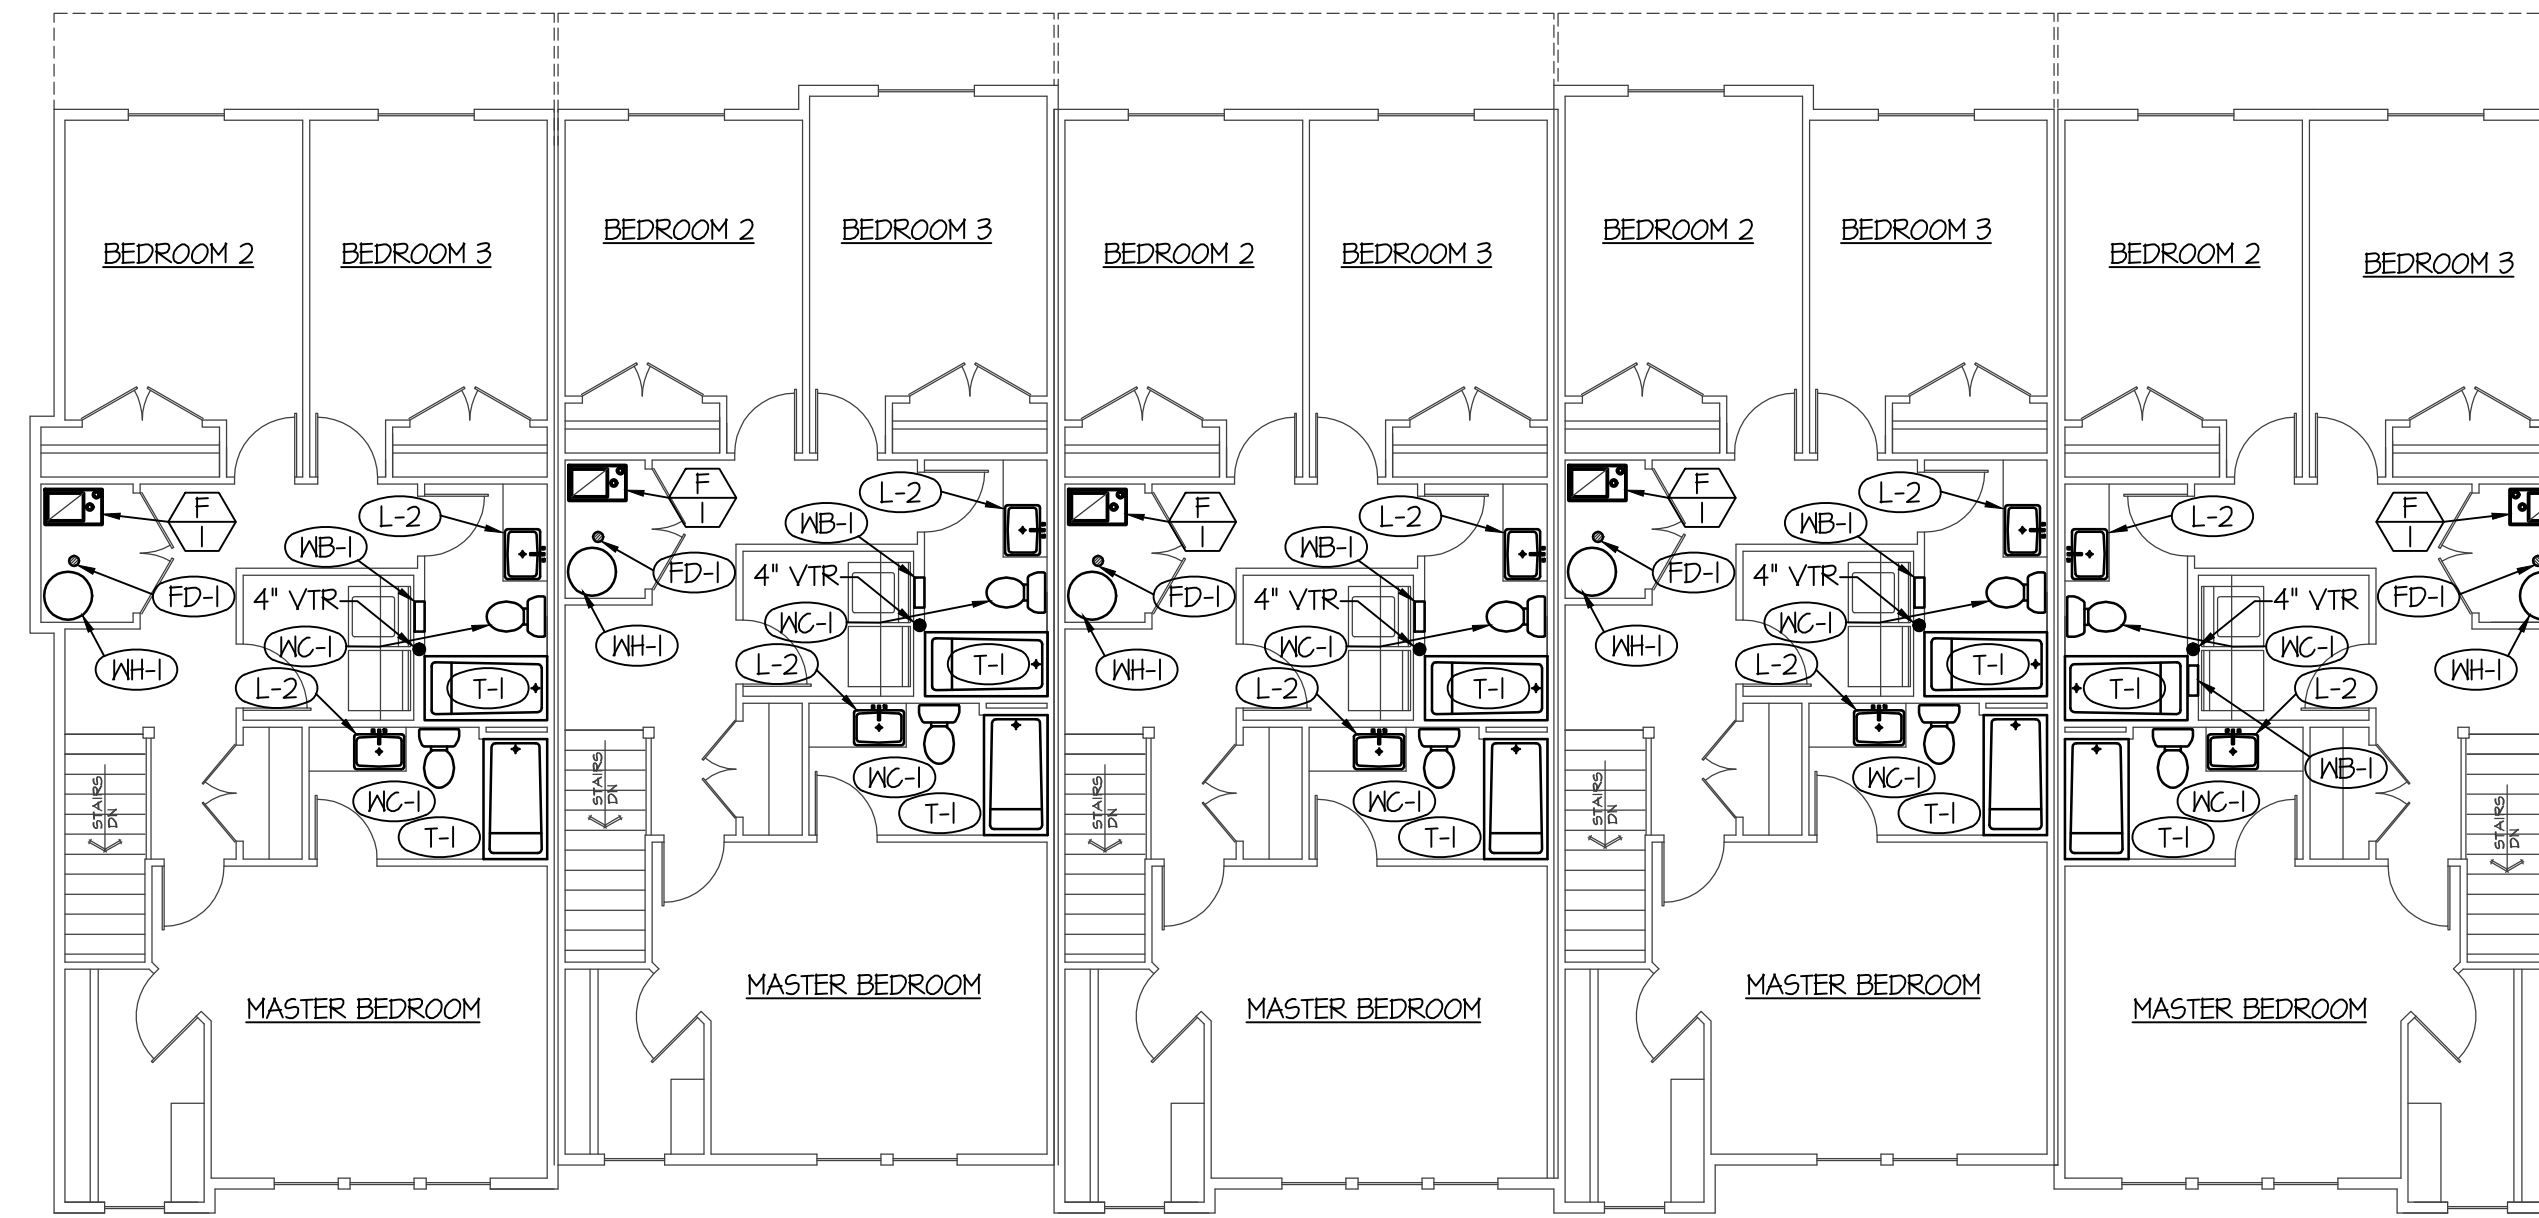

SPECIAL NOTE:
MIRROR PLANS AS REQUIRED FOR
INDIVIDUAL SITE LAY-OUT

BUILDING "A" UPPER LEVEL PLUMBING PLAN

SCALE: 1/8" = 1'-0"

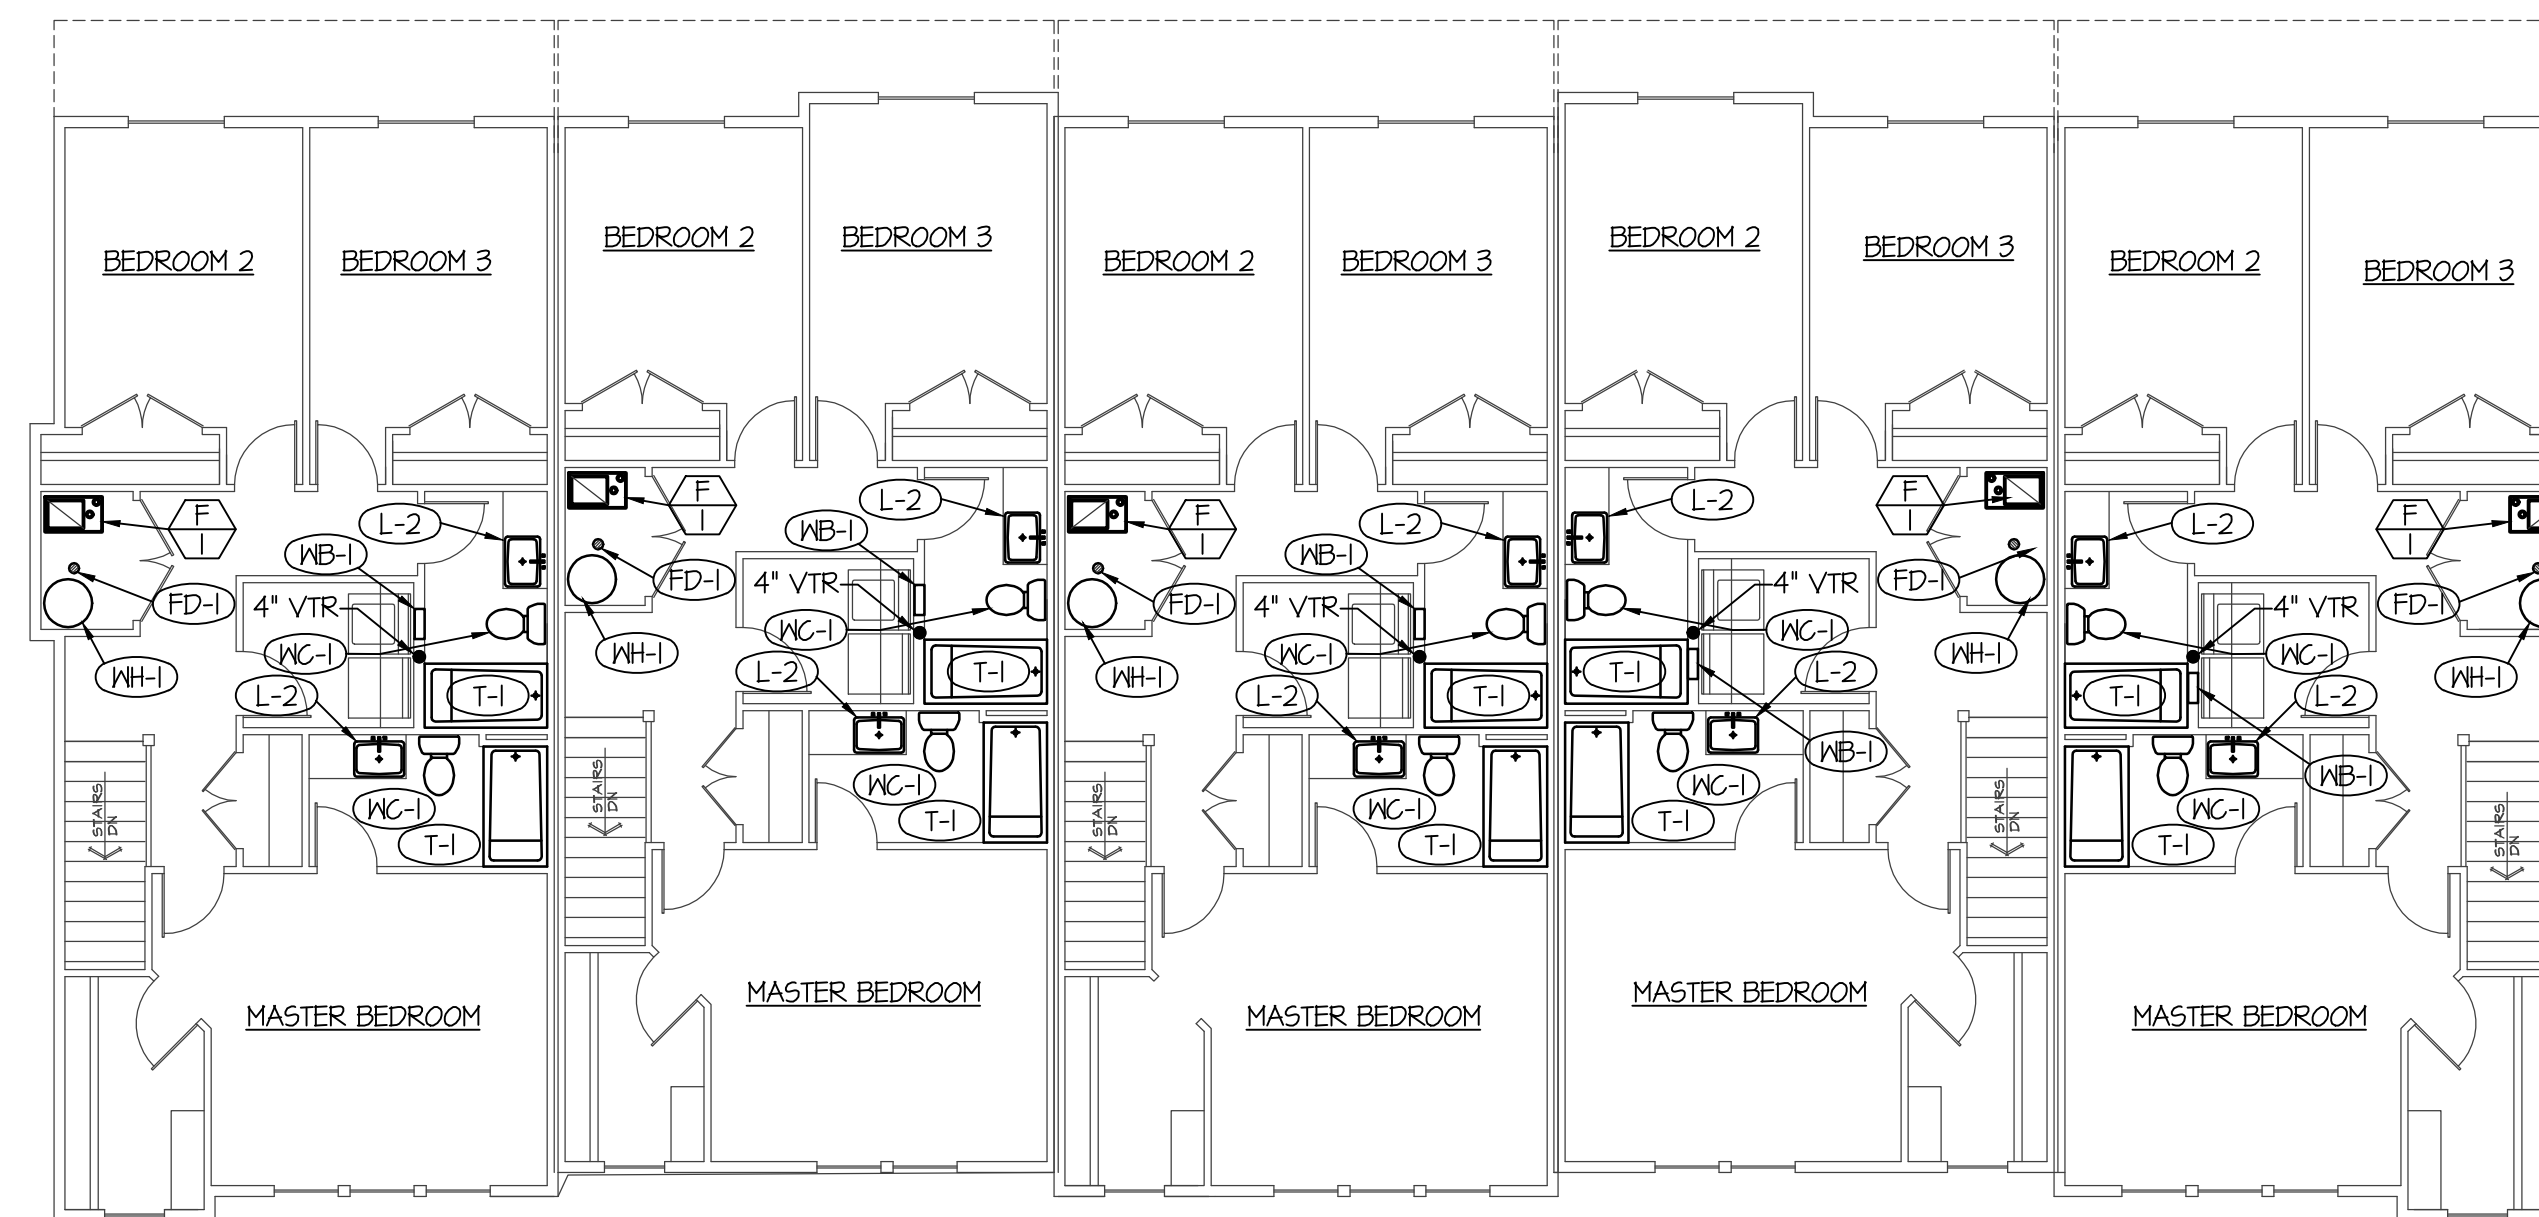

SPECIAL NOTE:
MIRROR PLANS AS REQUIRED FOR
INDIVIDUAL SITE LAY-OUT

BUILDING "B" UPPER LEVEL PLUMBING PLAN

SCALE: 1/8" = 1'-0"



Engineered Systems Associates
Mechanical Engineers


Dwayne Sudweeks
1355 East Center - Pocatello, Idaho 83201
Phone: (208) 233-0501 Fax: (208) 233-0529 email: eso@engsystems.com

STRATA TOWNHOMES
LOGAN, UTAH

UPPER LEVEL PLUMBING PLANS

PROJECT:

SHEET TITLE:

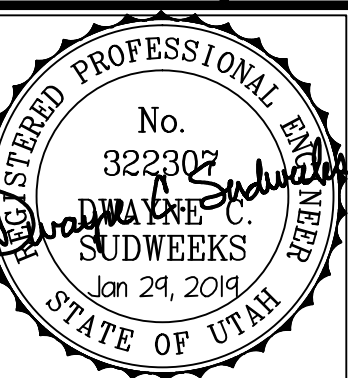

DRWN. BY: SR	CHK. BY: DCS
JOB NO. 18043	DATE: DEC. 2018

SHEET:
P102
OF: FOUR